


PROPOSED

General Notes
1. THIS DRAWING IS THE COPYRIGHT OF PETER TESAR ARCHITECTURAL DESIGN AND MUST NOT BE USED, EDITED OR REPRODUCED WITHOUT PERMISSION.
2. INACCESSIBLE AREAS FOR SITE MEASURE & SURVEY HAVE BEEN ASSUMED




1 Front Elevation
Scale: 1:50



Legend	
	Radiators
	Gas Meter
	Electric Unit
	Fuse Board
	Hot Water Heater (electric)

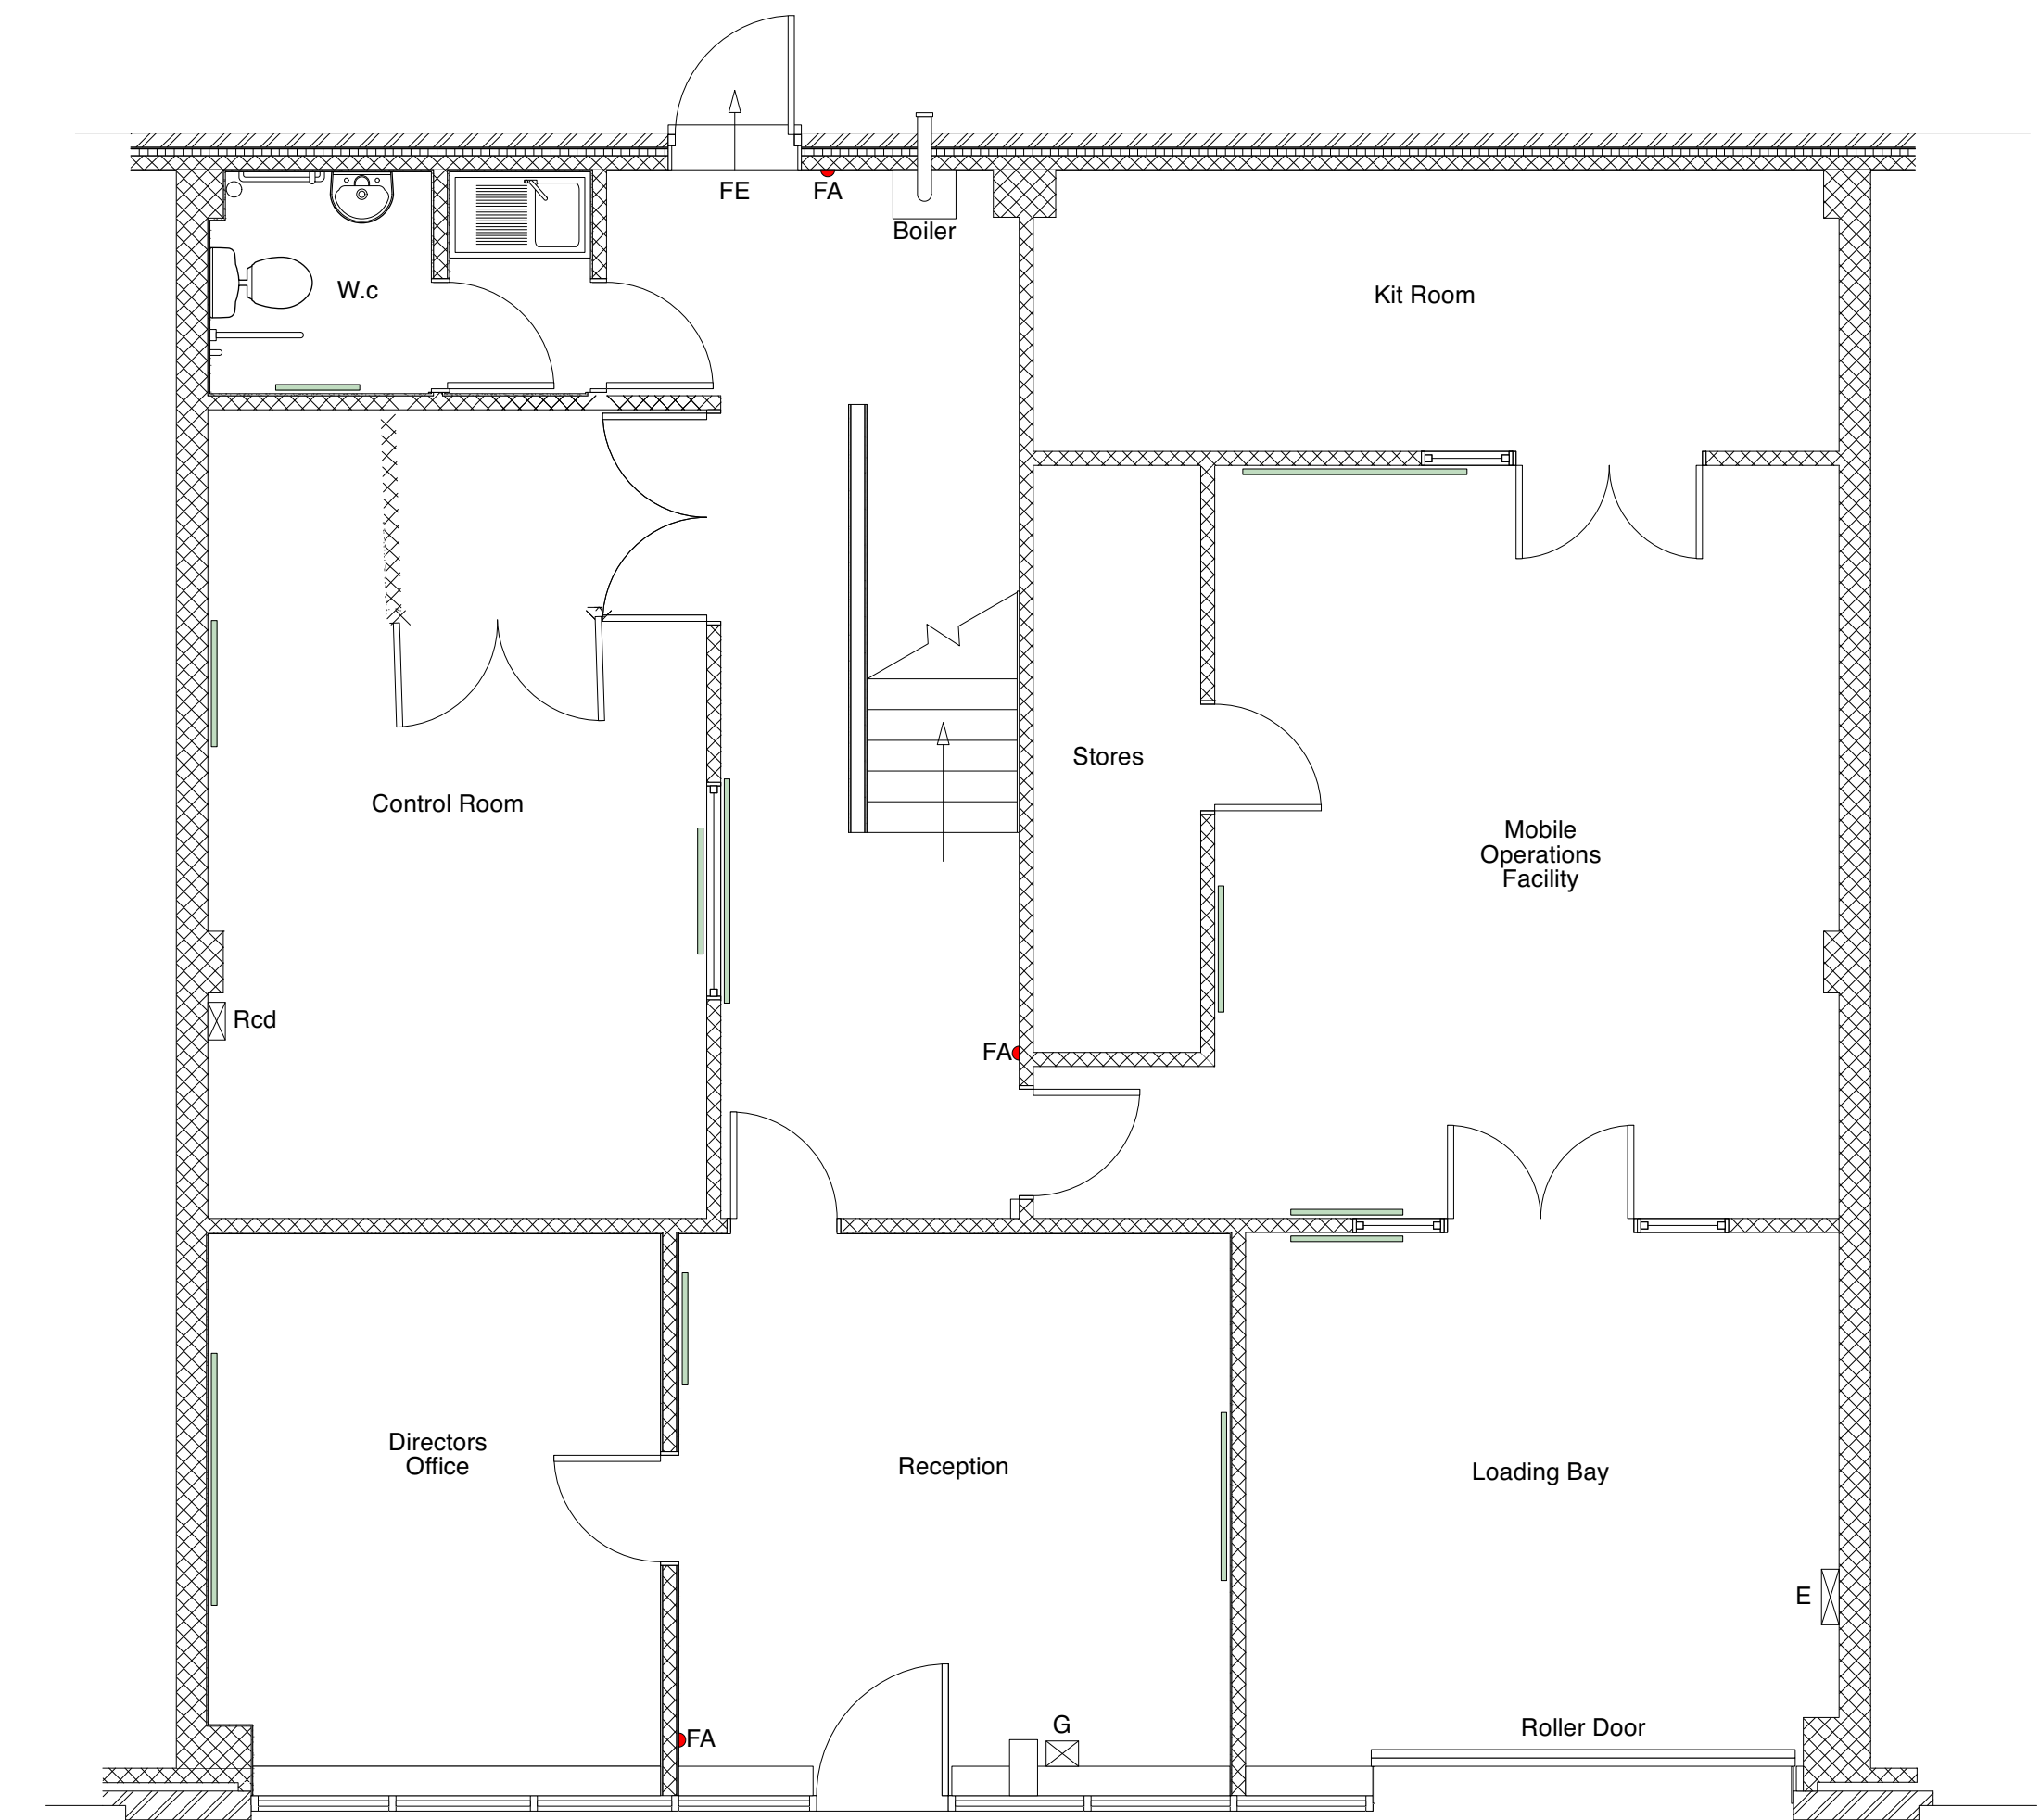

2 Ground Floor
Scale: 1:50

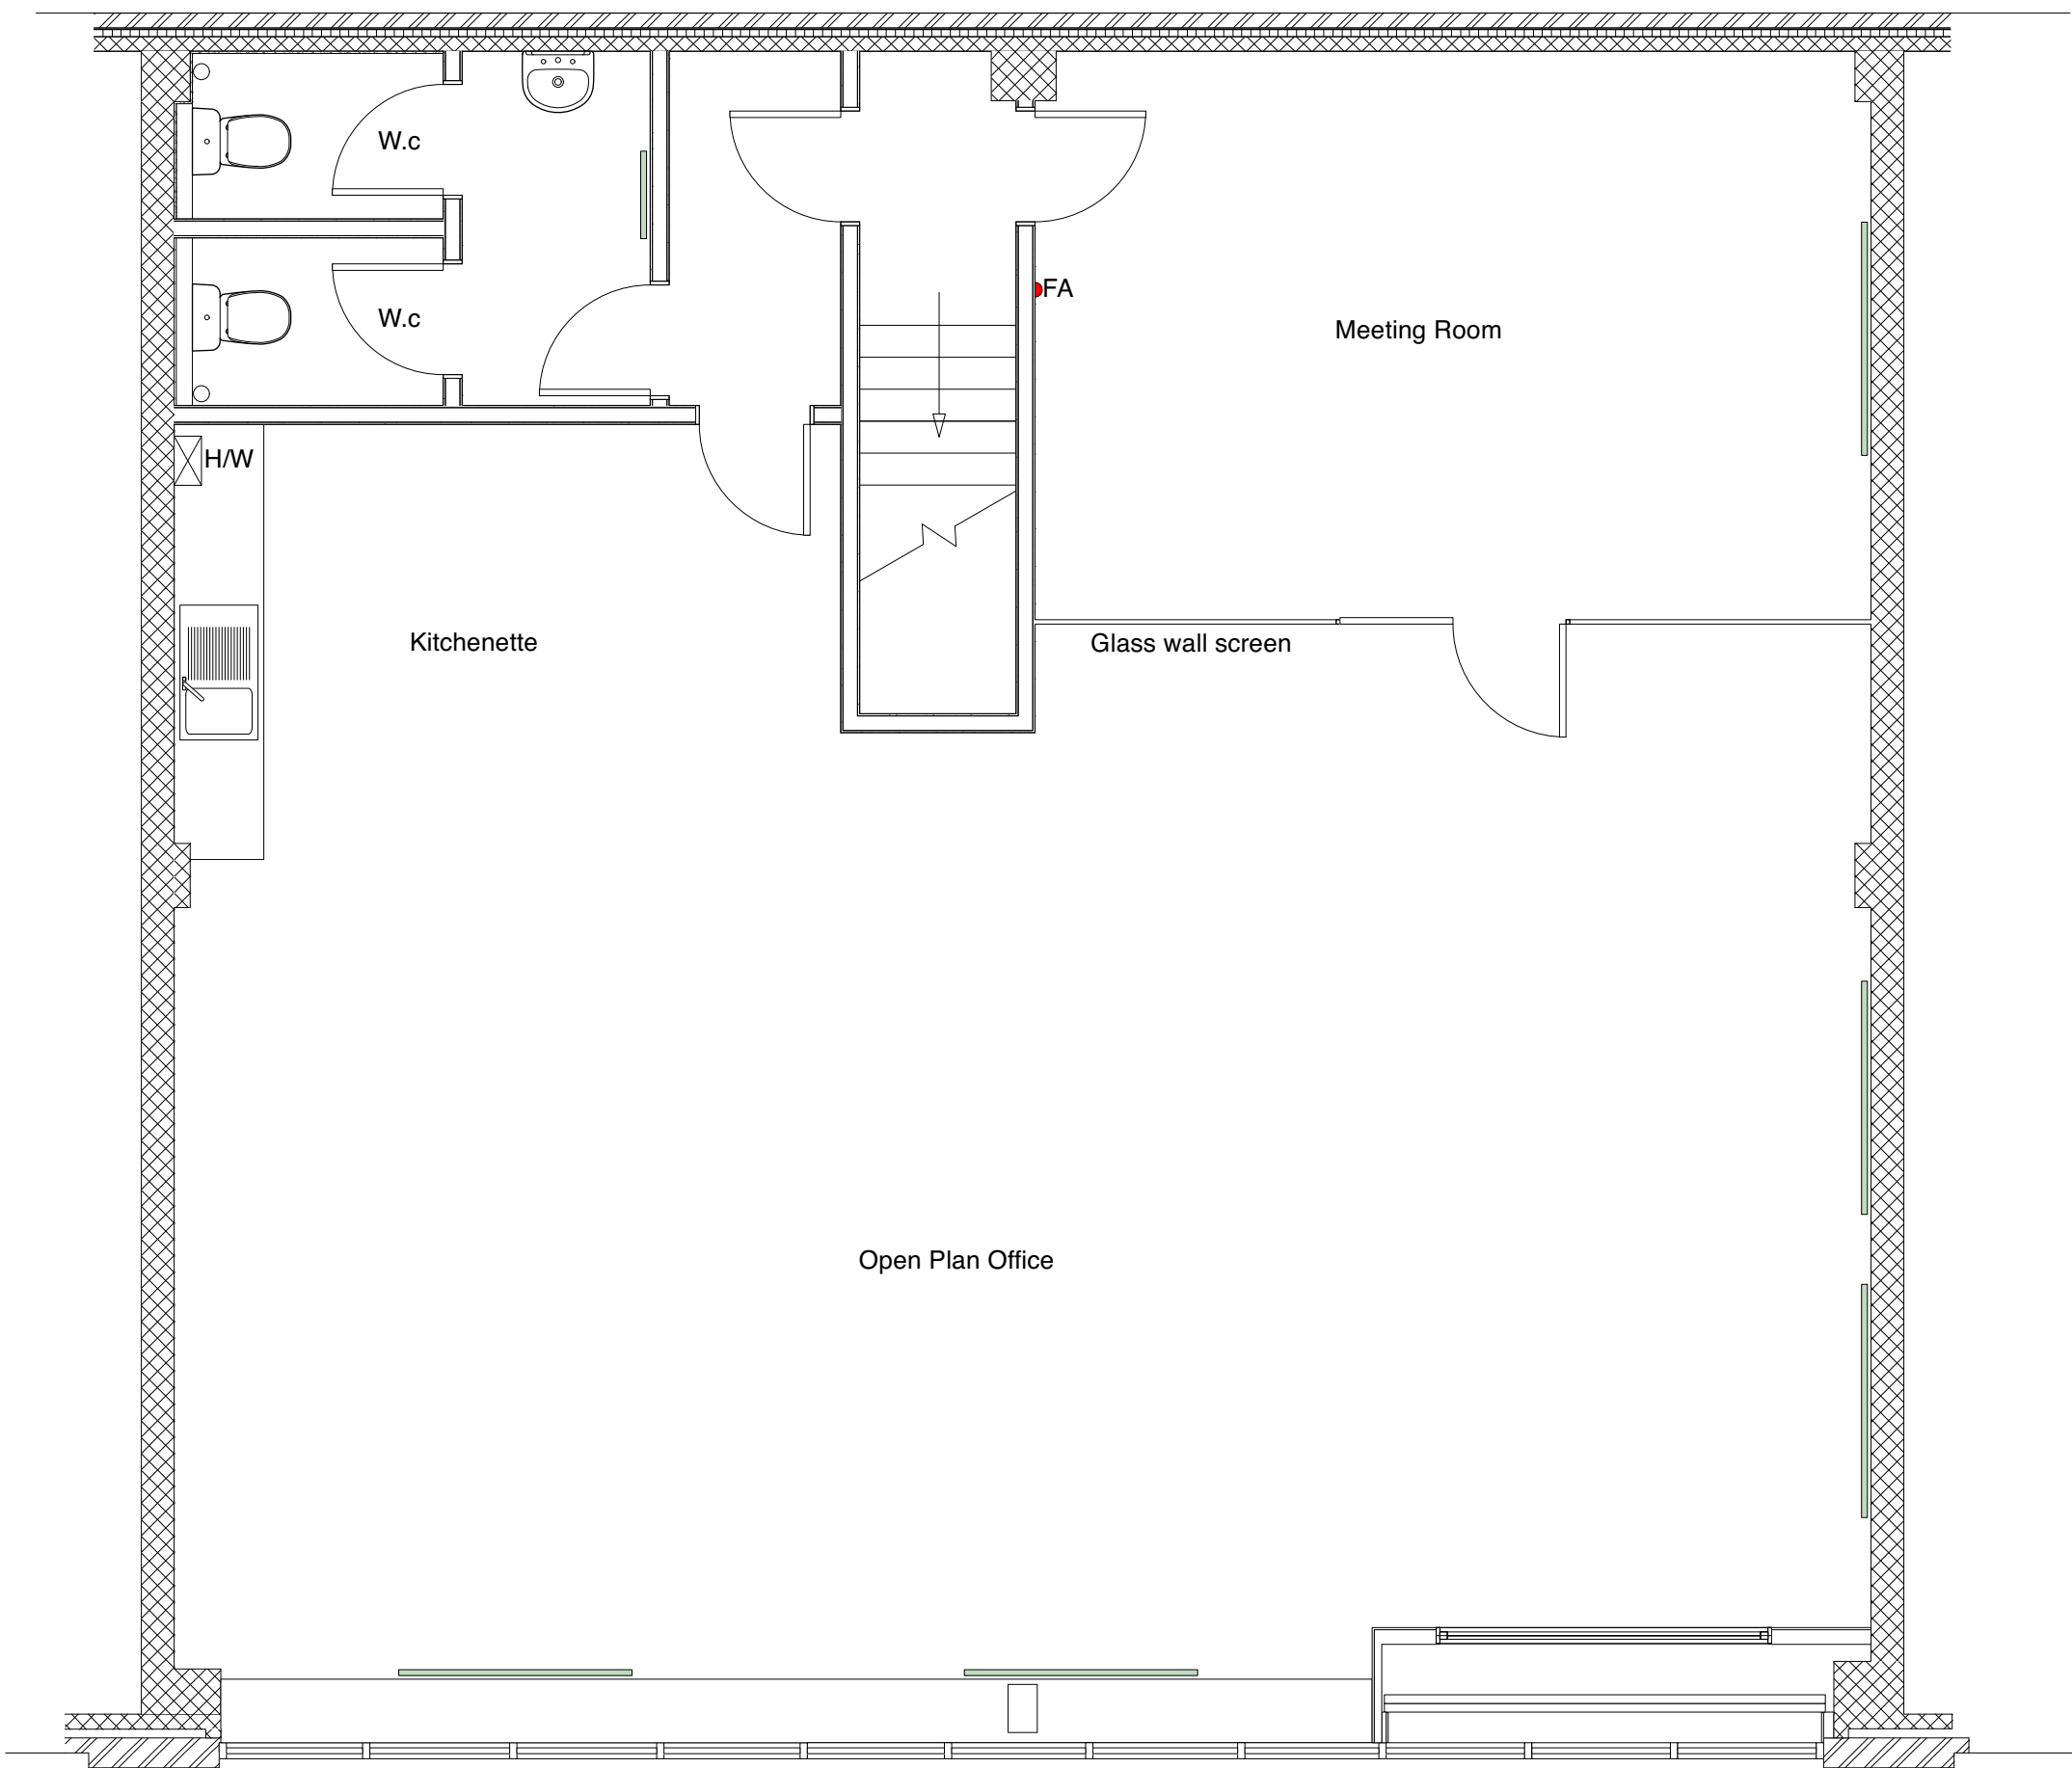

3 First Floor
Scale: 1:50

 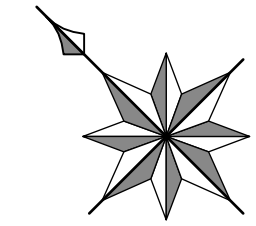

No	Date	Details
Revisions		
Project		
Unit 8		
Focus Way		
Walworth Ind Est		
Andover		
Hants		
Client		
Venture Security		
Date		
September 2021		
Title		
Proposed		
Scale		
1:50 @ ISO A1		
Drwg No.		
PTAD/240921/02		
 Peter Tesar Architectural Design 01264 356544 peter@peteresar.co.uk www.peteresar.co.uk		