

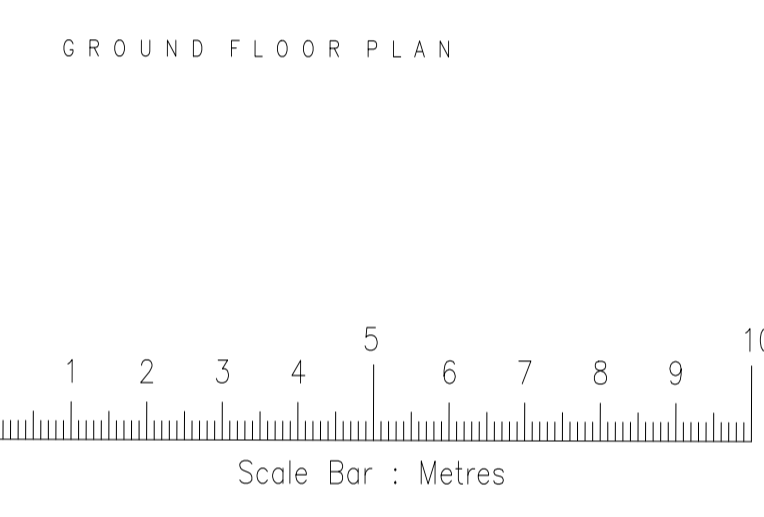


Fit Point A

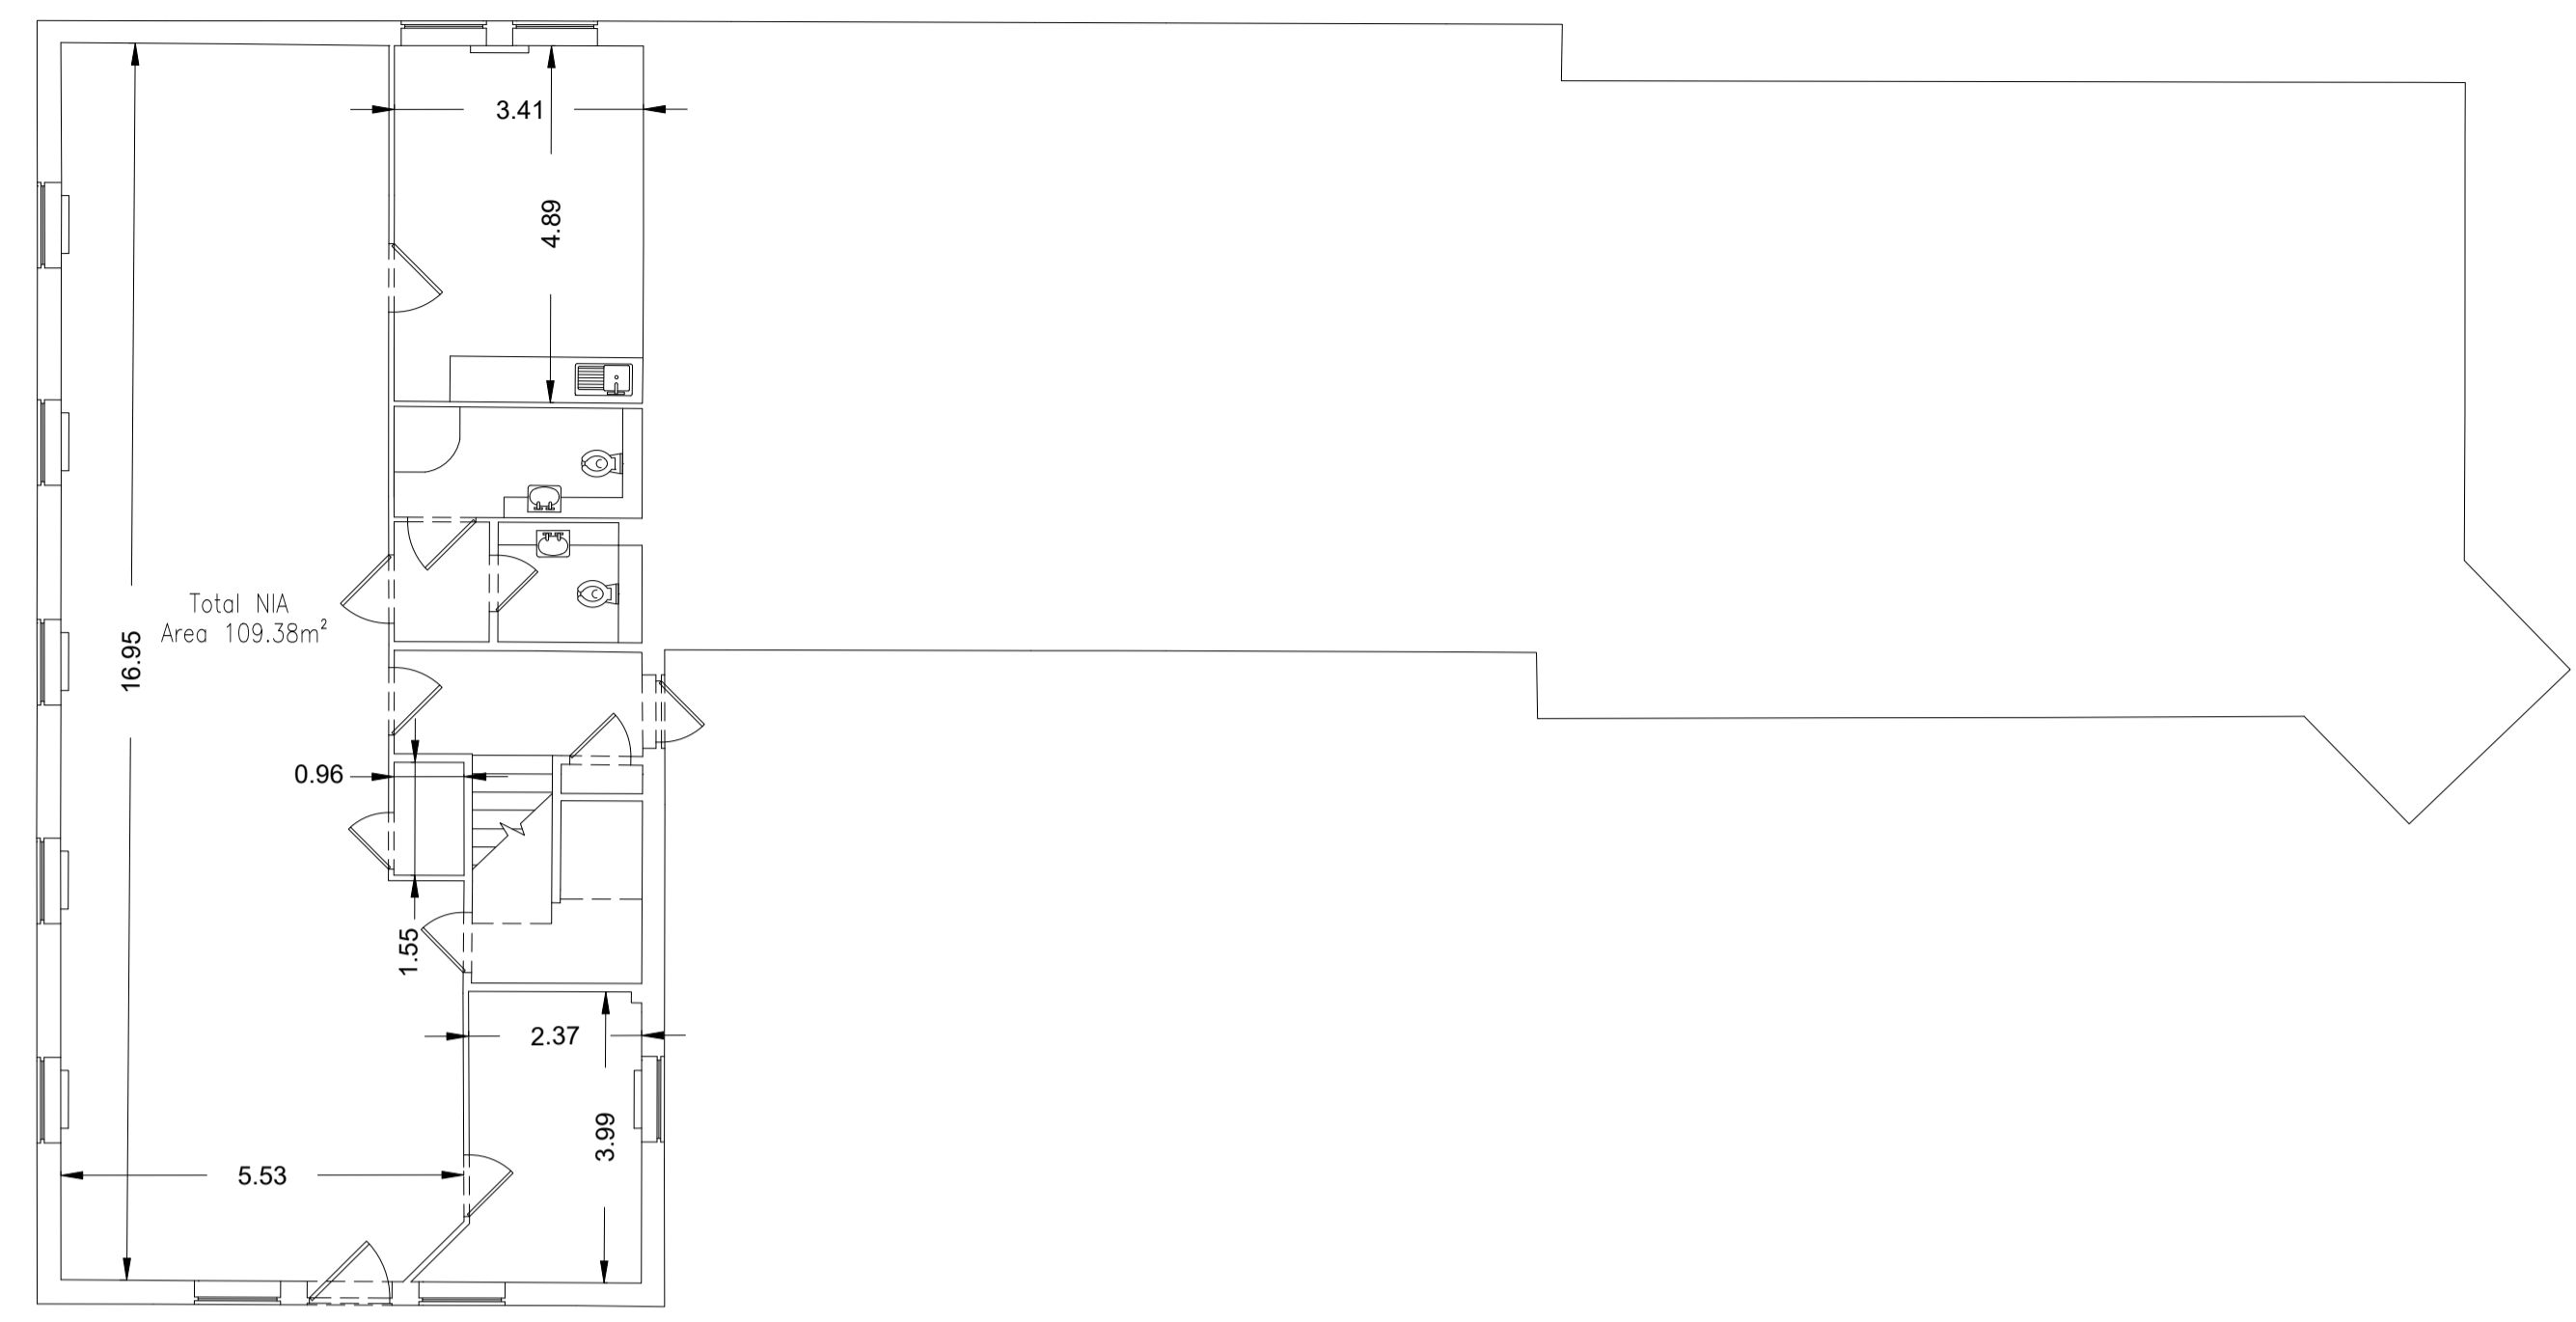

Fit Point B

Fit Point A

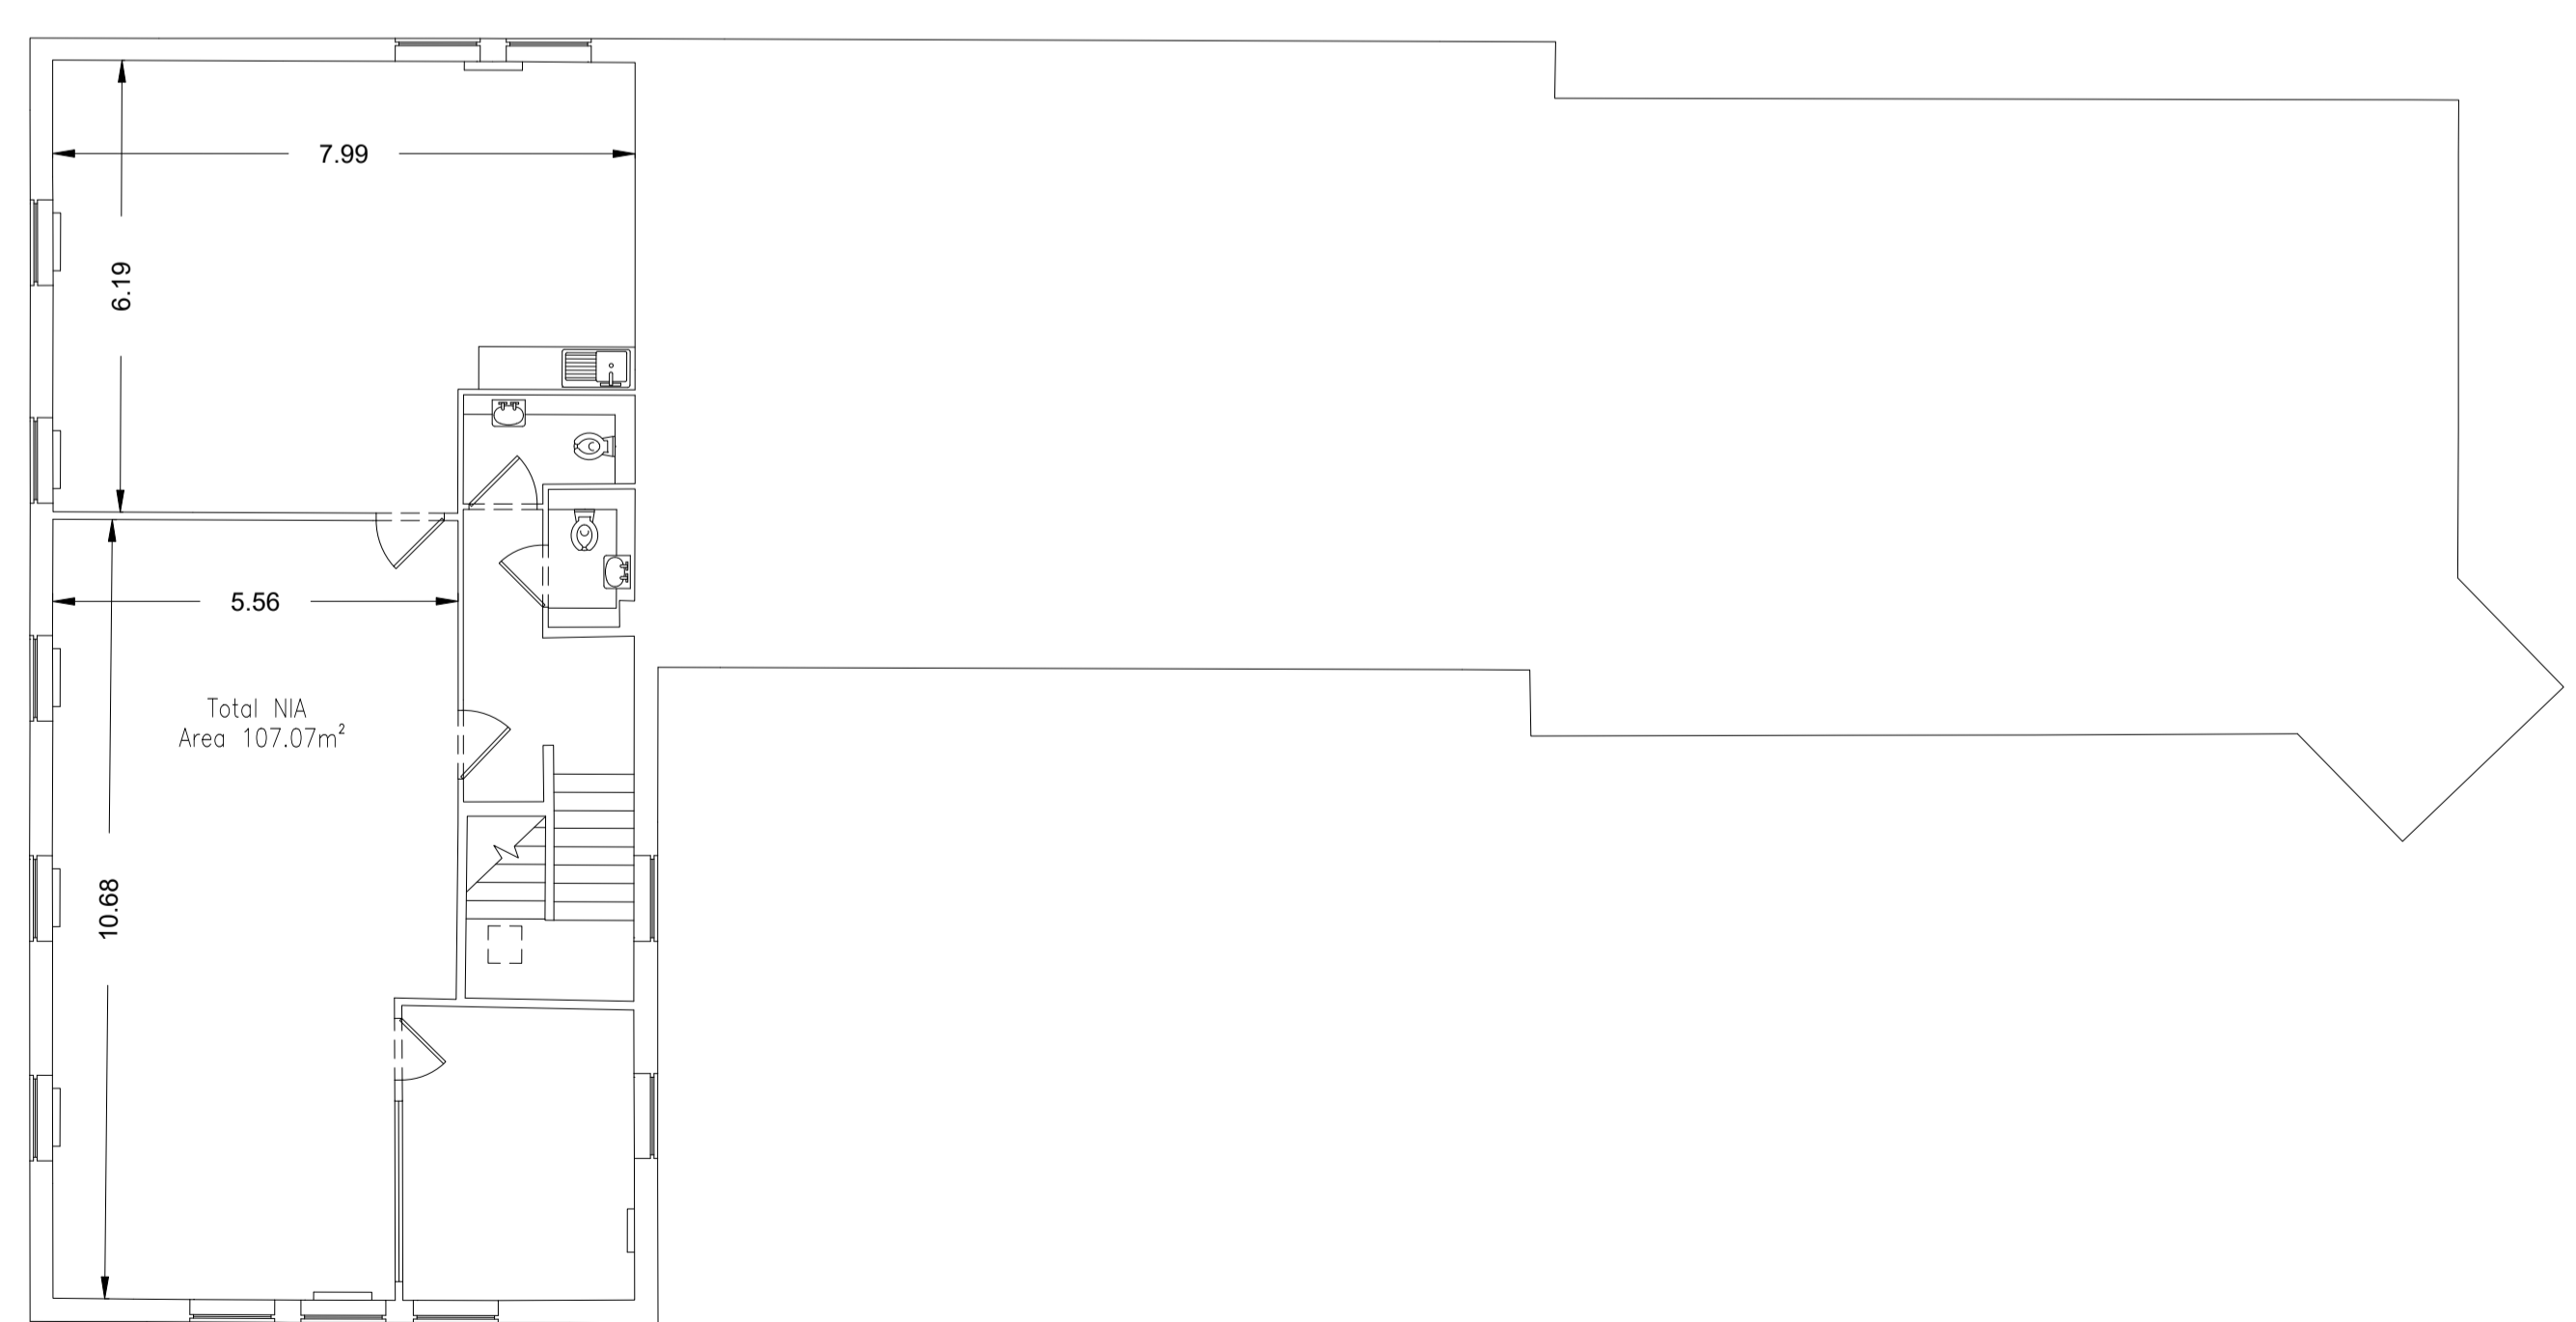

FIRST FLOOR PLAN


Fit Point B

Legend:

Abbreviated Features:	Symbols:	Legend:	
AB Air Brick	LI Light	Radiator	⊞
B Balcony	O/F Overflow Pipe	Light	⊙
C/R Close Boarded	P Post	Emergency Light	⊕
C-H Chain Link	P/C Pitched Ceiling	Strip Light	⊞
CL Ceiling Level	PE Pipe	Wall Mounted Light	⊞
CPD Cupboard	P/R Pitched Roof	Mains Point	⊞
CR Crown Point Level	P/W Post & Wire	Blank Plate	⊞
DH Door Height	RD Roller Door	Light Switch	⊞
Dr Drain	RWP Recessed Pipe	Pendant Switch	⊞
FE Fire Exit	SD Sliding Doors	Isolator Switch	⊞
F-C Floor to Cill	SS Suspended Ceiling Level	Isolator Switch	⊞
FL Floor Level	SP Spring Point Level	Alarm Bell	⊞
FW Four Water	SP Soil & Vent Pipe	Alarm Bell	⊞
MH Manhole	SW Surface Water	Fire Alarm Push	⊞
C Gully	US Underside	Snow Detector	⊞
I Inspection Chamber	UTL Underside To Lift	Alarm Panel	⊞
I Invert Level	VP Vent Pipe	Thermostat	⊞
I/R Iron Ratings	VI Vent	Modes	⊞
		Fire Box	⊞
		Electric Box	⊞
		Water	⊞
		Water Stop Tap	⊞
		Overhead Features	⊞

Plan Coordinate Control:-
N/A

Level Datum:-
All Levels relate to OSGB36 using GPS

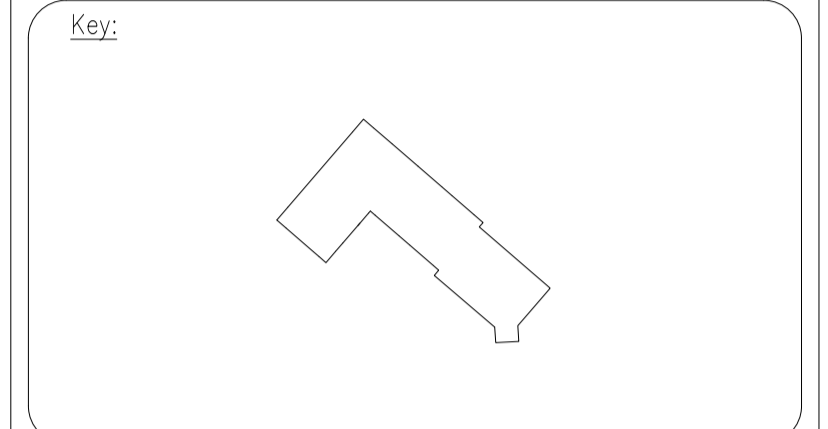

Notes:

REV A	Areas & Dimensions added.	07/03/25	SJH
REV NO	REV NOTE	DATE	SIGNED



GLOBAL SURVEYS

3 Brookfield, Duncan Close,
Moulton Park, Northampton, NN3 6WL
Tel: 01604 491543
Email: info@globalsurveys.co.uk

Site: Warren Park
Wolverton
Milton Keynes MK12 5NF

Client: Milton Keynes Parks Trust

Survey Title: Measured Building Survey
9 Warren Yard Floor Plans

Date	February 2025	Scale	1/100 @ A1
Dwg No.	24708_9_WY	Surveyor	KMG
Sheet	1 of 1	Checked	SJH