
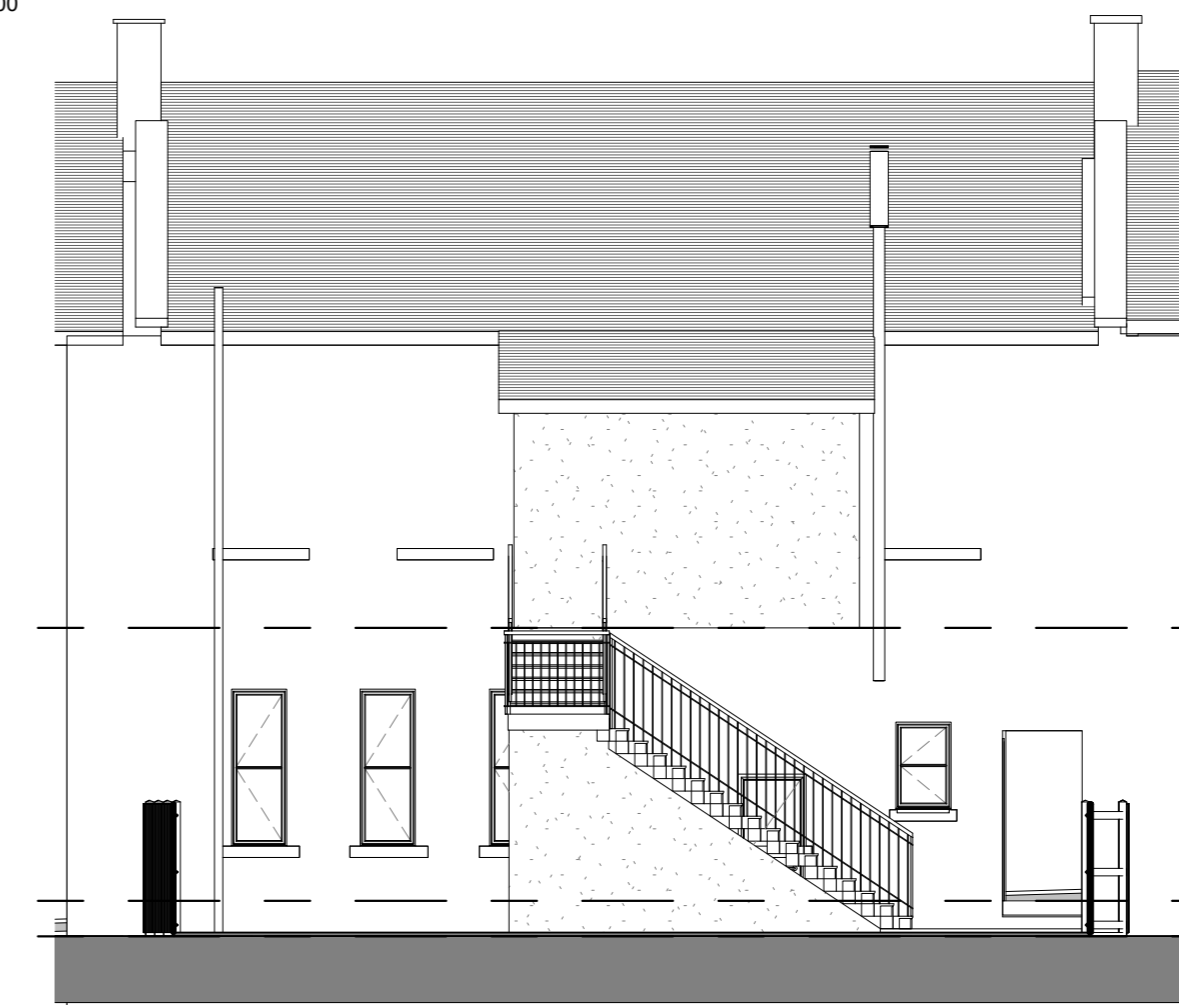



Revision
Date: 06/29/16

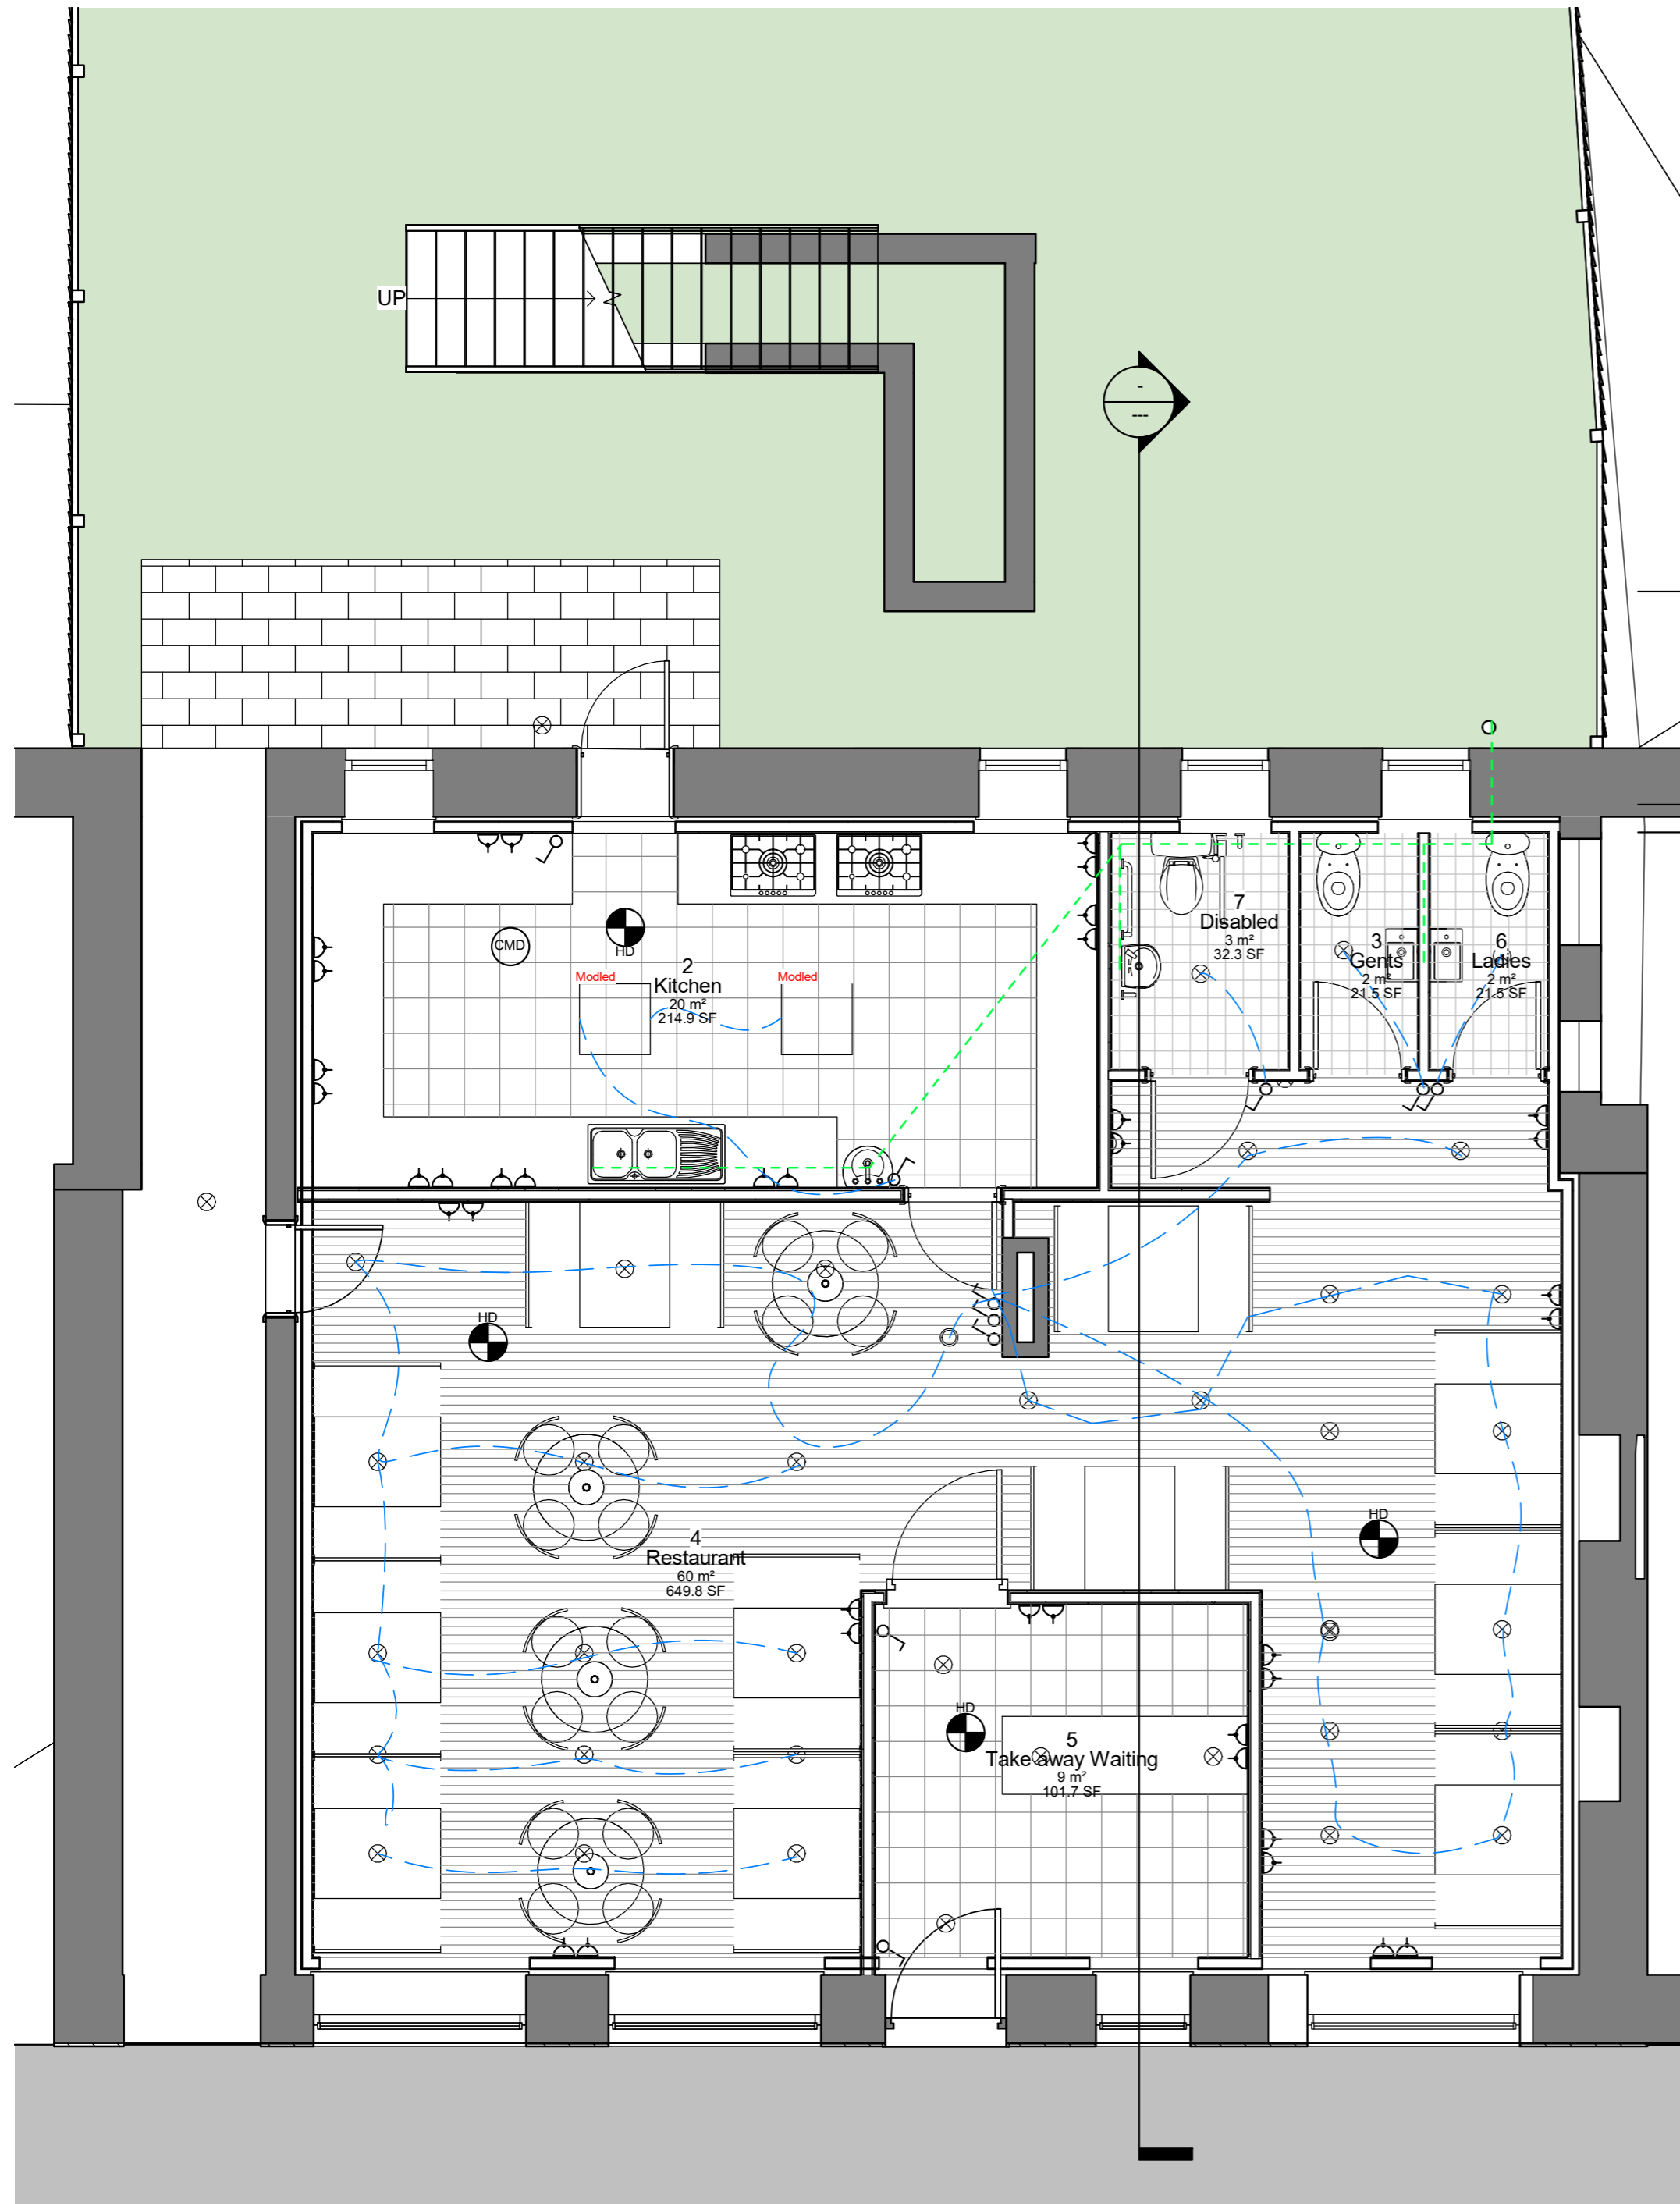

TYPICAL ELECTRICAL SYMBOL

Pendant light	⊗	Distribution Board	▭
Downlighter	⊗ DL	Cooker Control Unit	▭
Wall light	⊙ WL	Network	N
External Wall light	⊙ WL	Telephone Socket	T / ▽
Fluorescent Light	—	Television	T.V
5amp Lighting	○ 5amp	Ceiling Mounted Extract Fan	⊗ Vent
One Way Light Switch	—	Wall Mounted Extract Fan	⊗ Vent
Two/ Three Way Light Switch	—	Shaver Socket	▭ / ⊙
Wall Unit Downlighter	—	Smoke Detector	⊗ SD
13 Amp Socket Twin	—	Heat Detector	⊗ HD
123 amp Socket below Wk/Top	—	Multi-Sensor detector/ Alarm	⊗ MD
Spur Outlet	—	Carbon Monoxide Detector	○ CMO
		Immersion Switch	—

 Electrical Legend 01
1:80



VISUAL SCALE 1:50

ANGUS DESIGN ASSOCIATES LTD

Proposed Floor Plans

Drawing No: AL003
Scale (A2): As indicated

Planning

All sizes dimensions and heights are to be checked on site and confirmed before work commences. Sites sizes take preference to scaled sizes