

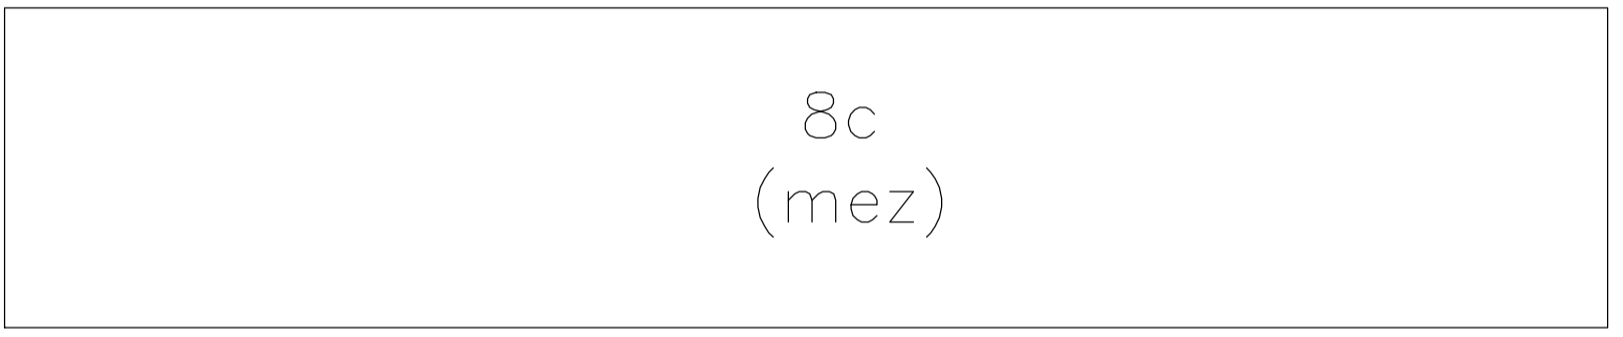


0m 2m 4m 6m 8m 10m 12m 14m 16m 18m 20m

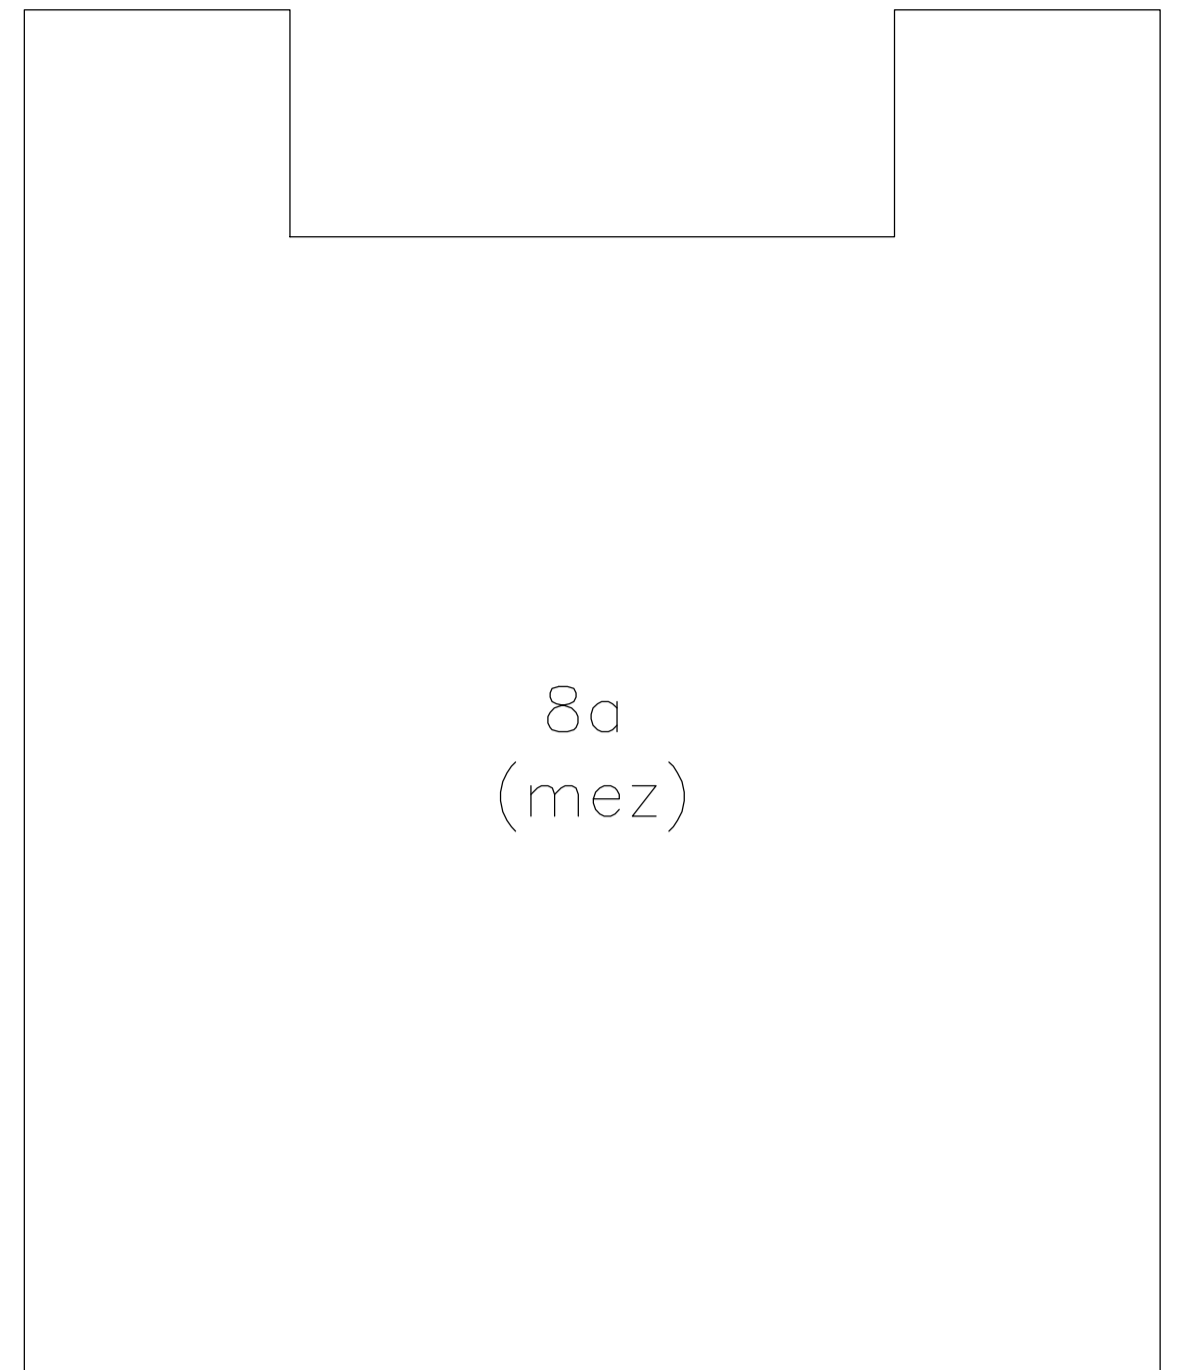

KAD NIGHT ARCHITECTURAL DESIGN		R.A.S. Ltd Grand Point Quay 4th Floor 100 Victoria Road 10000 T: 01483 861114 F: 01483 861115 www.kad.co.uk	
Client: PETCHEY HOLDINGS			
Project: BLOCK C SKILL CENTRE LEMBERLINE SPUR PORTSMOUTH PO3 5LF			
Drawing: FLOOR PLANS			
Scale: 1:100@A1		Date: NOV 2017	
Project No.	Sheet No.	Sheet Title	Rev.
KAD	03	A	EX

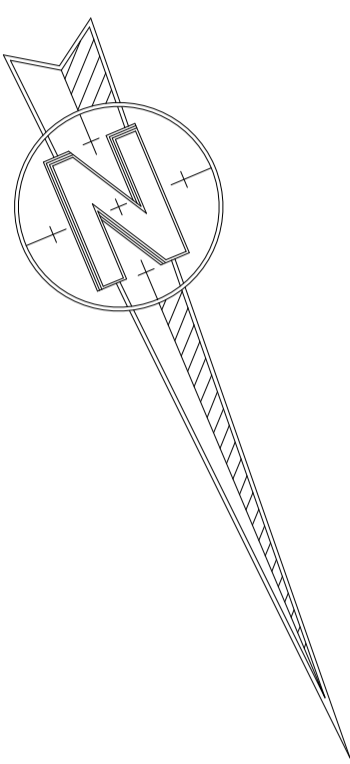

0m 10m 20m 30m 40m 50m  
K.A.D. Licensed O.S. No. 100547482

