


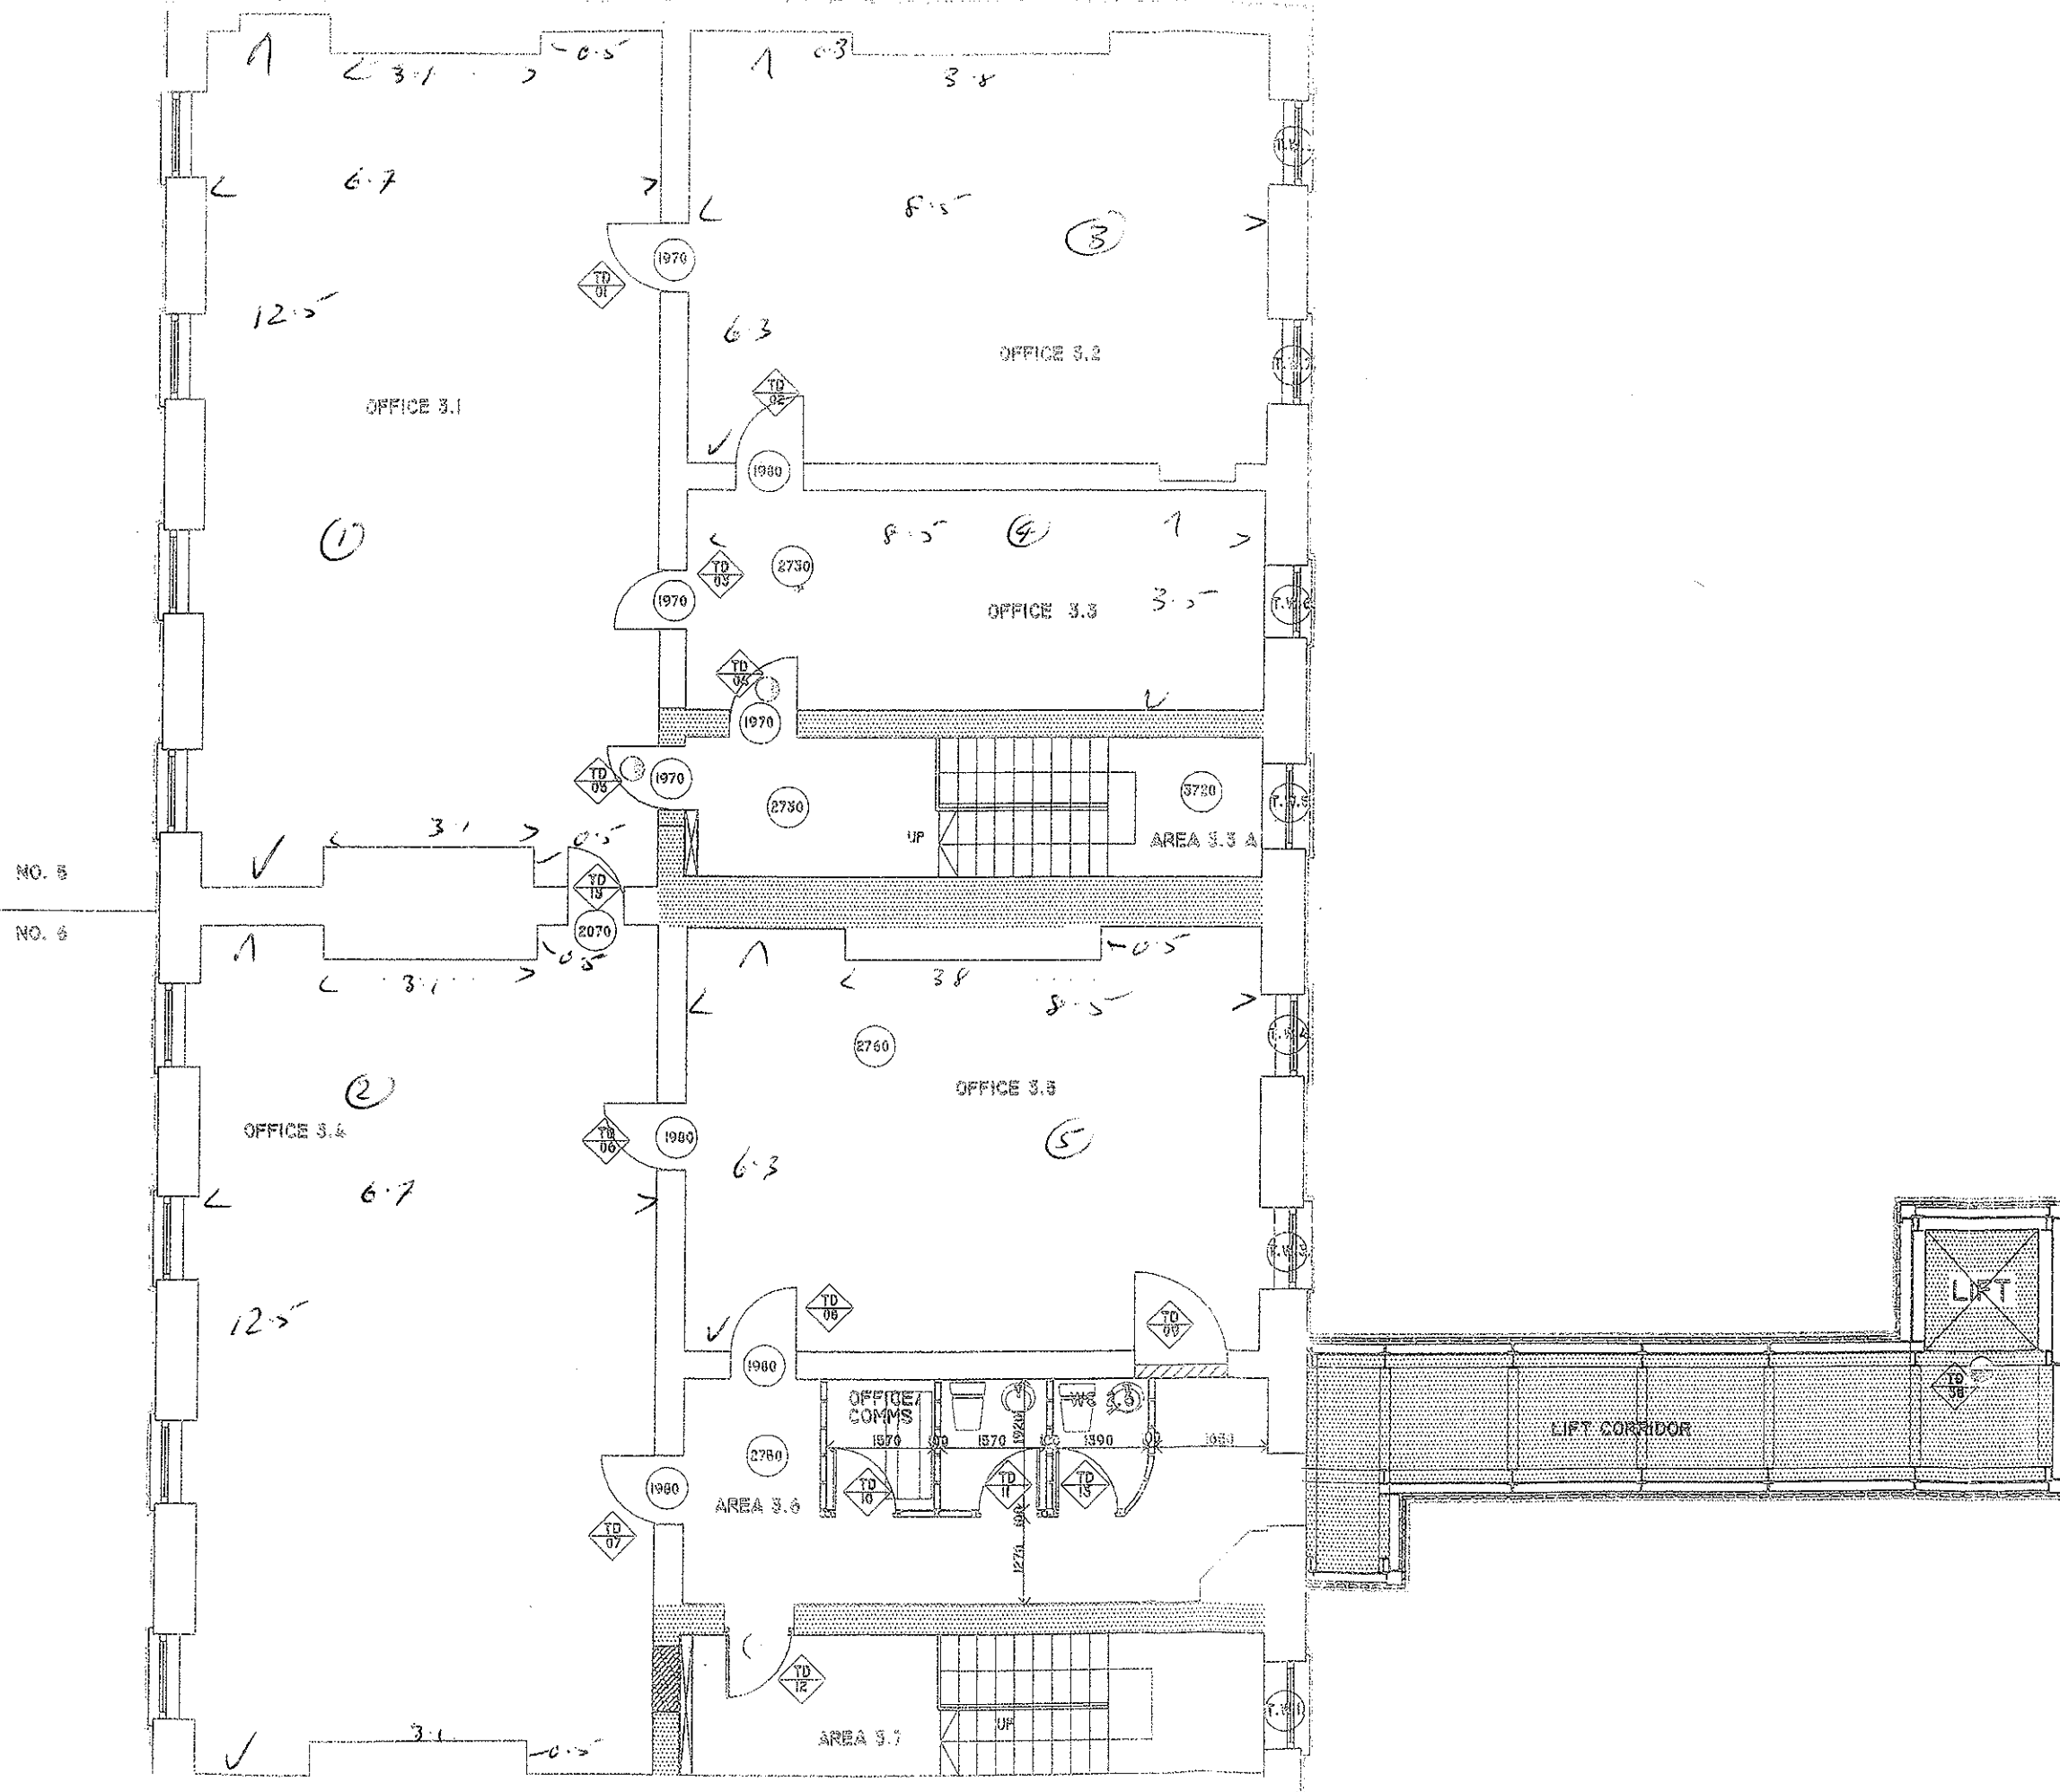

Date: No: Revision:

Delahunty & Harley

ARCHITECTS DESIGNERS

122 MERRION ROAD BALLSBRIDGE DUBLIN 4
Telephone 01-2693325 - 2637972 Fax 01-263 7972

James A. Delahunty Dip. Arch. So., M.R.I.A.I.
John Harley B.Des.

Job LIFT STRUCTURE

At 5-6 ELY PLACE, DUBLIN 2

Title THIRD FLOOR PLAN FIRE

Client MR. PIERCE MOLONY

Drawn: NW Date: 30.11.00 Scale: 1:100

Job No: 9604 Day No: 07 LEASE