


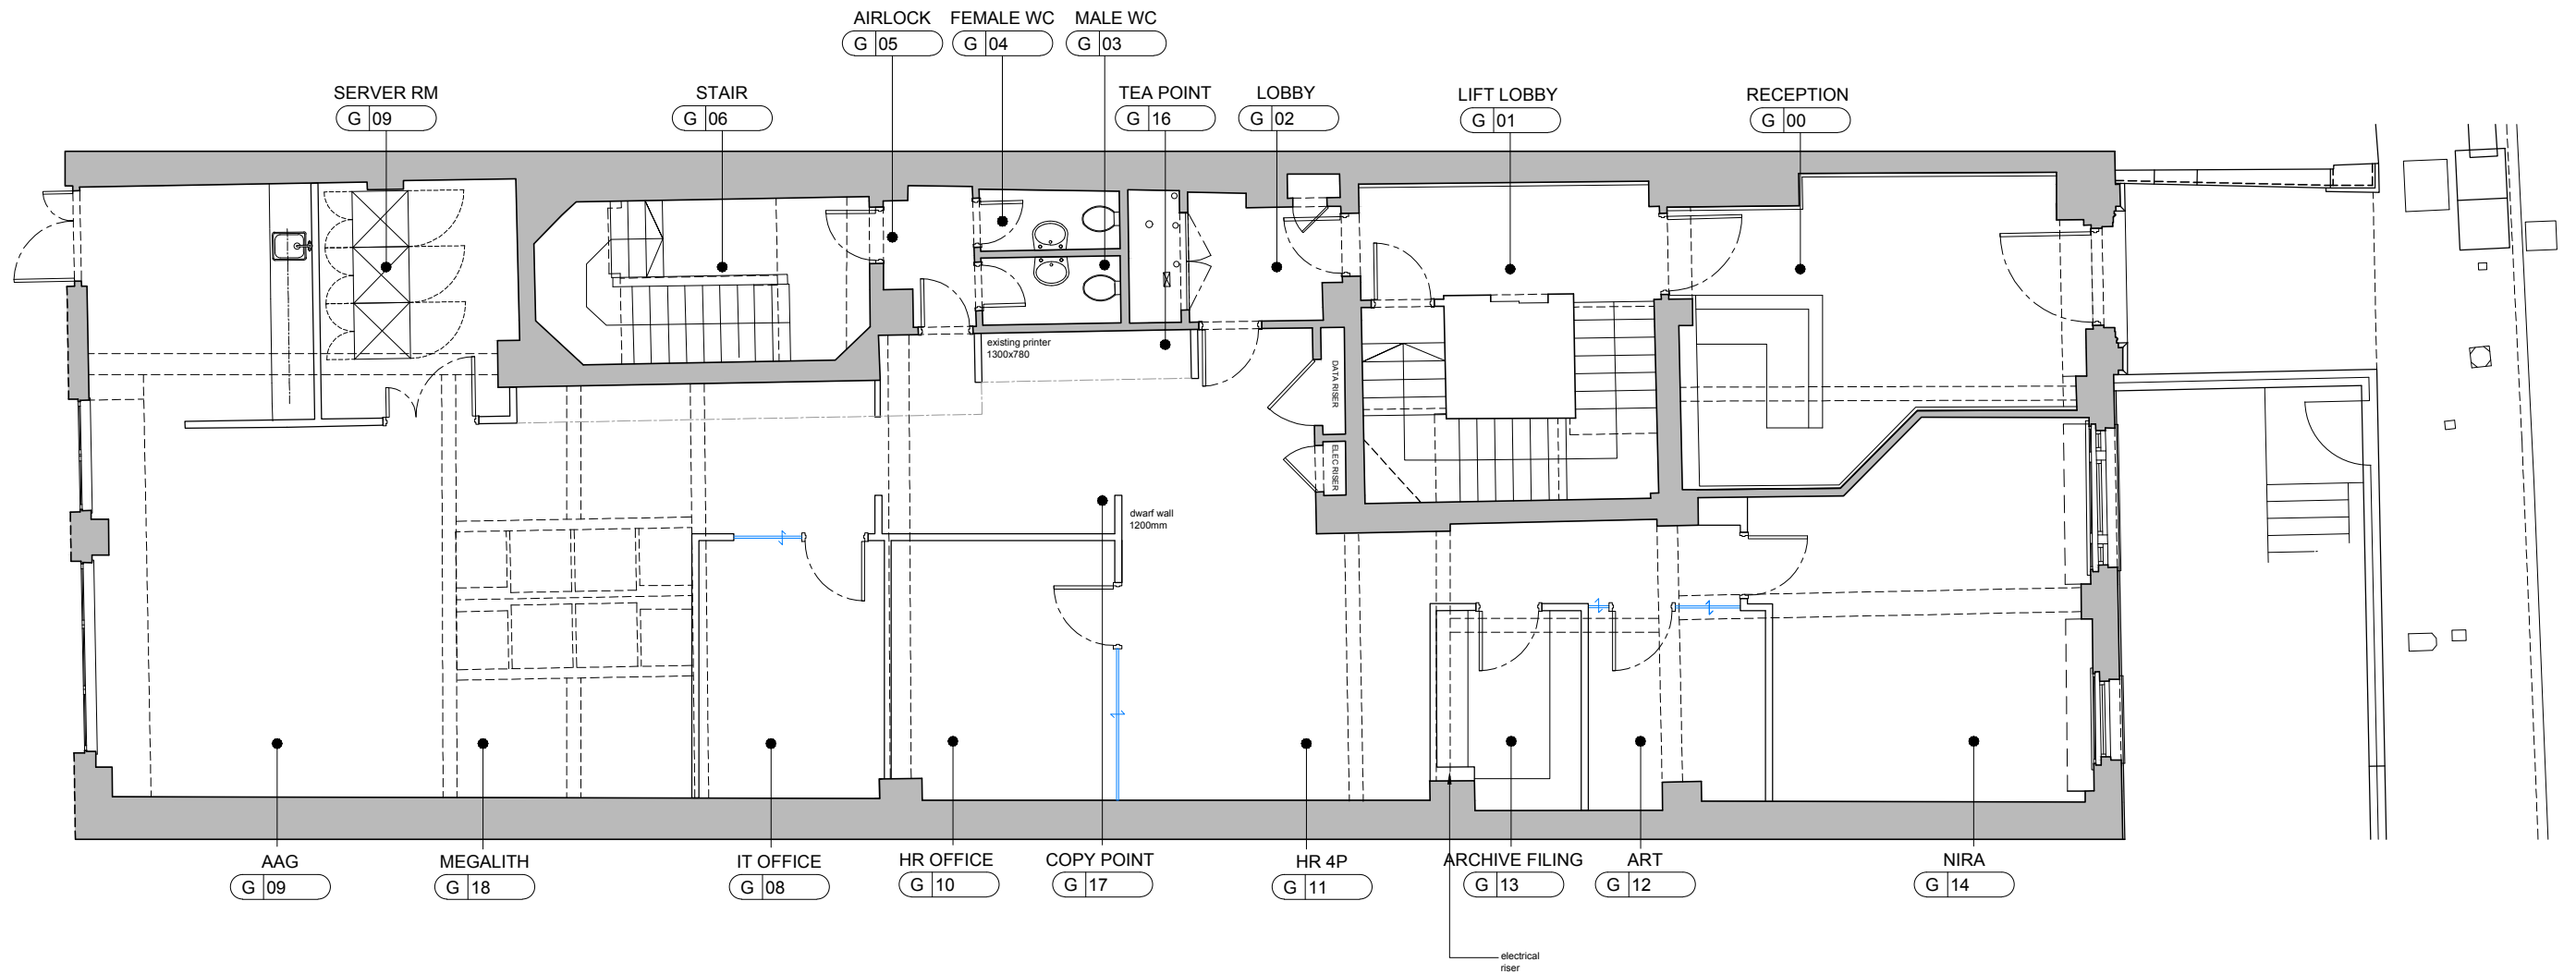

GROUND FLOOR - PARTITION AND DOOR PLAN

Rev	Date	Description
C9	07/02/2017	Updates as indicated
C8	20/12/2016	Electrical riser and sound insulation revised
C7	14/12/2016	Partition moved. Door refs updated.
C6	09/12/2016	IT office and server room swapped. Refer to GA plan.
C5	06/12/2016	Door numbers amended
C4	29/11/2016	Refer to GA plan
C3	15/11/2016	Dimensioned
C2	06/10/2016	Replanning of floor
C1	21/09/2016	CONTRACT ISSUE

CONSTRUCTION

© Think Inside Limited.
All designs are the sole property of Think Inside Ltd. and may not be used, transferred, or disclosed to a third party without their express permission. Electronic copies of this drawing are supplied for convenience only. No dimensions or other information should be inferred from the electronic copy unless specifically shown on the hard copy drawings or specifications. Do not scale from this drawing. Figured dimensions only are to be used 'For Construction' and any scaling of the drawing will be at the Contractor's risk. Contractor to verify all dimensions, levels, and components on-site. Any discrepancies shall be addressed in writing to this office for clarification prior to the commencement of the work, otherwise the Contractor shall bear full responsibility for any associated cost. Any claims for variations or extras shall be submitted to this office for assessment prior to approval of any such variation or extra. This drawing is to be read on conjunction with all other contract documentation.

THINK INSIDE
CONSTRUCTIVE DESIGN

e: info@think-inside.com

Project:
**C&C ALPHA GROUP
REFURBISH**
23 BUCKINGHAM GATE, LONDON

Drawing Title:
**GROUND FLOOR
PARTITION AND DOOR PLAN**

Job No.: **TI1142** Dwg. No.: **AP-30-GR** Rev.: **C9**

Scale:
1:100 @ A3

Drawn By:
PH

Checked By:
DF

Cad File Name:
P:\P\ACTIV PROJECTS\1142 C&C ALPHA - 23BUCKINGHAM GATE\PRODUCTION\1142-CONSTRUCTIVE-PLAN-AP-30-PARTITION & DOOR-000001142_AP-30-GR_PARTITION AND DOOR.dwg

Print Date/Time:
14/02/2017 14:03:39