


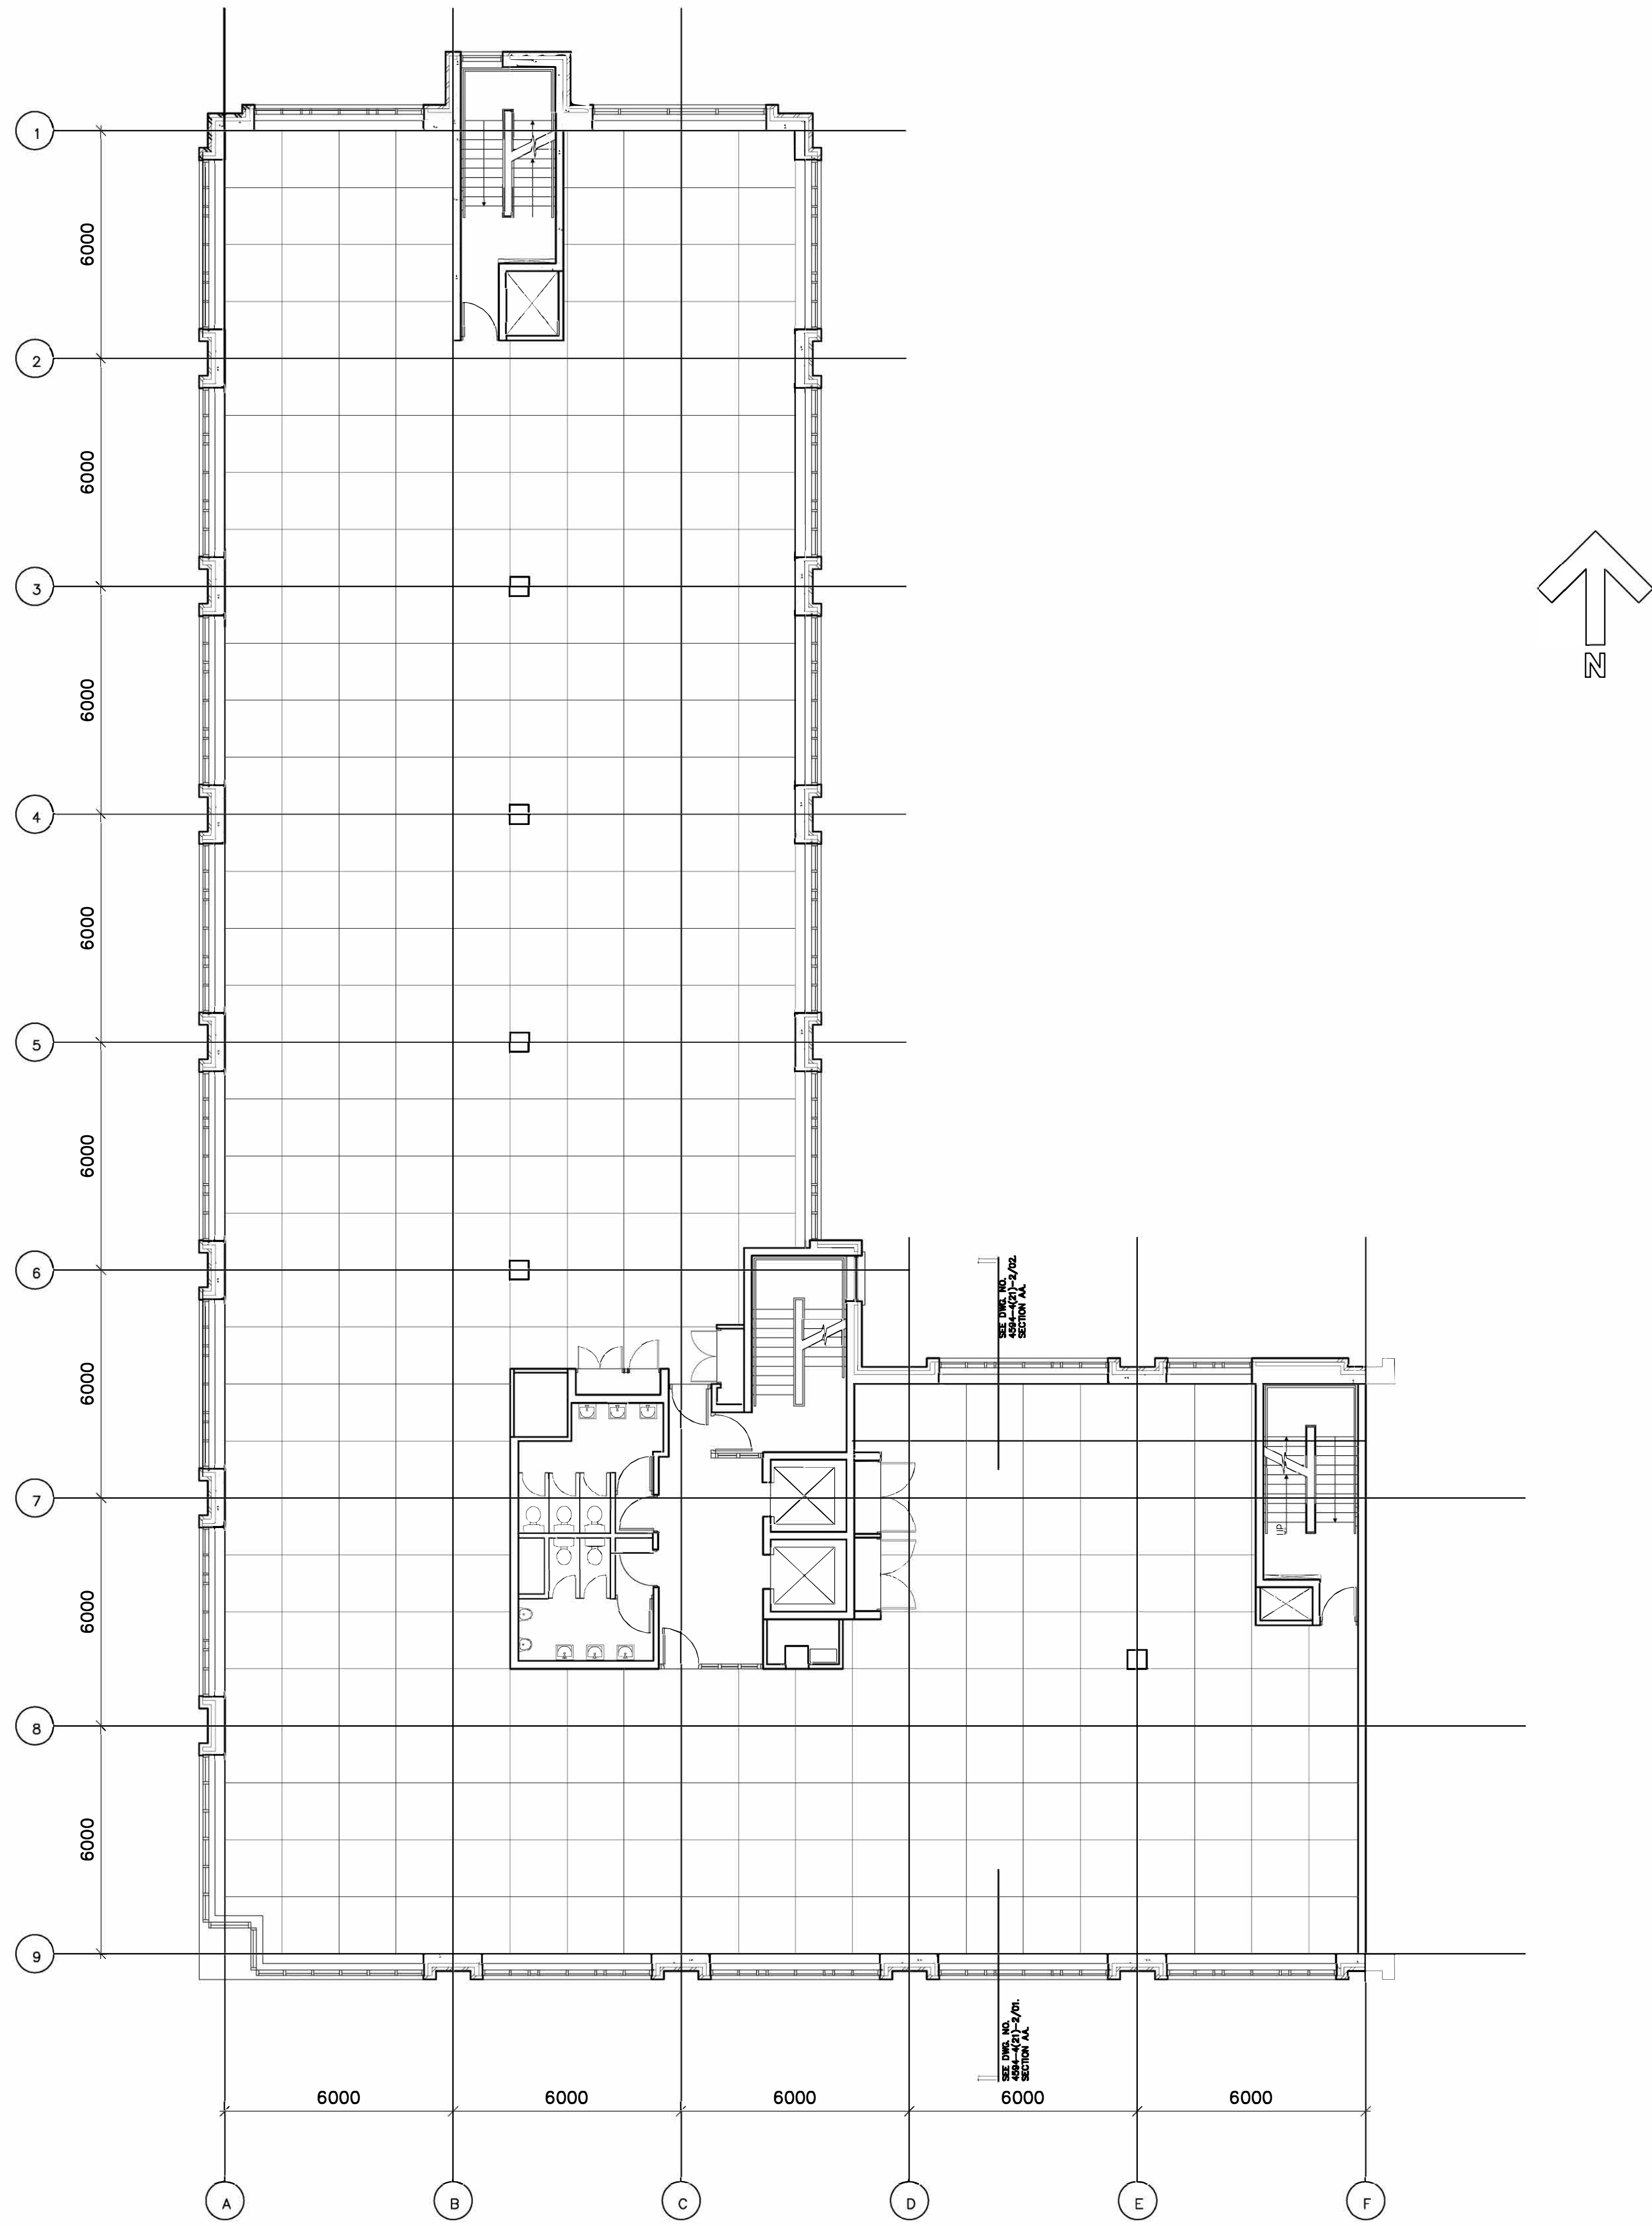

- Notes
1. Copyright Reserved
 2. Work to figured dimensions only. Do not scale print.
 3. The contractor is responsible for checking all levels and dimensions on site and shall refer all discrepancies to the architect.
 4. Where appropriate, for details of r.c. structure, or mechanical and electrical details, see engineers drawings.
 5. Proprietary items shall be fixed in strict accordance with manufacturers instructions.
 6. Sizes of proprietary items shall be checked with manufacturer.
 7. The contractor shall be responsible for the co-ordination of structure, finishes and services.

Revisions		
No	Date	Initial

Custom House Docks Development



NO.2 GEORGES DOCK

Burke-Kennedy Doyle+Partners Architects
6 & 7 Harcourt Terrace Dublin 2 Ireland Telephone +353.1.661 0399 Fax 676 7385
CHDD Architects Office, Memorial Road Dublin 1

Scale	1:200	Drawn	MD
Date	JAN 1995	Checked	
Drawing title	SECOND FLOOR PLAN		
Drawing no.	4594-4(23)20/01A	Revision	G