


 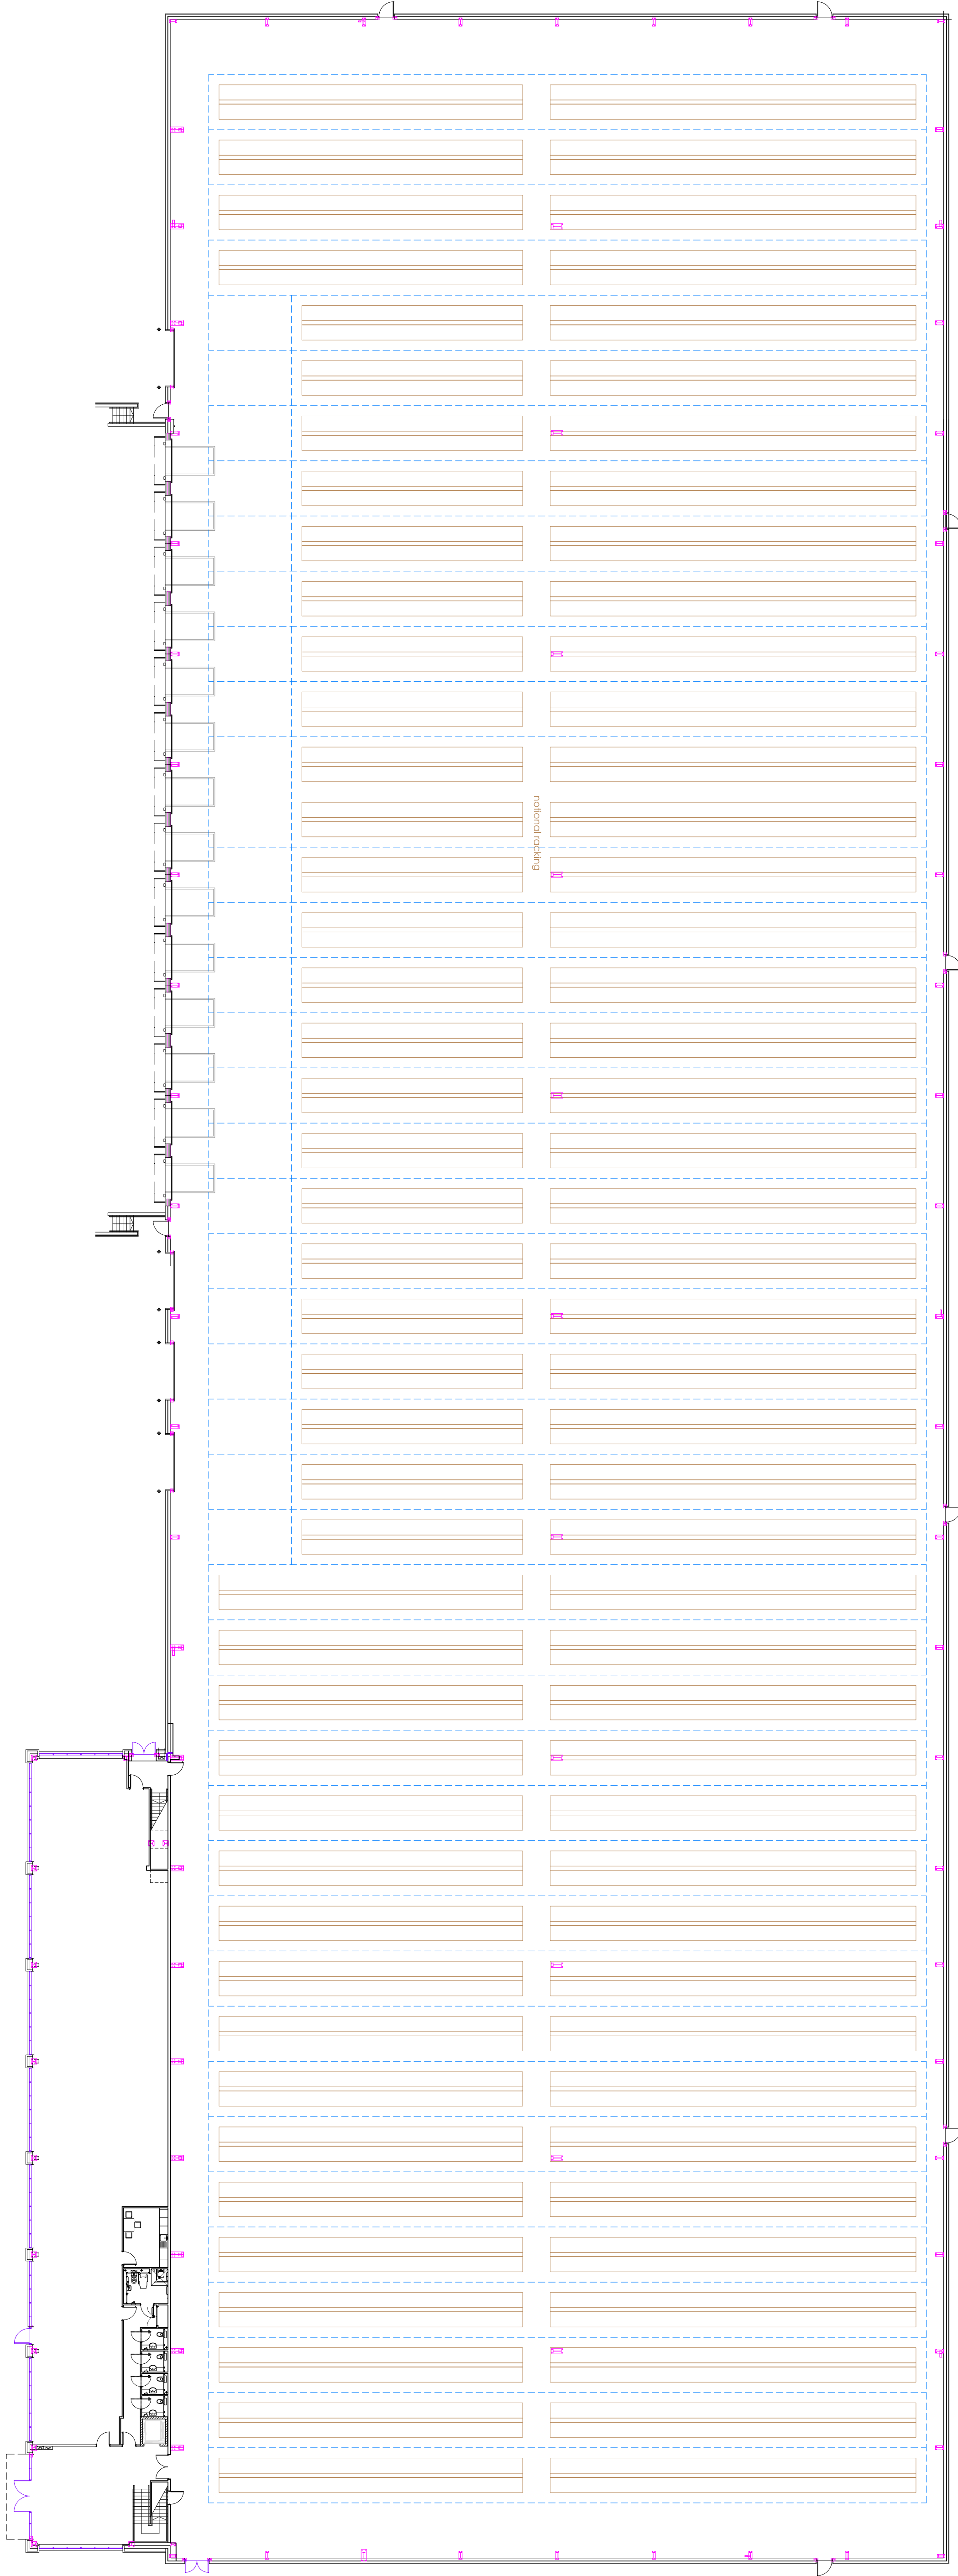
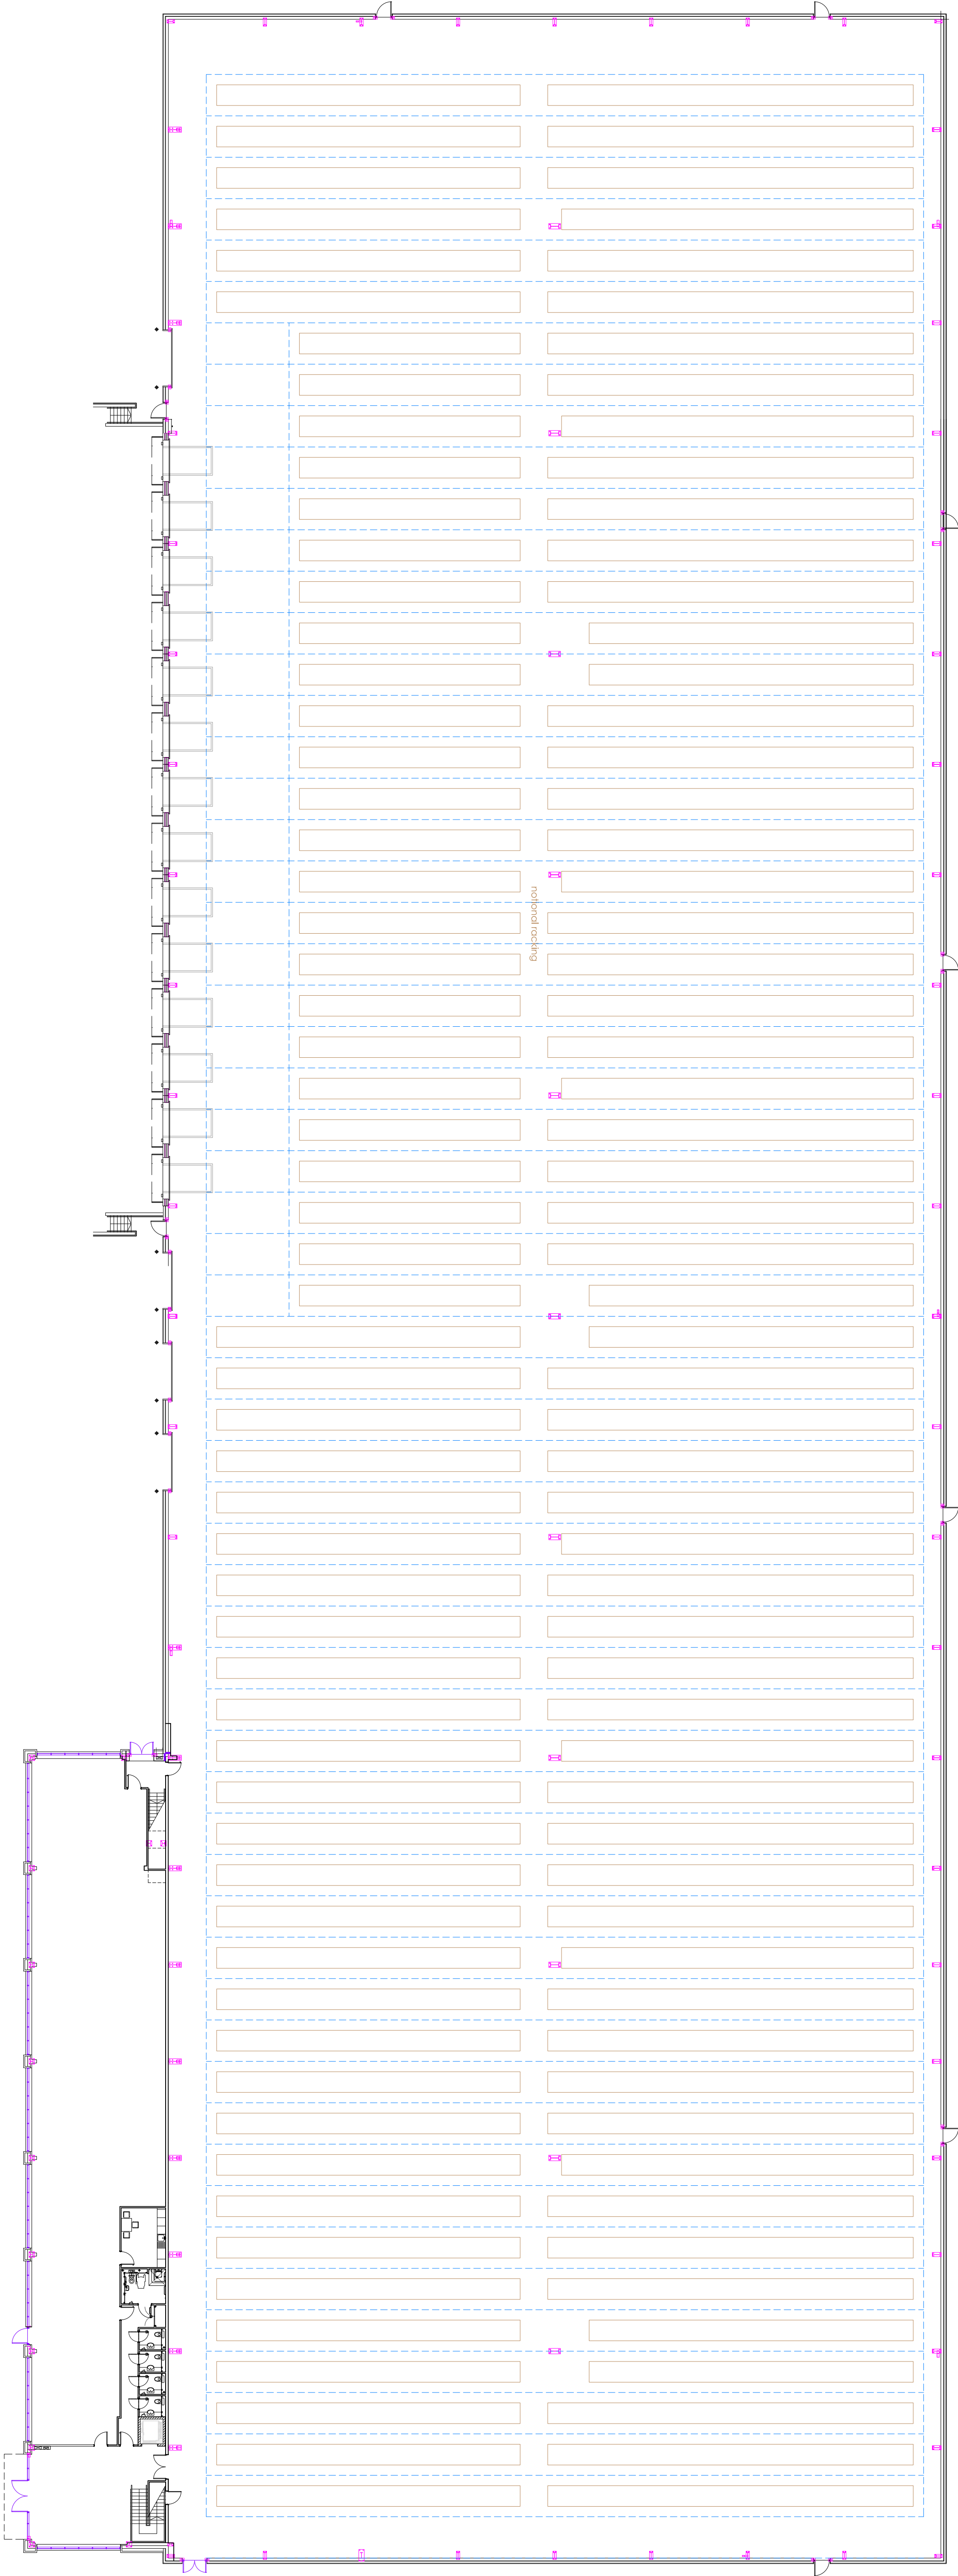


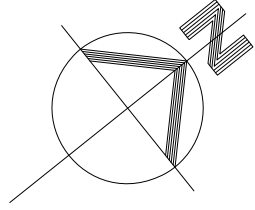

Wide racking



Narrow racking

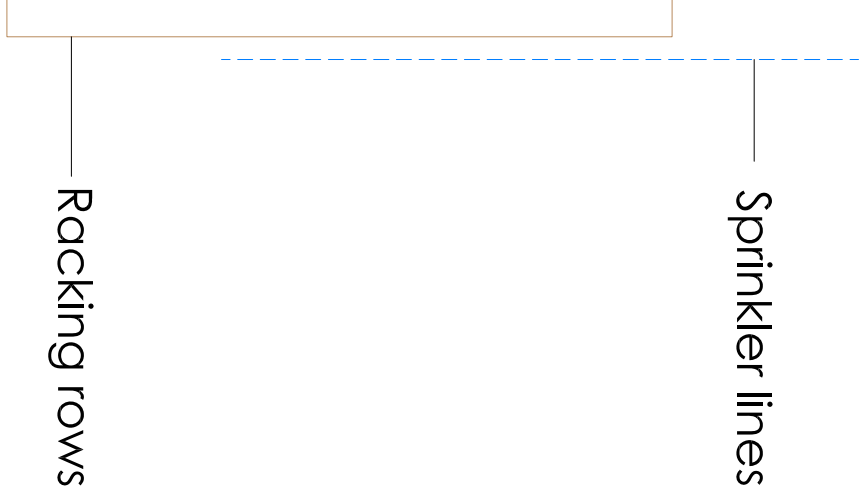

Notes:
No dimensions are to be scaled from this drawing. All dimensions are to be taken from the drawing. The drawing is the sole responsibility of IAN C KING Associates and no part may be reproduced without the written consent of the above

Logistics City
Michigan Avenue
Kier Property

Title
Ground floor plan
Narrow & wide racking &
sprinkler layouts

Draw No
KP-298-SK-S-01

Date	Scale	Rev
7-2025	1:250(A0)	-
Drawn	Checked	CDM
Header	Preparation	Construction

IAN C KING
ASSOCIATES - ARCHITECTS
4.5 Buxton Drive
8. Weymouth
Tel: 07554 633 444
Email: info@ianc-king.co.uk



IAN C KING ASSOCIATES is the trading name of Ian King Ltd