

Proposed Floor Plan
1:50


- Electrical Symbols**
- ▶ 13A Switch Socket Outlet
 - ▶ 13A Switched spur
 - ▨ Dado trunking
 - ⊗ LED light with Emergency
 - LED light
 - ⊗ Flat Panel LED with Emergency
 - Flat Panel LED
 - ⊕ Emergency Flood Light
 - ▷ LED Flood Light
 - Ⓜ(E) Electric Meter
 - ⤵ Light Switch
 - ⤵ Ceiling Mounted disabled toilet pull cord
 - ⊠ Reset panel for emergency beacon
 - ⊕ Emergency Beacon
 - ▭ Distribution Board
 - 240w 6ft thermostatic tube heater & heater guard and thermostat and timer controls
 - ⊗ Extractor Fan (ducted in void where possible)
 - HD 1.1Kw low energy hand dryer

Fire Symbols

- ▶ Fire Exit Sign (directional)
- ▶ Fire Exit Sign (final exit)
- ▶ Fire Exit Sign (keep clear)
- ▶ Fire Exit Sign (fire action notice)

Fire Detection system

- Ⓢ Apollo Alarm Sense detector base
- Ⓢ⊗ Apollo Alarm Sense sounder/ Base combination
- Ⓢ⊗⊕ Apollo Alarm Sense sounder/ beacon/optical Base
- Ⓢ⊗⊕ Apollo Alarm Sense sounder/ Heat/ Base combination
- Ⓢ⊗⊕ Sigma CPA Alarm sense 8 Zone conventional surface
- Ⓢ Manual Call Point
- Ⓢ⊗ Cranford RIU-02-B Remote indicator
- ▶ Wall mounted sounder beacon

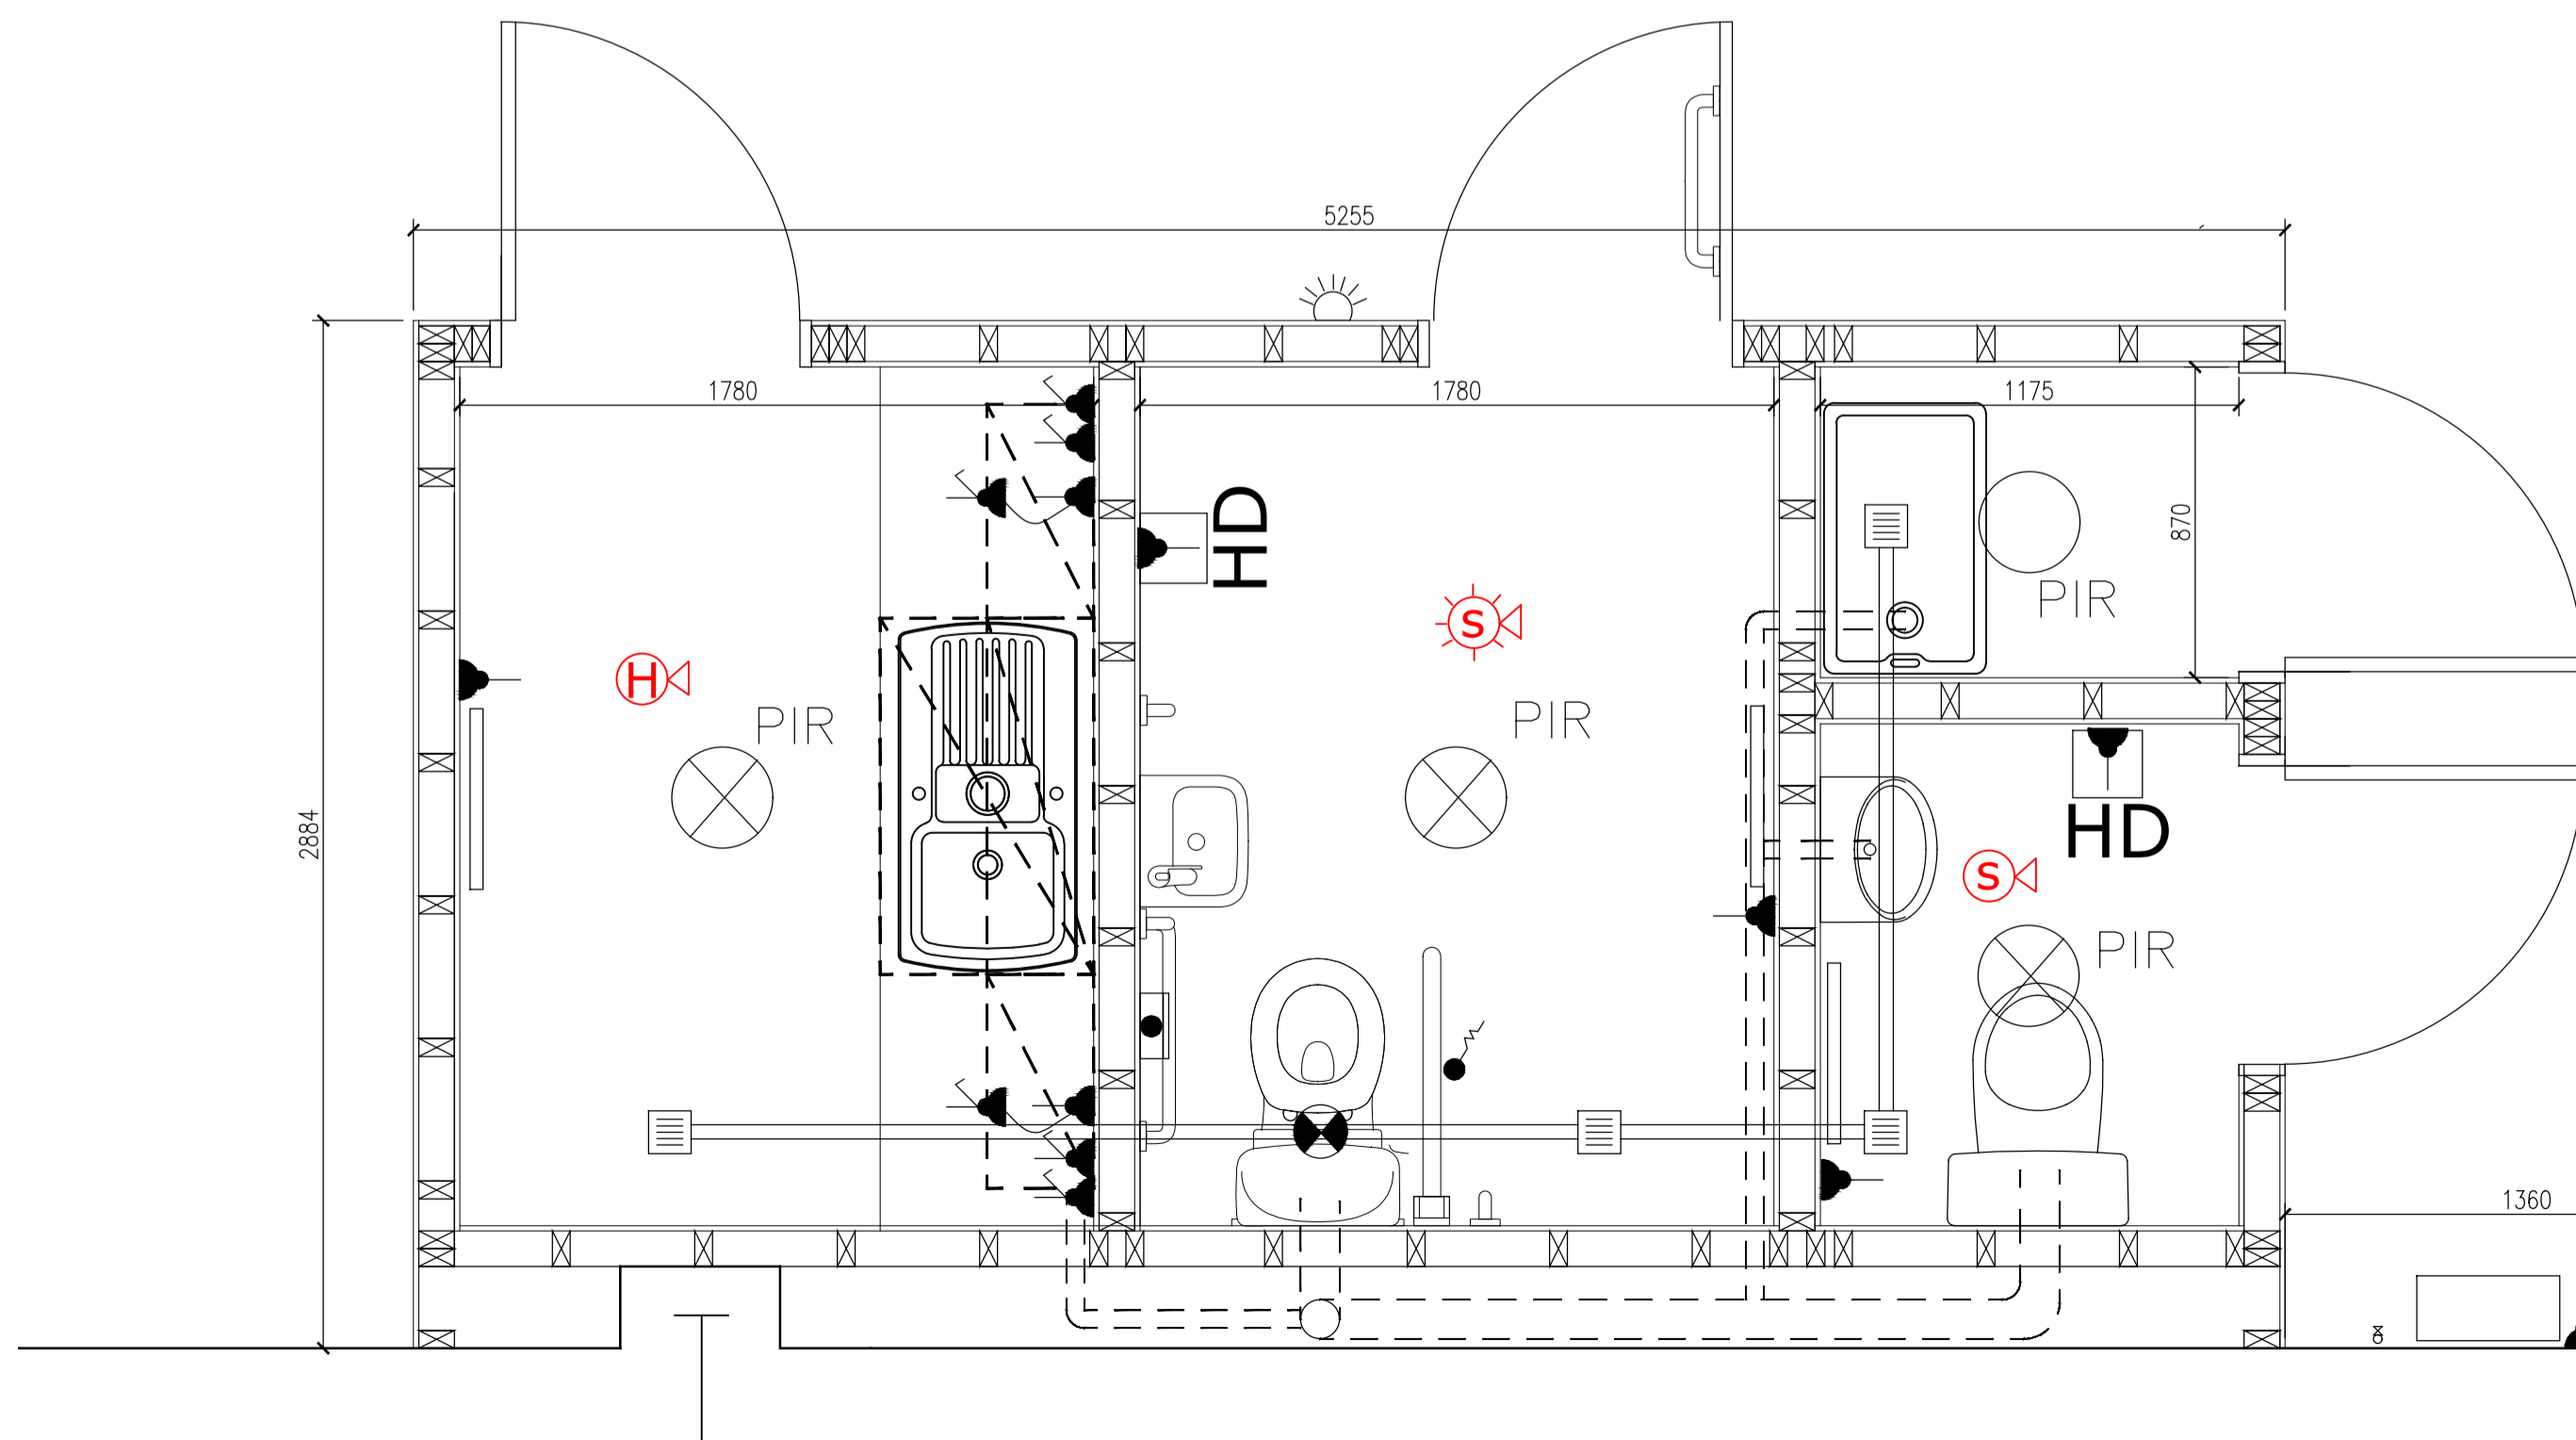

Proposed WC/Kitchenette block
1:20

Notes
Water heater- unvented Ariston Andris Lux Eco 15litre 3kW electric storage water heater and installation kit.
Electric rads throughout.
Extract to all rooms via ceiling mounted grill with connecting ductwork and extract fan above ceiling deck, with vent pipe penetrating through roof.
SVP to rise vertically and penetrate through roof.
Goodwill Roofing to provide penetrations and flashing seals to vent pipes.
Factory lighting not shown.
E-Fire to update fire detection layout.
Specification generally to replicate works within Unit 23.

West Suffolk Council
West Suffolk Property Services
West Suffolk House
Western Way,
Bury St. Edmunds
Suffolk, IP33 3YU
Tel: 01284 763233
Web: <https://www.westsuffolk.gov.uk>
E-Mail: property.services@westsuffolk.gov.uk

Project:
Internal alterations 22 James Carter Road, Mildenhall

Title:
Layout plans - services

Scale: **1:20, 100 @ A1** Drawing Size: **A1**

Date: **07.07.2020** Drawn By: **RJL** Appr By:

File No.: **30109** Drawing No.: **400** Revision: