


Ground Floor Plan

DEMISE PLAN
SCALE 1:50@A3

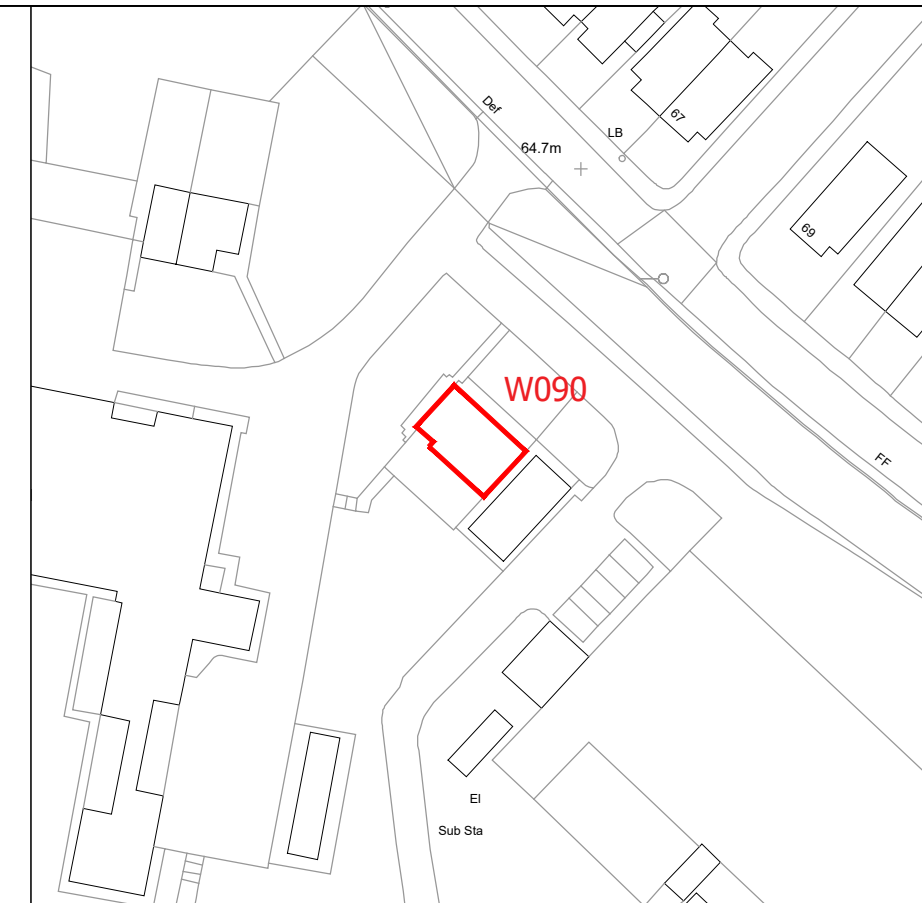

LOCATION PLAN
SCALE 1:1000@A3

Date Plotted		Time	
 University of Reading Facilities Management Directorate, Whiteknights, PO Box 235, Reading, RG6 6BW Tel. 0118 378 8958 Fax. 0118 975 3499			
Building			
Power Steele Room			
Project			
Property Services Lettings			
Title			
Demise & Location Plan Building and External Areas			
Drawn		Date	
CAD/AA		November 2022	
Job Number		Scale	
		As shown @ A3	
Building No.	Code	Drawing No.	Rev.
W090	B	028	