


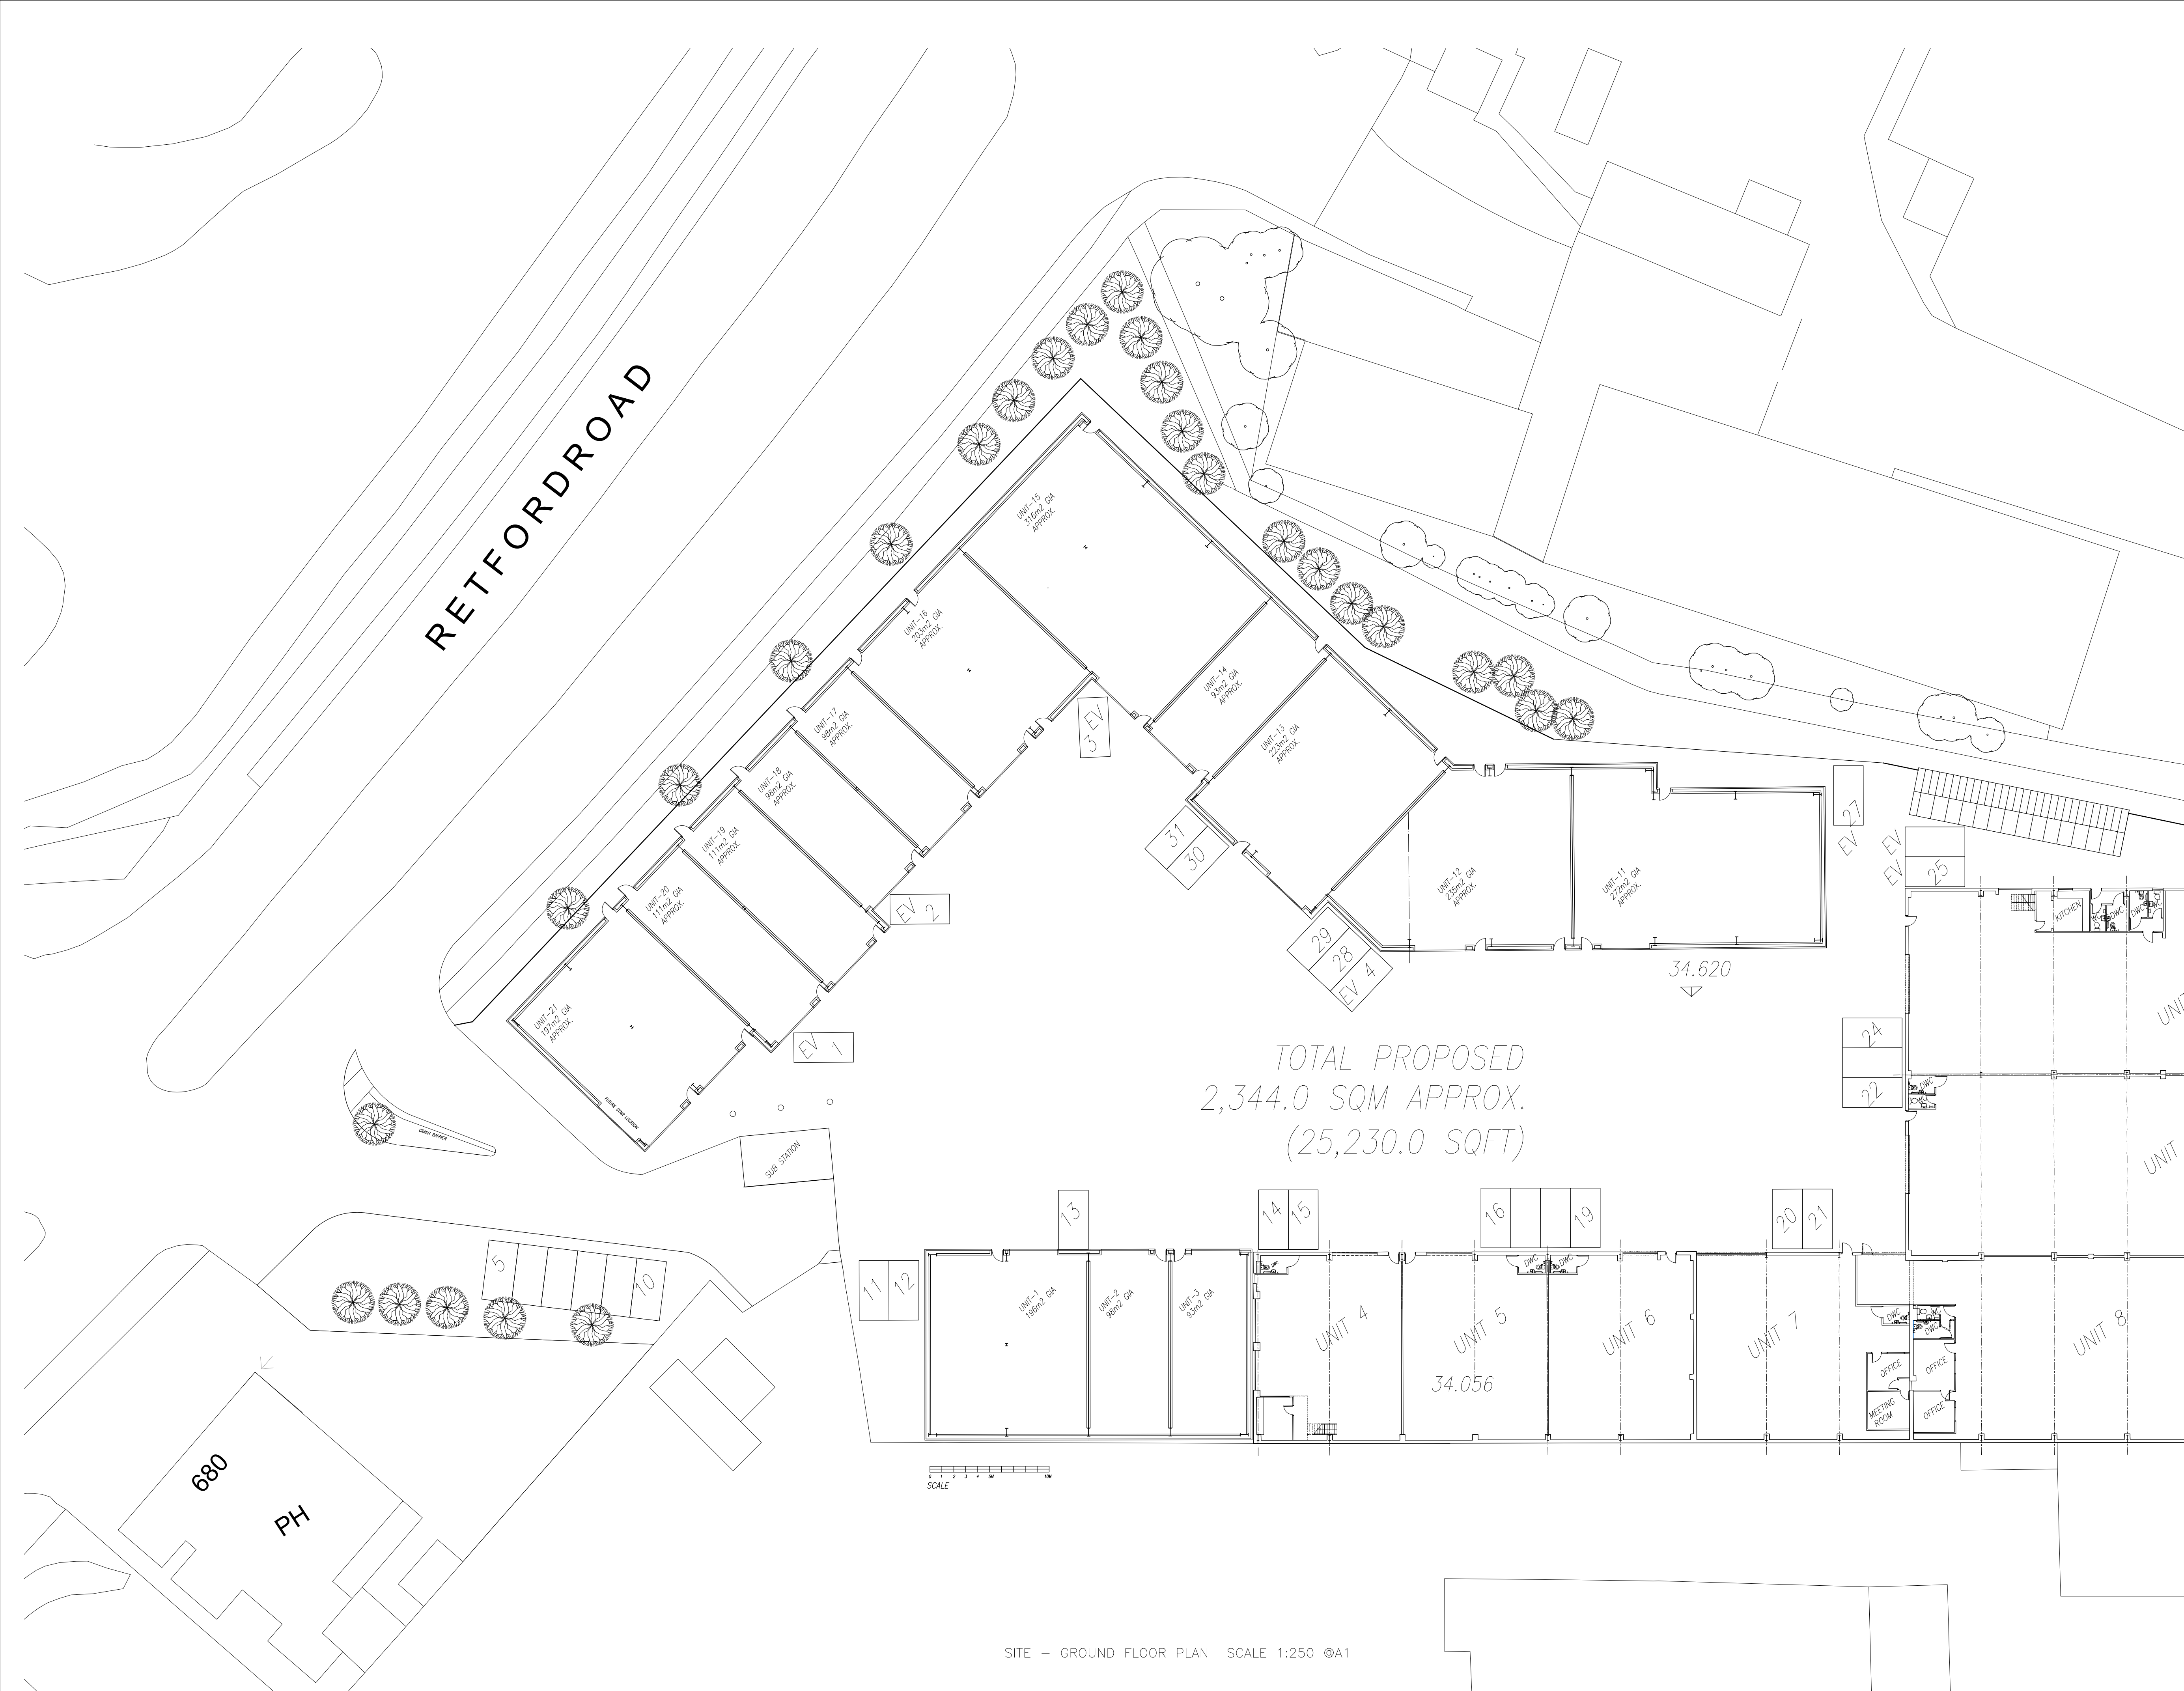

Contractors must verify all dimensions on site, prior to commencing works or preparing site drawings.  
Existing units switches, lighting, electrical boards and emergency detection and so on to be up-graded to current standards. Lighting layout to be discussed and agreed with builder and client.

|          |               |      |            |          |     |
|----------|---------------|------|------------|----------|-----|
| Revision | A             | Date | 26/11/2025 | Drawn By | AMA |
| Comments | PLANS AMENDED |      |            |          |     |
| Revision | -             | Date | 19/02/2023 | Drawn By | AMA |
| Comments | FIRST ISSUE   |      |            |          |     |

## SPACE studio

18 Mylor Road  
Sheffield  
S11 7PF

Telephone +44 (0) 114 263 1762

client

HATIRA HOLDINGS LTD

project  
WOODHOUSE MILL INDUSTRIAL ESTATE,  
RET FORD ROAD, ROTHERHAM, S13 9WG

title

SALES  
PROPOSED - GROUND FLOOR PLAN

drawing no A22-180/06-2 revision A Drawn By AMA  
scale 1:250 @ A1 date drawn 07/08/2025

SITE - GROUND FLOOR PLAN SCALE 1:250 @A1