


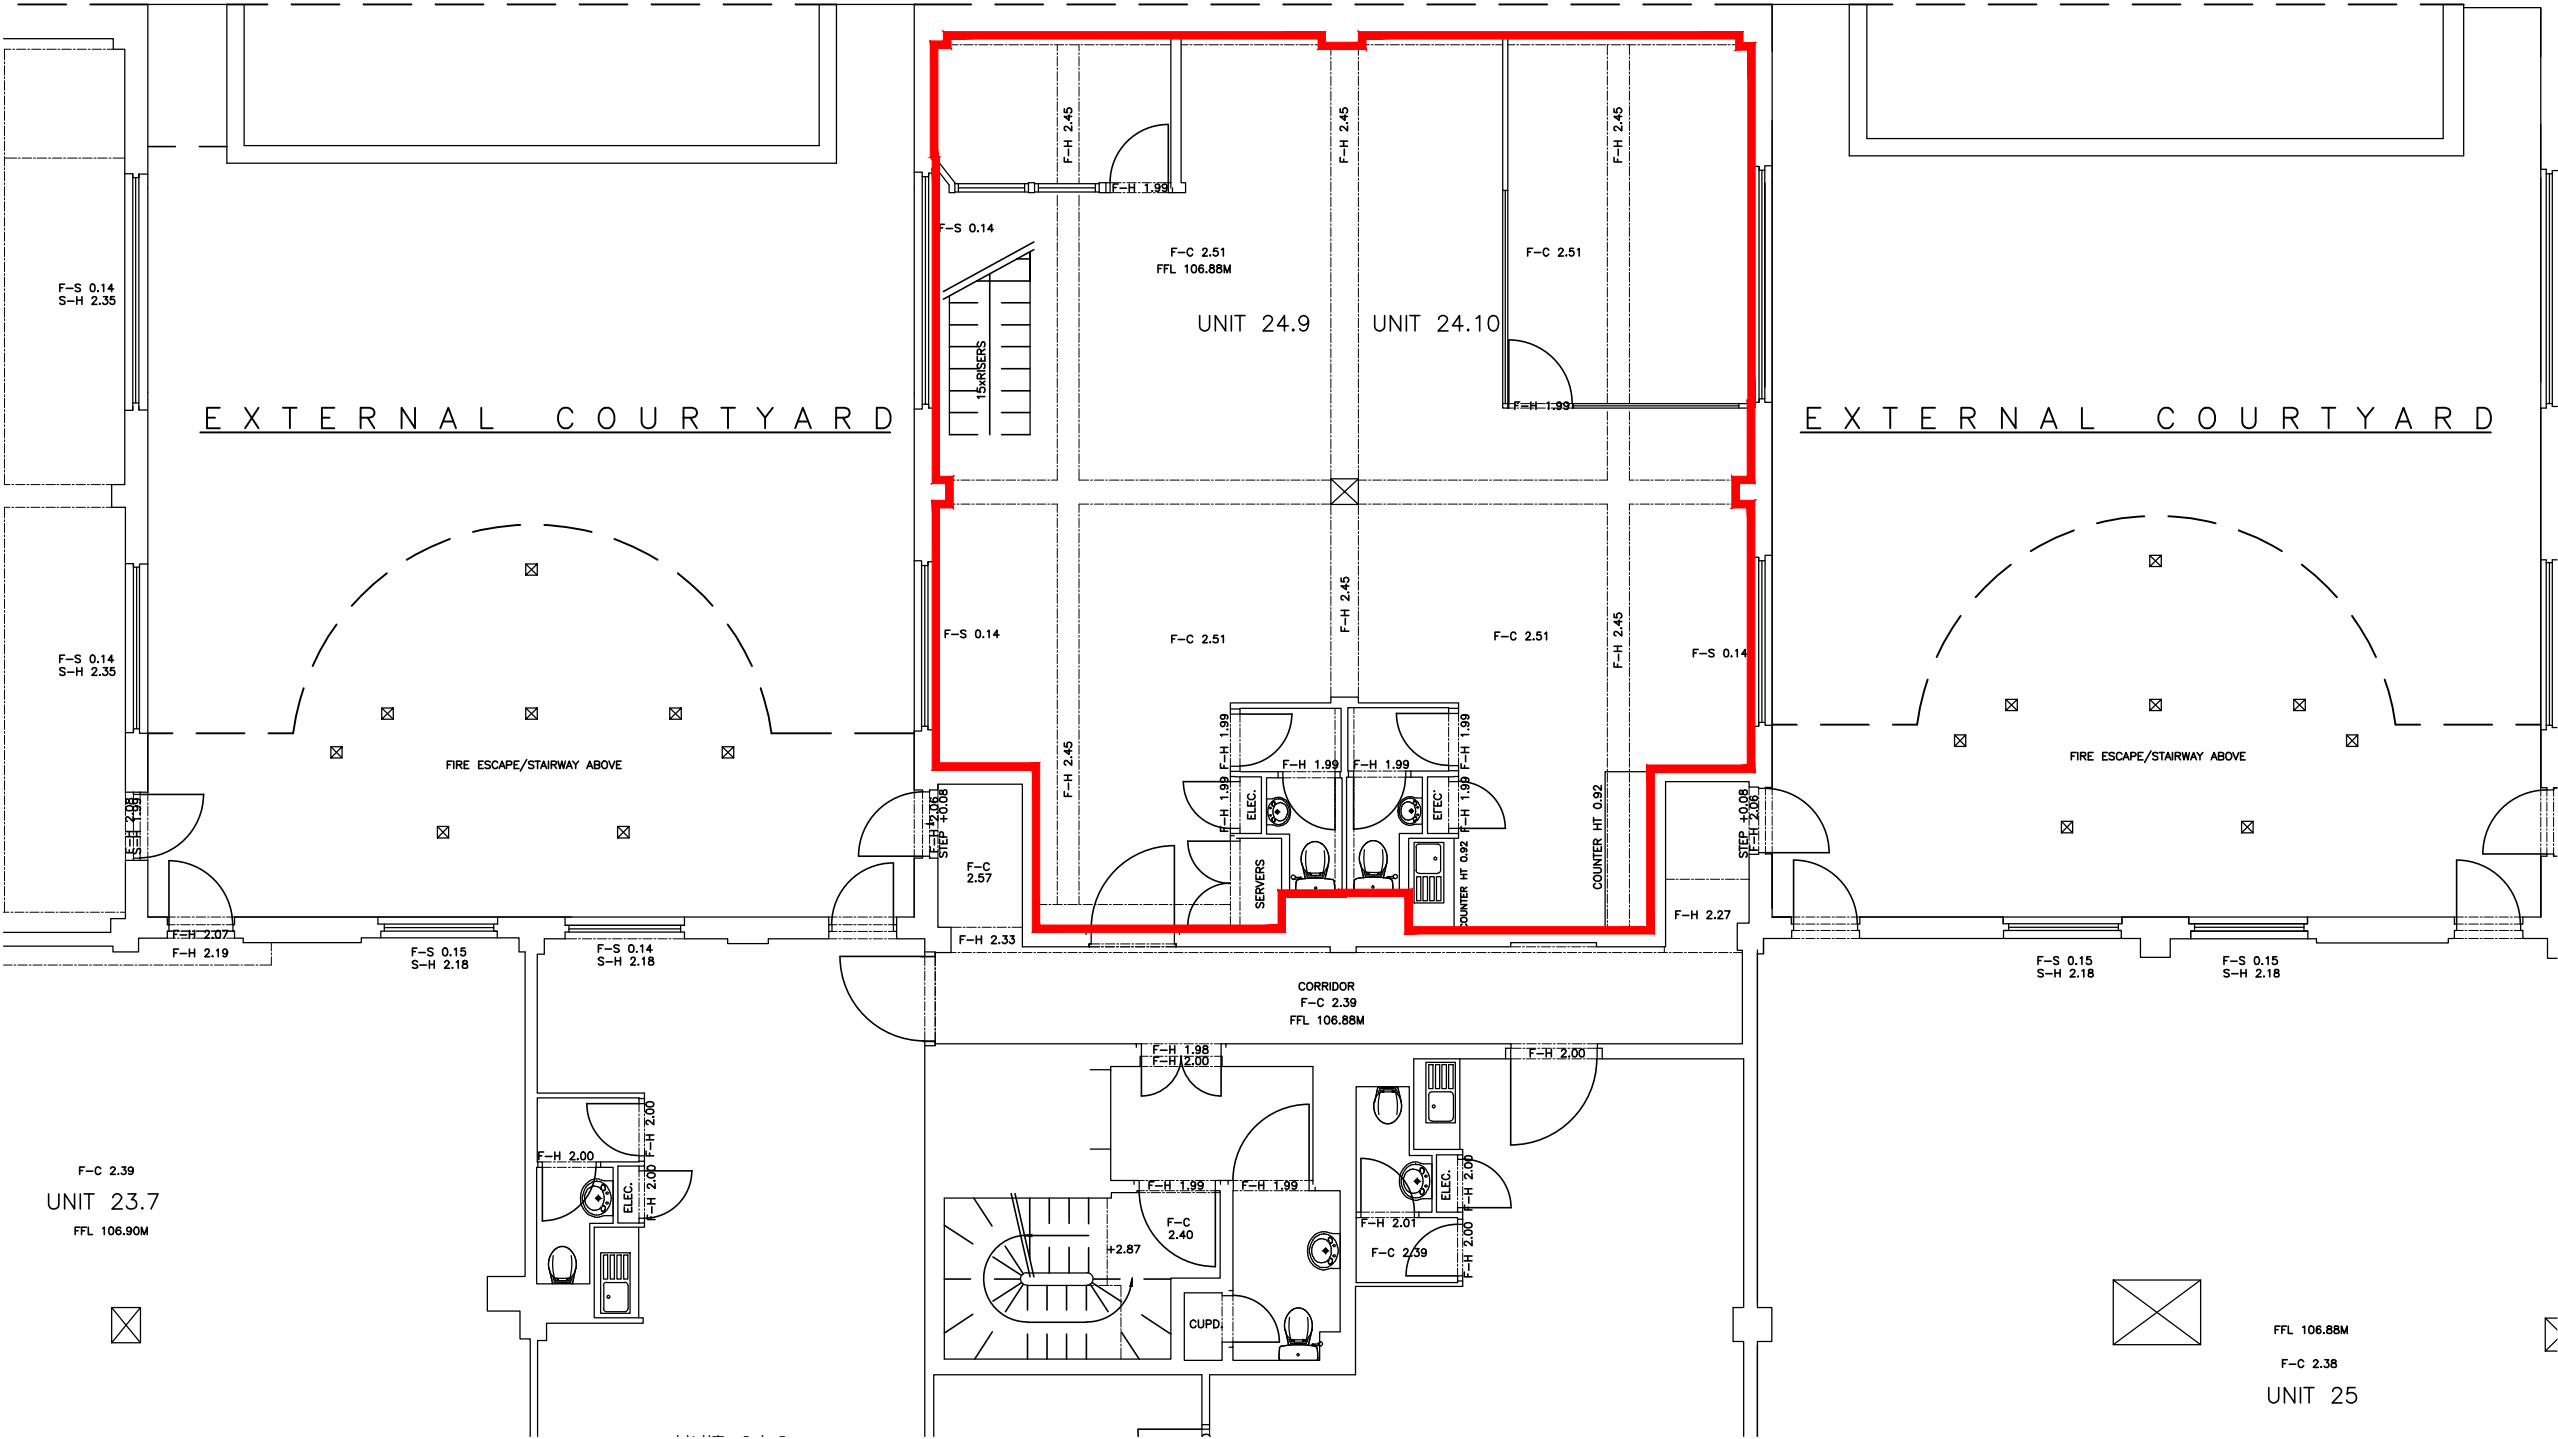

Third Floor Plan

DRAFT

Rev	Description	By	Date
-----	-------------	----	------



workman
building consultancy

Project
THE CODA CENTRE
MUNSTER ROAD, FULHAM

Client
SACKVILLE UK PROPERTY SELECT II

Title
UNIT 24.9 & 24.10
LEASE PLAN

Drawn by KJW	Surveyor EJM	Date SEPT '13
-----------------	-----------------	------------------

Scale
1:100@A3

Drawing Number L130365-A09-24.9	Revision
------------------------------------	----------