


F6A	JOHN RATED WALL	F6B	JOHN RATED WALL	F620	120MM RATED WALL
	PAW EXTINGUISHER		CO EXTINGUISHER		WATER EXT.
	FLAME DETECT		LAQUO EXT.		FLAME FILLET
	PULSED PANEL		BLESS BLAS ALARM		HPA FIRE DETECTOR
EXT	PAUL EXT. DIAL		SCAPE NOTAL		RELEASE
	JOHN RATED WALL		JOHN RATED WALL		120MM RATED WALL
	ALARM PANEL	QTY	QTY GEMERA		LINE OF SHUTTERS
	DUSTAL DIAL LOCK		SHUTTER CLOSING		PUR DETECTOR
	DISTRIBUTION RAIL		ELECTRON ELECTRO		ELECTRIC MOTOR
	DORAL SOCKET		LIGHT SWITCH		PLUG DOOR CATCH
	SPIDER SPRAY		PERMANENT LOCK		DESIGNED LATCH
	FLAME DETECT		DATA POINT		JOHN CABINET
	ELECTRIC LAMINAR		WASHING BASIN		DOORING UP
	WASHING WATER		WASHING BASIN		GA METER
	DOORING UP		WATER METER		WALL EXTRACT
	ROLLER		AIR CULIN EXTRACT		WALL EXTRACT
	DUALER		GEIL OUTLET		EXTRACT SHUTTER
	THERMISTAT		A/Q OUTDOORS		OUTLET CONTROLS
	A/Q GASSETTE		A/Q OUTDOORS		WALL HOVEDD A/Q
	GOLD WATER FEED		NOT WATER FEED		POOL RAIL RAIL
	SOLD WALL		STW WALL		JOINT DIRECTON

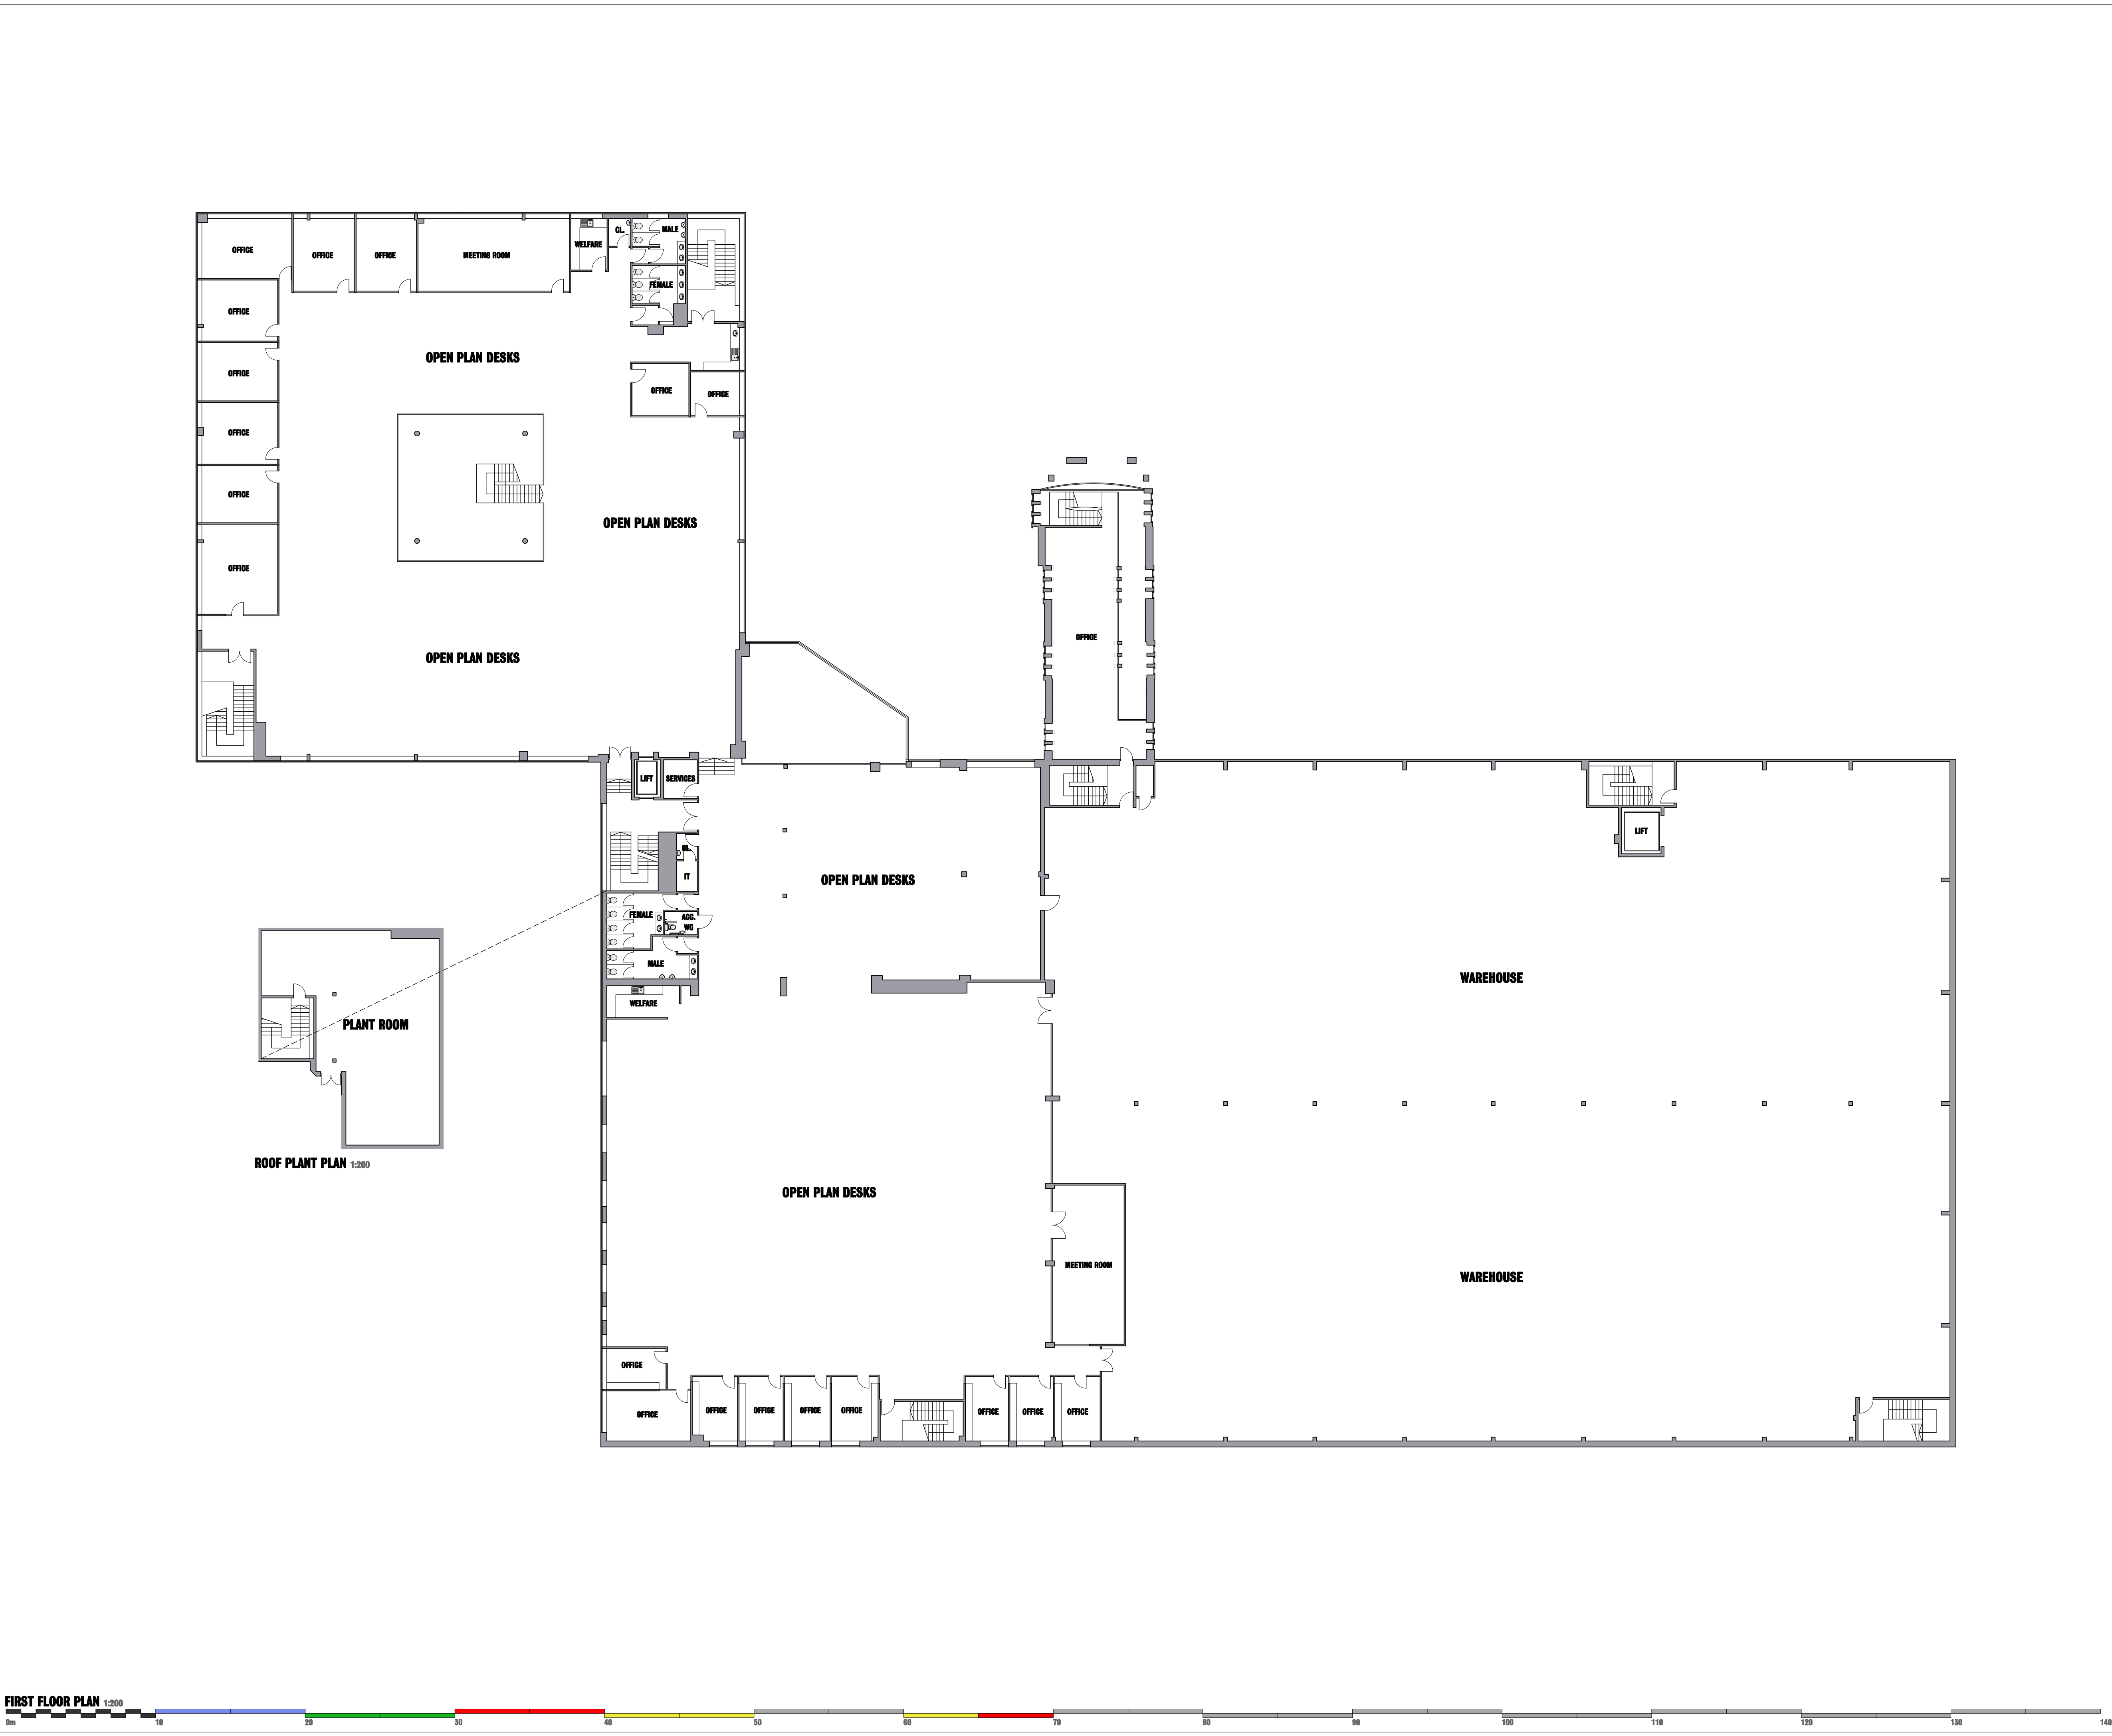

0

INITIAL ISSUE

18/12/23

DMU DESIGNS

ARCHITECTURAL SERVICES LTD

PLANNING APPLICATIONS

BUILDING REGULATIONS

RESIDENTIAL BUILDING SUBSISTES

WORKING DRAWINGS

FORMALISATION / SECTION ORDERING

SPACE PLANNING

MAIL @DMUDESIGNS.CO.UK

WWW.DMUDESIGNS.CO.UK

+44 1915 157365

CLIENT

WL REALISATIONS (2023) LIMITED

STATUS

PROPERTY AS EXISTING

DRAWING NUMBER

3116-002

DRAWING TITLE

FIRST FLOOR PLAN

DRAWING REVISION

0

DATE

DECEMBER 2023

SCALE

1:200

PAPER SIZE

A1

DRAWN BY

PTM

PROPERTY

JK HOUSE, ROEBUCK WAY,
MANTON WOOD, WORKSOP,
NOTTINGHAMSHIRE, S80 3EG

DO NOT SCALE FROM THIS DRAWING, ANY DISCREPANCIES TO BE REPORTED IMMEDIATELY.
DMU DESIGNS IS A LIMITED COMPANY REGISTERED IN ENGLAND AND WALES. REGISTERED NUMBER: 118097