



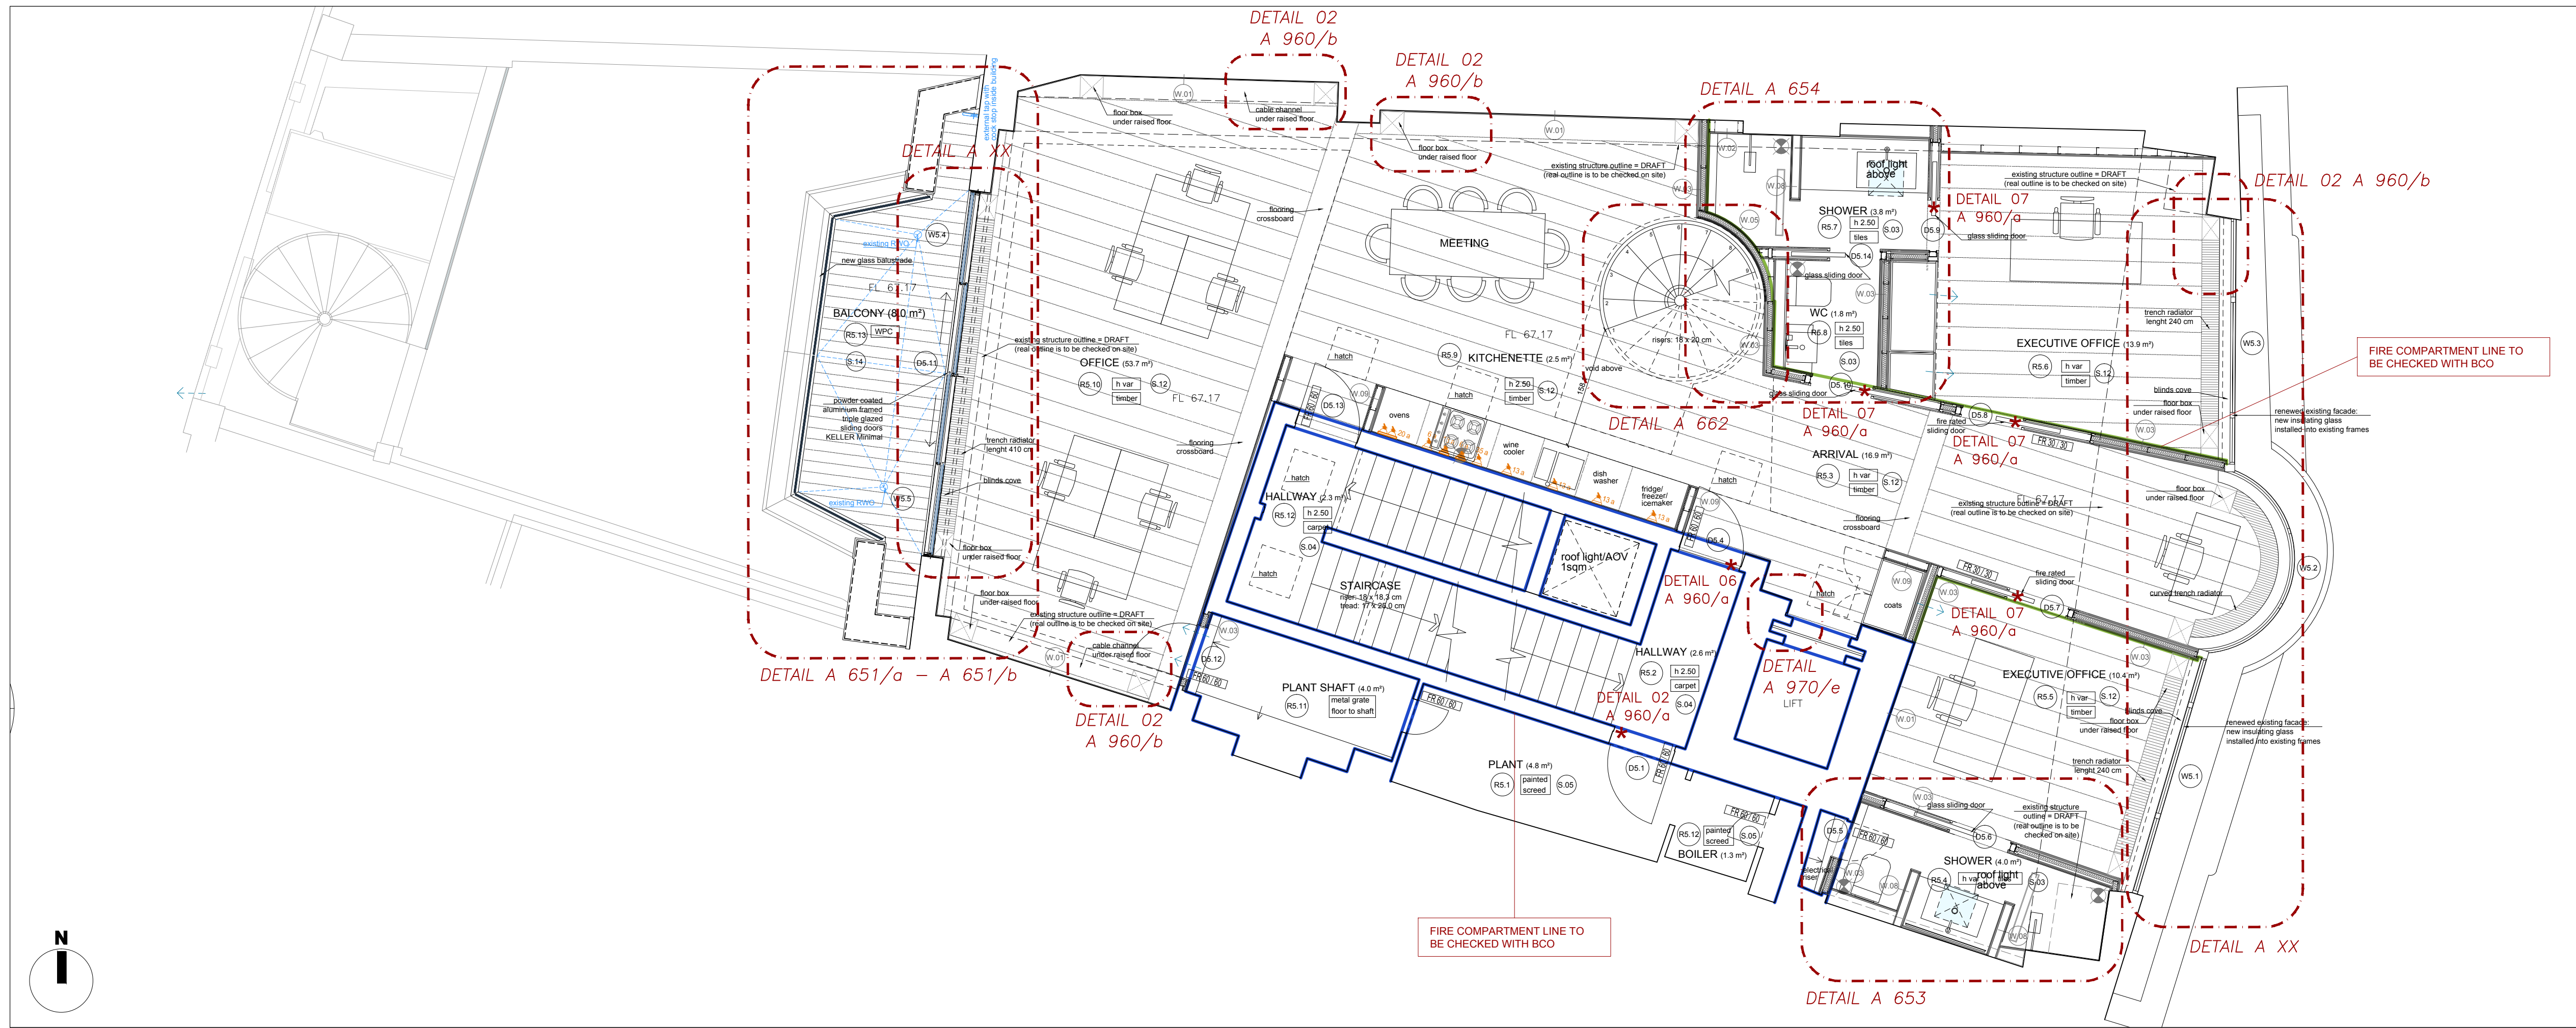

5th FLOOR PLAN
1:50 @ A1 Size

LEGEND / CEILING	
h 0.00	NET HEIGHT
RB.0	ROOMS CODE
DB.0	DOORS CODE
WB.0	WINDOWS CODE
W.00	WALL CODE (for walls details refer to A 920 drawing)
S.00	SLAB CODE (for slab details refer to A 930 drawing)
	CEILING EXTRACT FAN
	LIGHT SWITCH
	DIMMER LIGHT SWITCH
	SOCKET _ HIGH LEVEL
	SOCKET _ LOW LEVEL
	SPEAKERS TO CEILING
	30 MIN FIRE RATING
	60 MIN FIRE RATING
LEGEND / LIGHTING	
h 0.00	CEILING NET HEIGHT
	STANDARD BOARDS - GYPLOC WALLBOARD
	STANDARD BOARDS - GYPLOC WALLBOARD
	PERFORMANCE BOARDS - GYPLOC MOISTURE RESISTANT
15.0mm	PLASTERBOARD THICKNESS
	VERTICAL GYPSUM FASCIA
	COVE LIGHTING
Stand	GYPROC PROFILEX STANDARD ACCESS PANEL
55x55	HATCH DIMENSIONS
LEGEND / LIGHTING	
(A)	WALL WASHER, FLOS, Soft LED curtain recessed
(B)	DOWN LIGHT, REGENT, Echo 210 LED (IP20)
(C)	DOWN LIGHT, REGENT, Medra LED (IP20)
(C14)	DOWN LIGHT, REGENT, Medra LED (IP44)
(D)	LED TAPE LIGHT, ZONCA, Strip (IP20)
(E)	COVE LIGHTING, ZONCA, Strip (IP20)
(E65)	COVE LIGHTING, ZONCA, Strip (IP65)
(F)	SUSPENDED LIGHT, PENTA LIGHT, Sospensione cilindro maxi (custom made)
(G)	1 £ LIGHT
(H)	1 £ WALL LIGHT
(I)	FLOOR UPLIGHT, (IP65)
*	DAYLIGHT AND MOTION DETECTING LIGHT MANAGEMENT SYSTEM
#	ELECTRIC POWER SWITCHBOARD MANAGEMENT SYSTEM

Notes:
1. No dimensions are to be scaled from this drawing.
2. All dimensions are to be checked on site prior to fabrication.
3. Any discrepancies on site have to be reported to the architect.

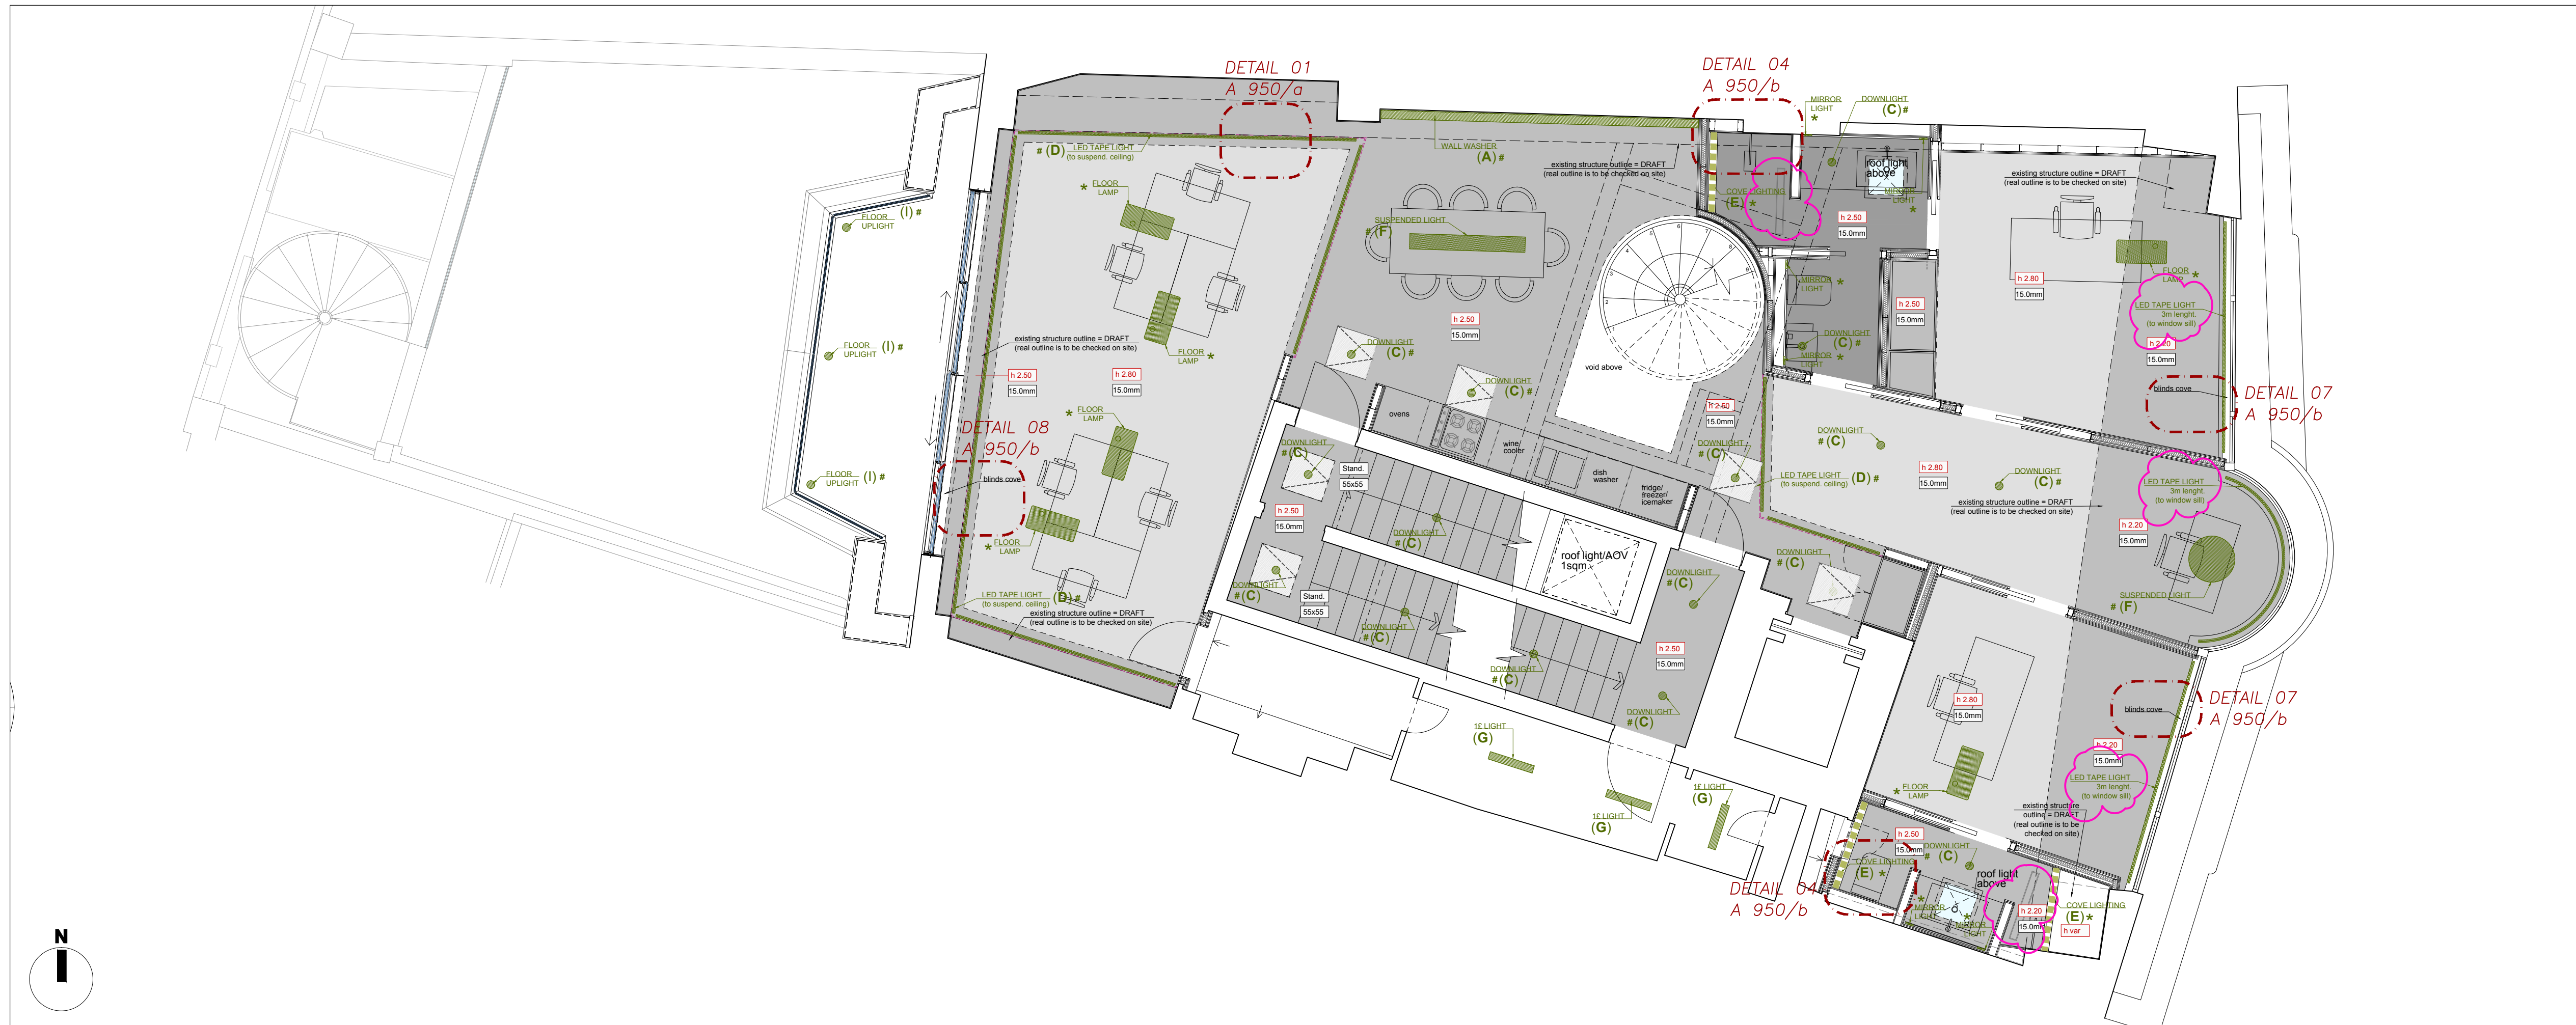

5th FLOOR: CEILING PLAN
1:50 @ A1 Size

OFFICE ART AG 8 CITY ROAD, LONDON EC1

REFURBISHMENT OF EXISTING OFFICE BUILDING

5th FLOOR:
PLAN + REFLECTED CEILING PLAN
A 105

Status: / Date: 01.04.2015 Drawn: EP Scale: 1:50
rf: 316
□ □ □

CLIENT / COMMITTEE
OFFICE ART AG

PLANNING PERMISSION ARCHITECTS
Simon Smith & Michael Brooke Architects
No 3 Scout Lane, London SW4 0LA
0044 20 7627 7630
post@smithbrooke.co.uk

PROJECT MANAGER
iC consultants Ziviltechniker GesmbH
Mr. Markus Querner
Schönbrunner Straße 297
1120 Wien, Austria
0043 1 521 69-0
pm@iclyroad@ic-ces.at

CONSULTANT ARCHITECTS
VENELLI KRAMER PROGETTI SH
Arch. Ruggero Venelli - Arch. Cecilia Kramer
Via Pisani Dossi 5a, 22100 Como, Italia
0039 031 570779
info@venellikramer.com

LENA ZEIDLER Architect
8 City Road, London EC1
0044 7715395652 (mobile)
lena.zeidler@8cityroad.co.uk

M&E PROJECT

REVISION

Window sill with LED light updated. Bathroom gullies position updated.