


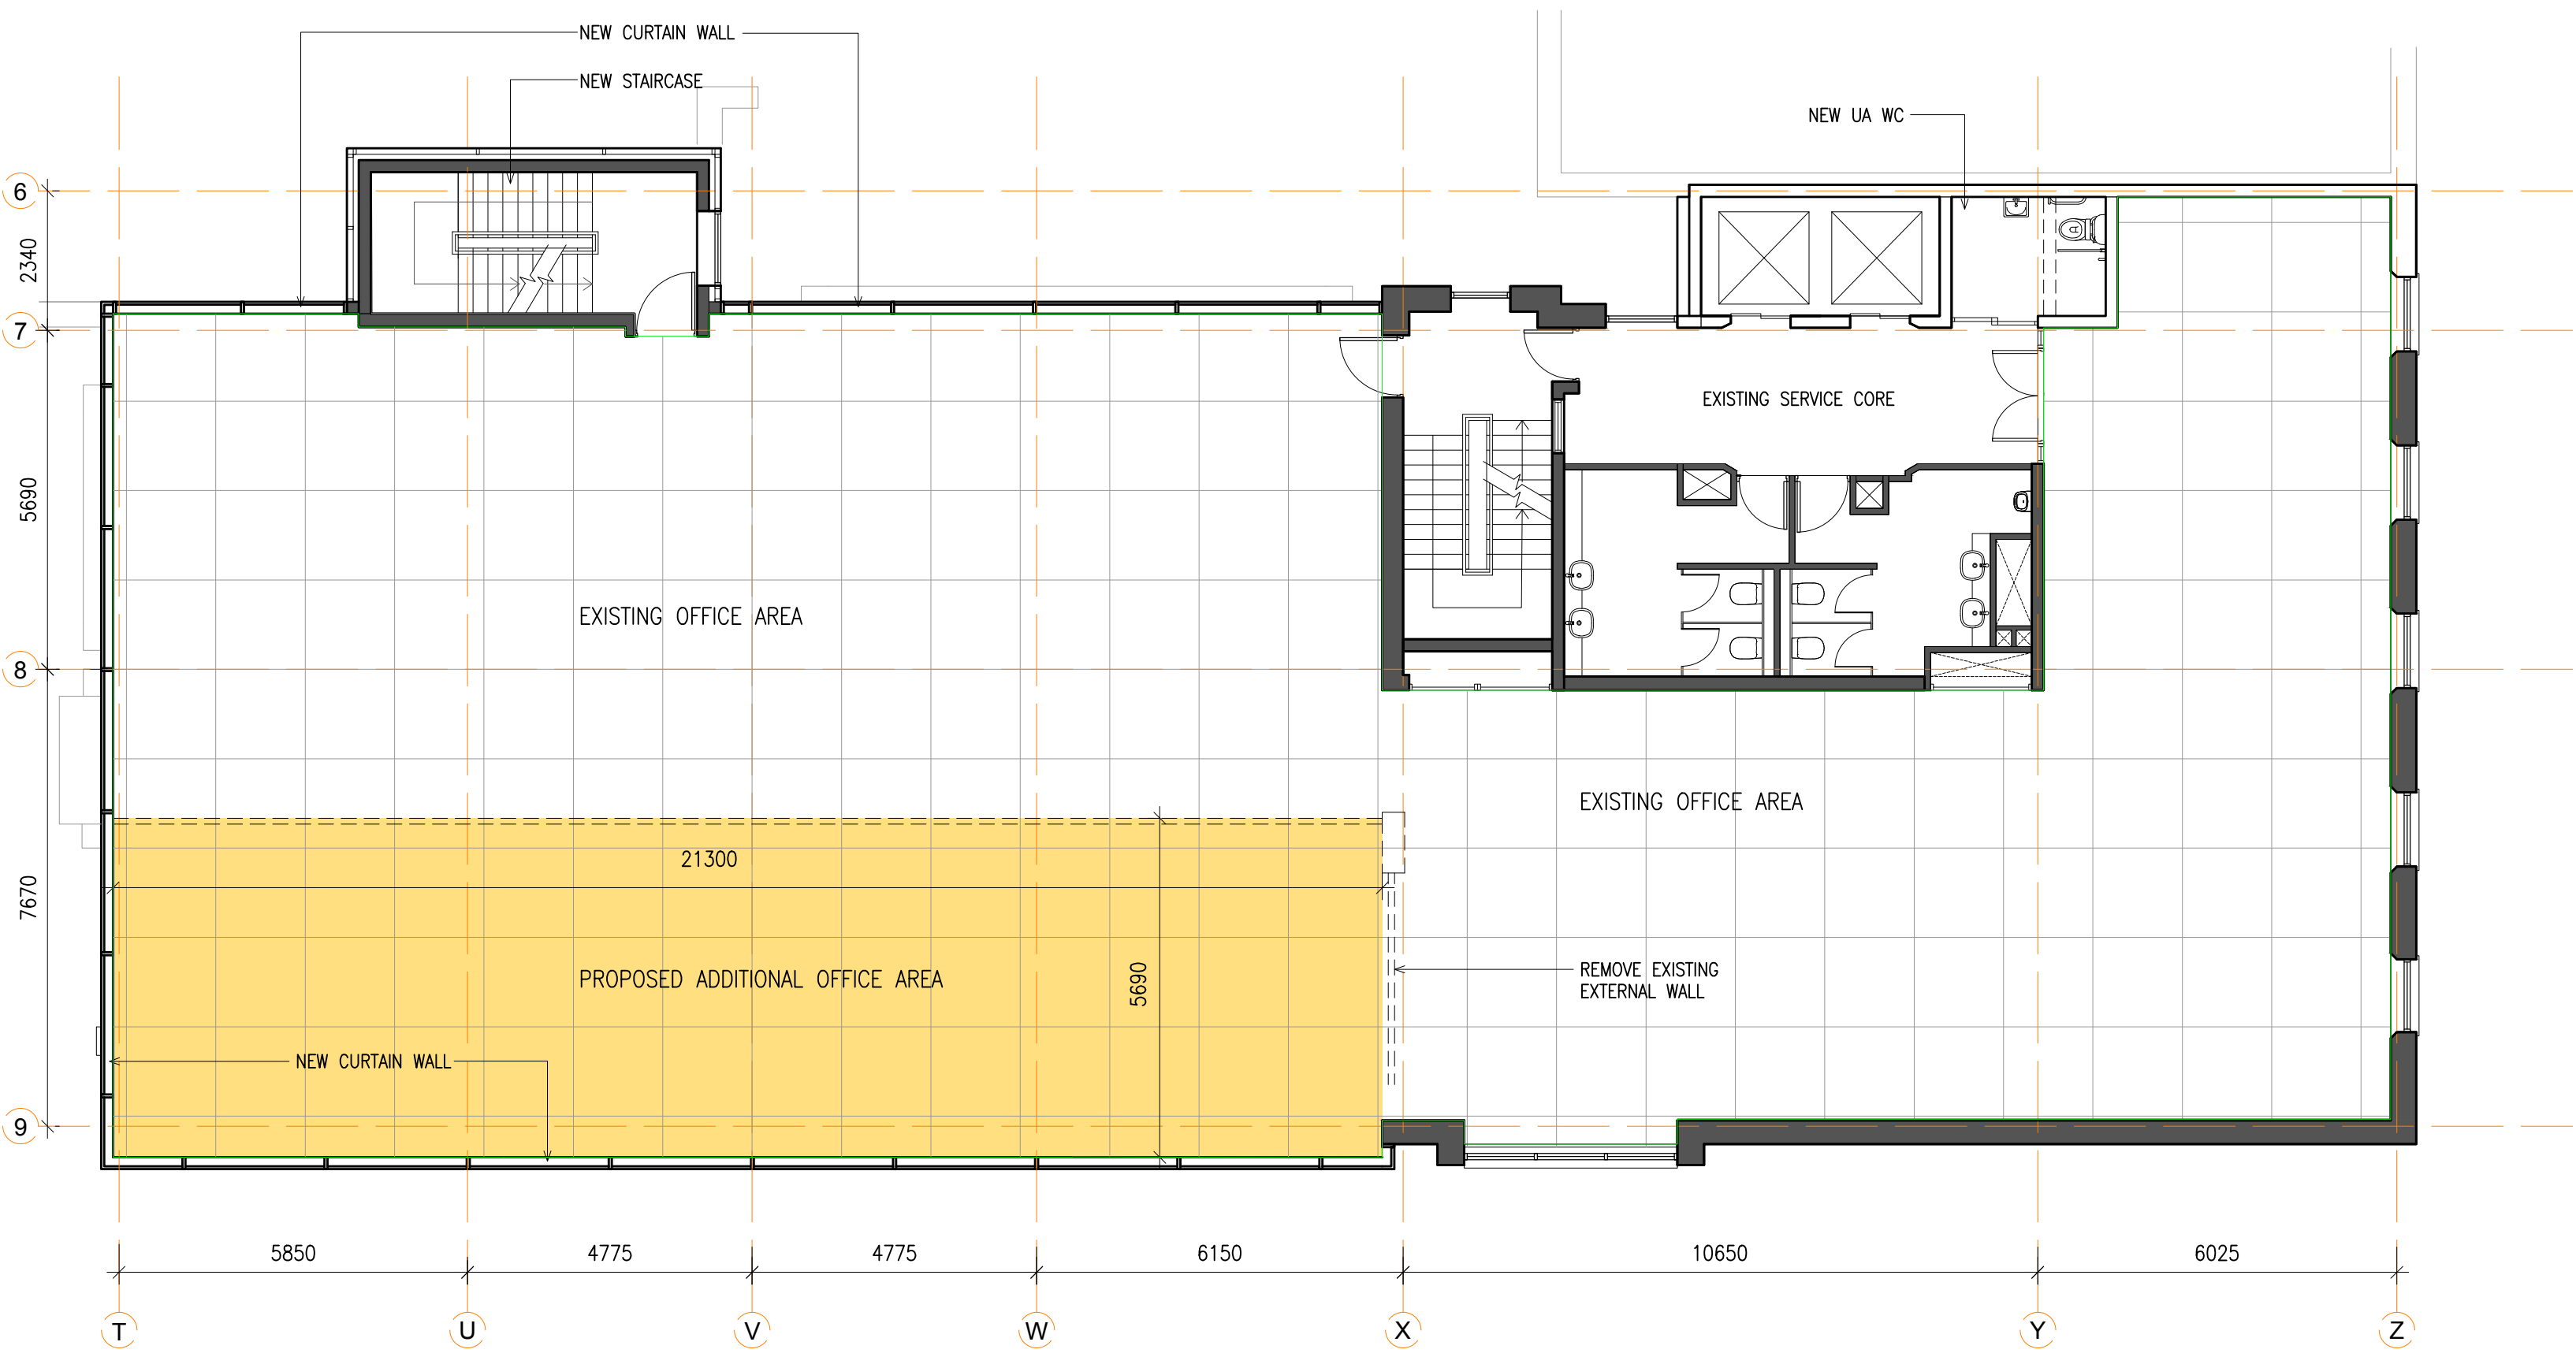

2nd Floor - Proposed
Net Area: 465sq.m
Gross Area: 565sq.m

Notes					No.	Date	Revision	Initials
1. Copyright Reserved					A	29.03.19	DRAFT ISSUE	RMcG
2. Work to figured dimensions only. Do not scale drawing.								
3. The contractor is responsible for checking all levels and dimensions on site and shall refer all discrepancies to the Architect.								
4. Where appropriate, for details of r.c. structure, or mechanical and electrical details, see Engineers drawings.								
5. Proprietary items shall be fixed in strict accordance with manufacturers instructions.								
6. Sizes of proprietary items shall be checked with manufacturer.								
7. The contractor shall be responsible for the coordination of structure, finishes and services.								
C:\Users\rmcgee\Desktop\Ossory House\6208-000 (Plans).dwg 29/03/2019 17:08:29								

Issue Status	
Progress	
Planning Application	■
Fire Cert	
Tender	
Construction	
As Built	
Information Only	

Project		OSSORY HOUSE REFURBISHMENT & EXTENSION		6-7 HARDCOURT TERRACE, DUBLIN 2, IRELAND t +353-1-618 2400 f +353-1-678 7295 e architecture@bkd.ie www.bkd.ie			
Drawing Title		SECOND FLOOR PLAN		bkd architects BURKE-KENNEDY DOYLE			
Drawing No		6208-007					
Scale	1:100@A1	Rev	A	Drawn	RMcG	Date	March 2019