


PROPOSED GROUND FLOOR PLAN
scale 1:50

DRAFT

- WASTE
- SVP
- POP UP
- RAIN WATER PIPE
- GULLY
- BOILER
- BOILER FLUE
- CONSUMER UNIT
- TOWEL RACK
- RADIATOR
- MANIFOLD
- FCU
- EXTRACTOR FAN
- FIRE ALARM PANEL

- EXISTING WALL
- NEW RC WALL
- NEW MASONRY WALL
- NEW STUD PARTITIONS
- NEW EXTERNAL STUD WALL

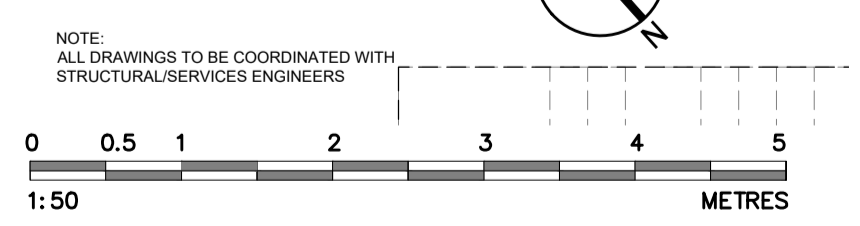

Status	Description	date	drawn by	checked by	Status	Description	date	drawn by	checked by
-	FOR INFORMATION	06/09/2017	JB	MS	-				

"copyright and ownership of this drawing is vested in paul murphy architects whose prior written consent is required for its use, reproduction or for publication to any third party.
all rights reserved by the law of copyright and by international copyright conventions are reserved to paul murphy architects and may be protected by court proceedings for damages and/or injunctions and costs."
do not scale this drawing
all written dimensions are in millimetres
any inconsistencies to be reported to the architect immediately
© paul murphy architects 2007

PaulMurphyArchitects

The Foundry
7 Glenthorne Mews
London W6 0LJ
T 020 8846 2520
F 020 8846 2521
info@paulmurphyarchitects.co.uk
www.paulmurphyarchitects.co.uk

client HAND & FLOWER PROPERTIES LTD
project HAND & FLOWER
drawing ALTERNATIVE PROPOSED GROUND FLOOR
stage 4 scale 1:50 @A1
no 1702 SK 1003 rev -