


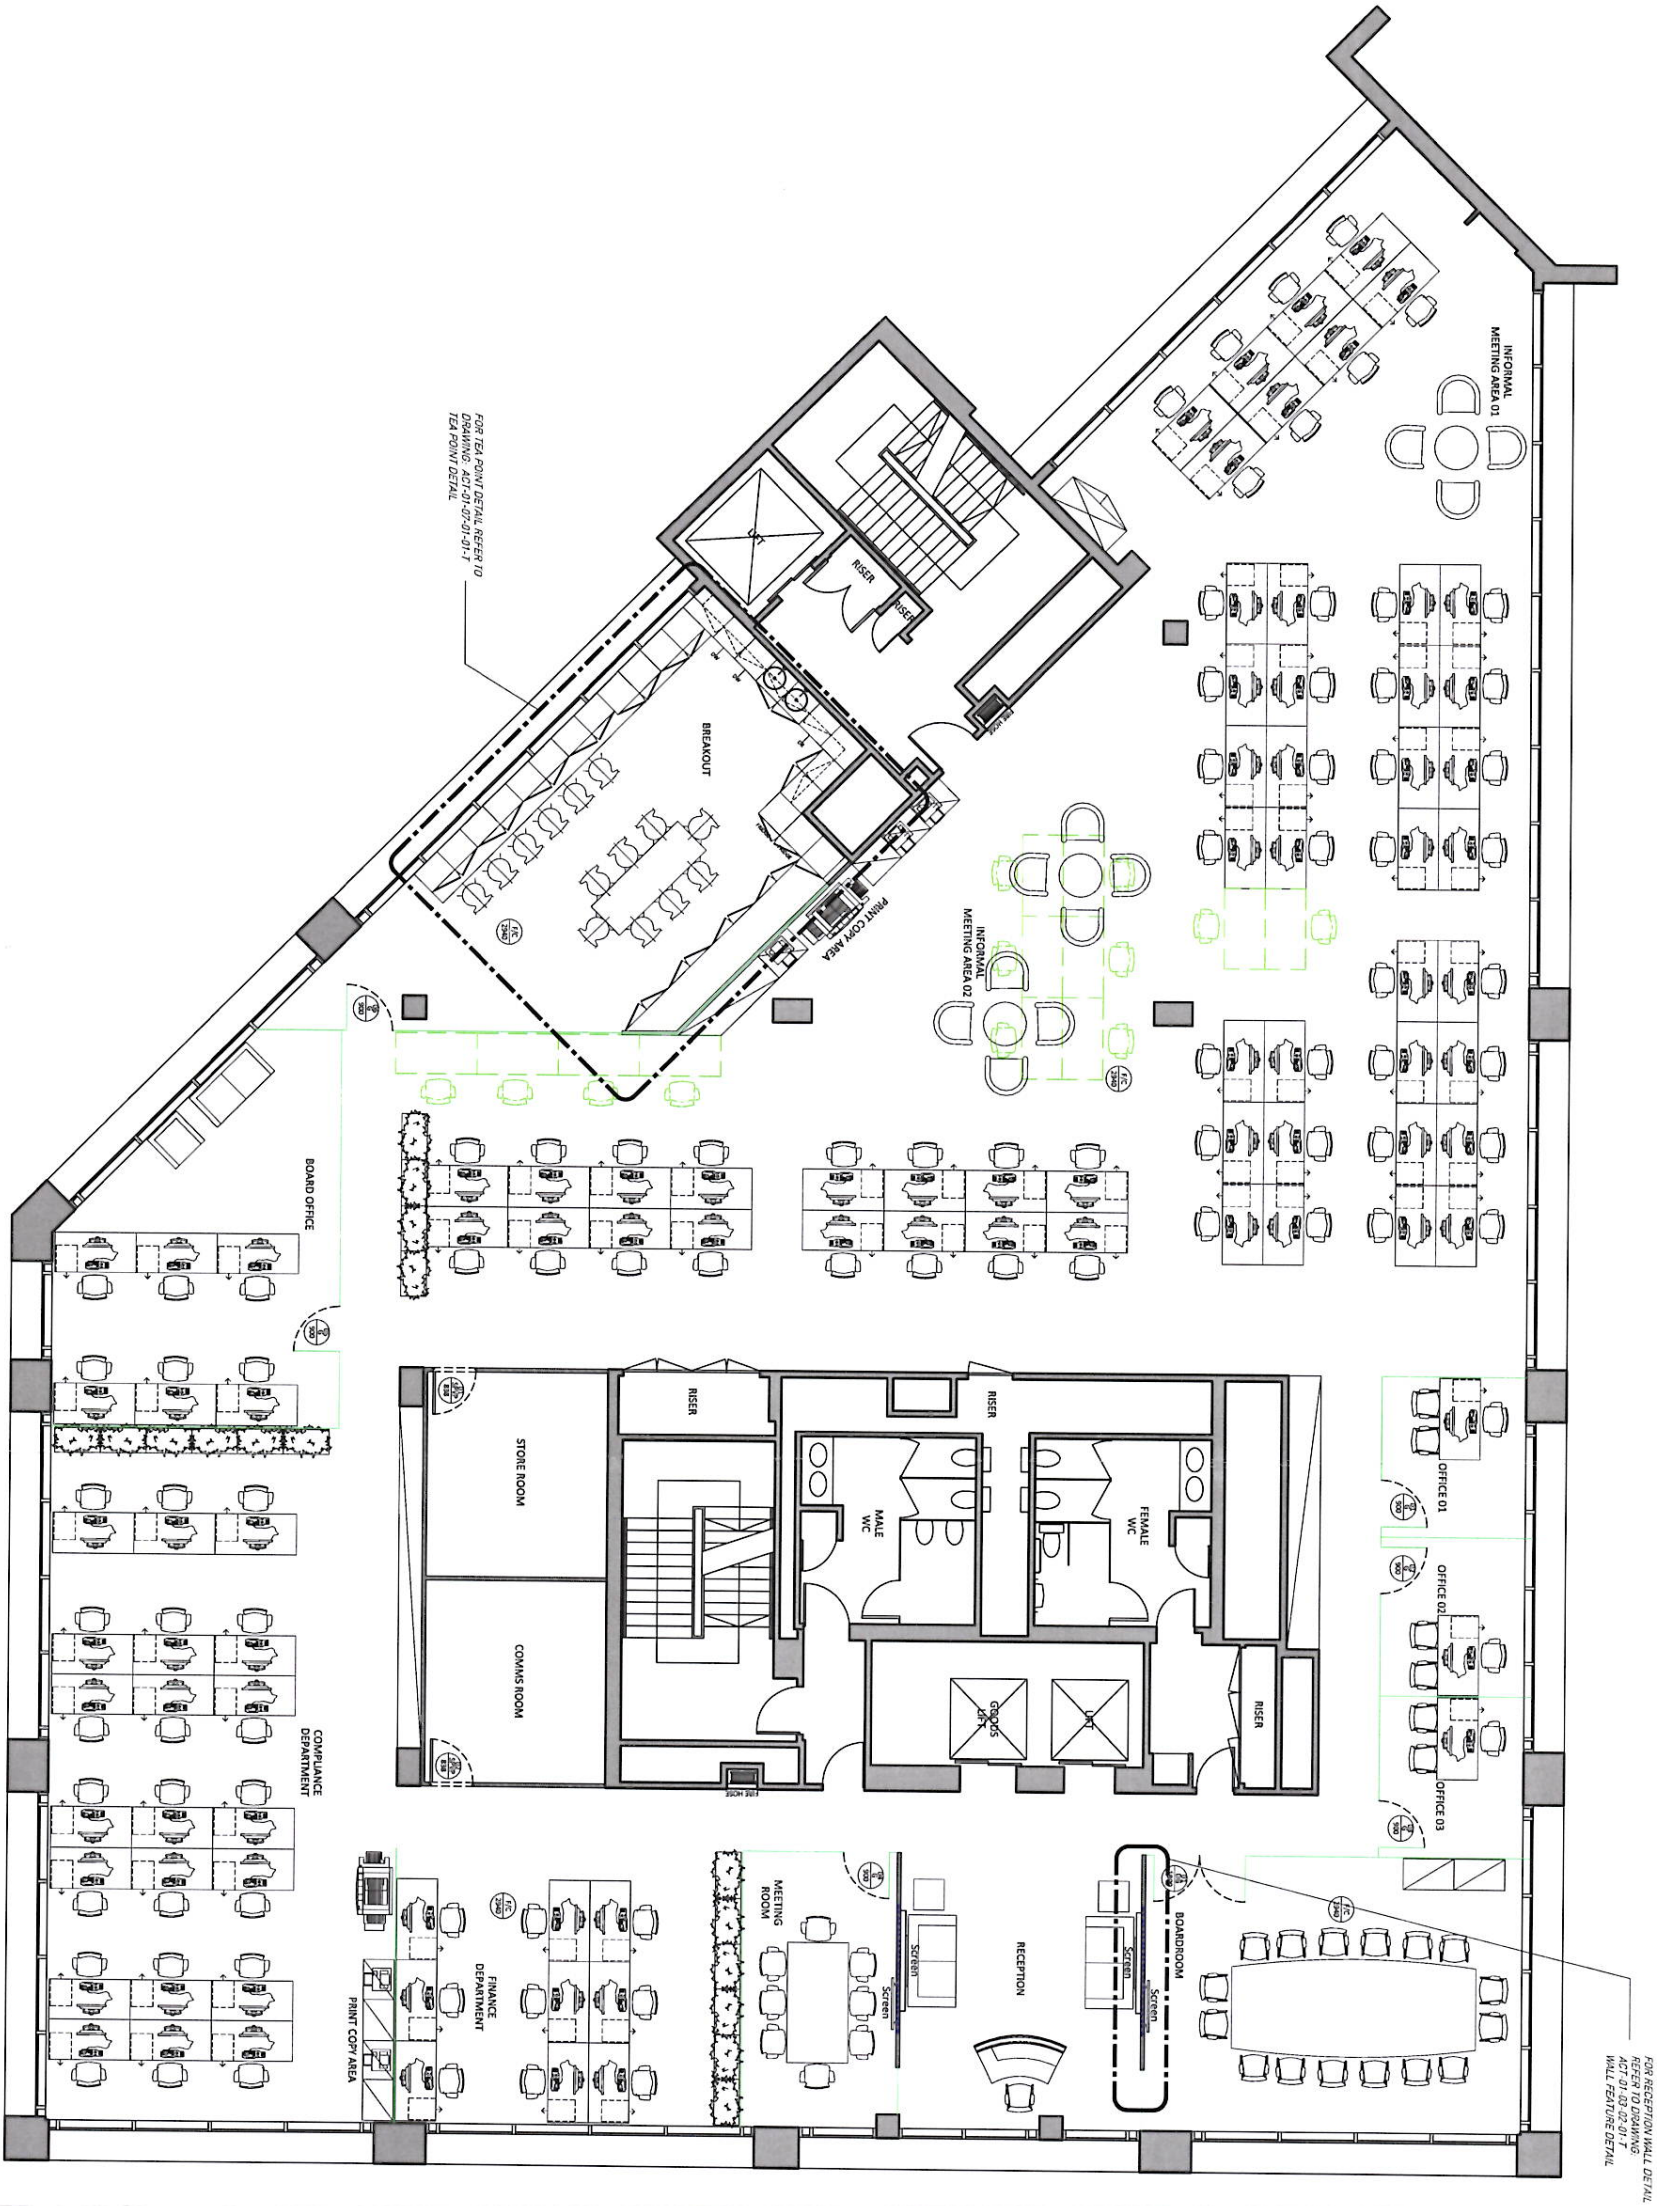

ALL PARTITION IS ALUMINIUM STUD WITH 12.5mm PASTERBOARD UNLESS OTHERWISE STATED

SINGLE SKINNED 75mm PARTITION WALL WITH ROCKWOOL INSULATION

DOUBLE SKINNED - GYPROC ON HALF-HEIGHT WALL (1200mm Wall Height)

12mm SILICONE BONDED GLASS WITH DDA MANIFESTATION

PLY REINFORCEMENT

CEILING HEIGHT

STANDARD DOOR - PAINT GRADE - VISION PANEL

PULL HEIGHT DOOR - GLASS DOOR

PULL HEIGHT DOOR - 100% GLASS DOOR

COLOUR CODE

FURNITURE FUTURE EXPANSION



WWW.CCTINTERIORS.COM

Site: 1st Floor, Apollo Court, London, E1W 1YZ


Project: 1 Thomas More Street, London, E1W 1YZ

Designer: Nicola Plummer

Project Director: Morrie Smit

General Layout

Project	Scale	Rev	Date
ACT-01	01	00	01

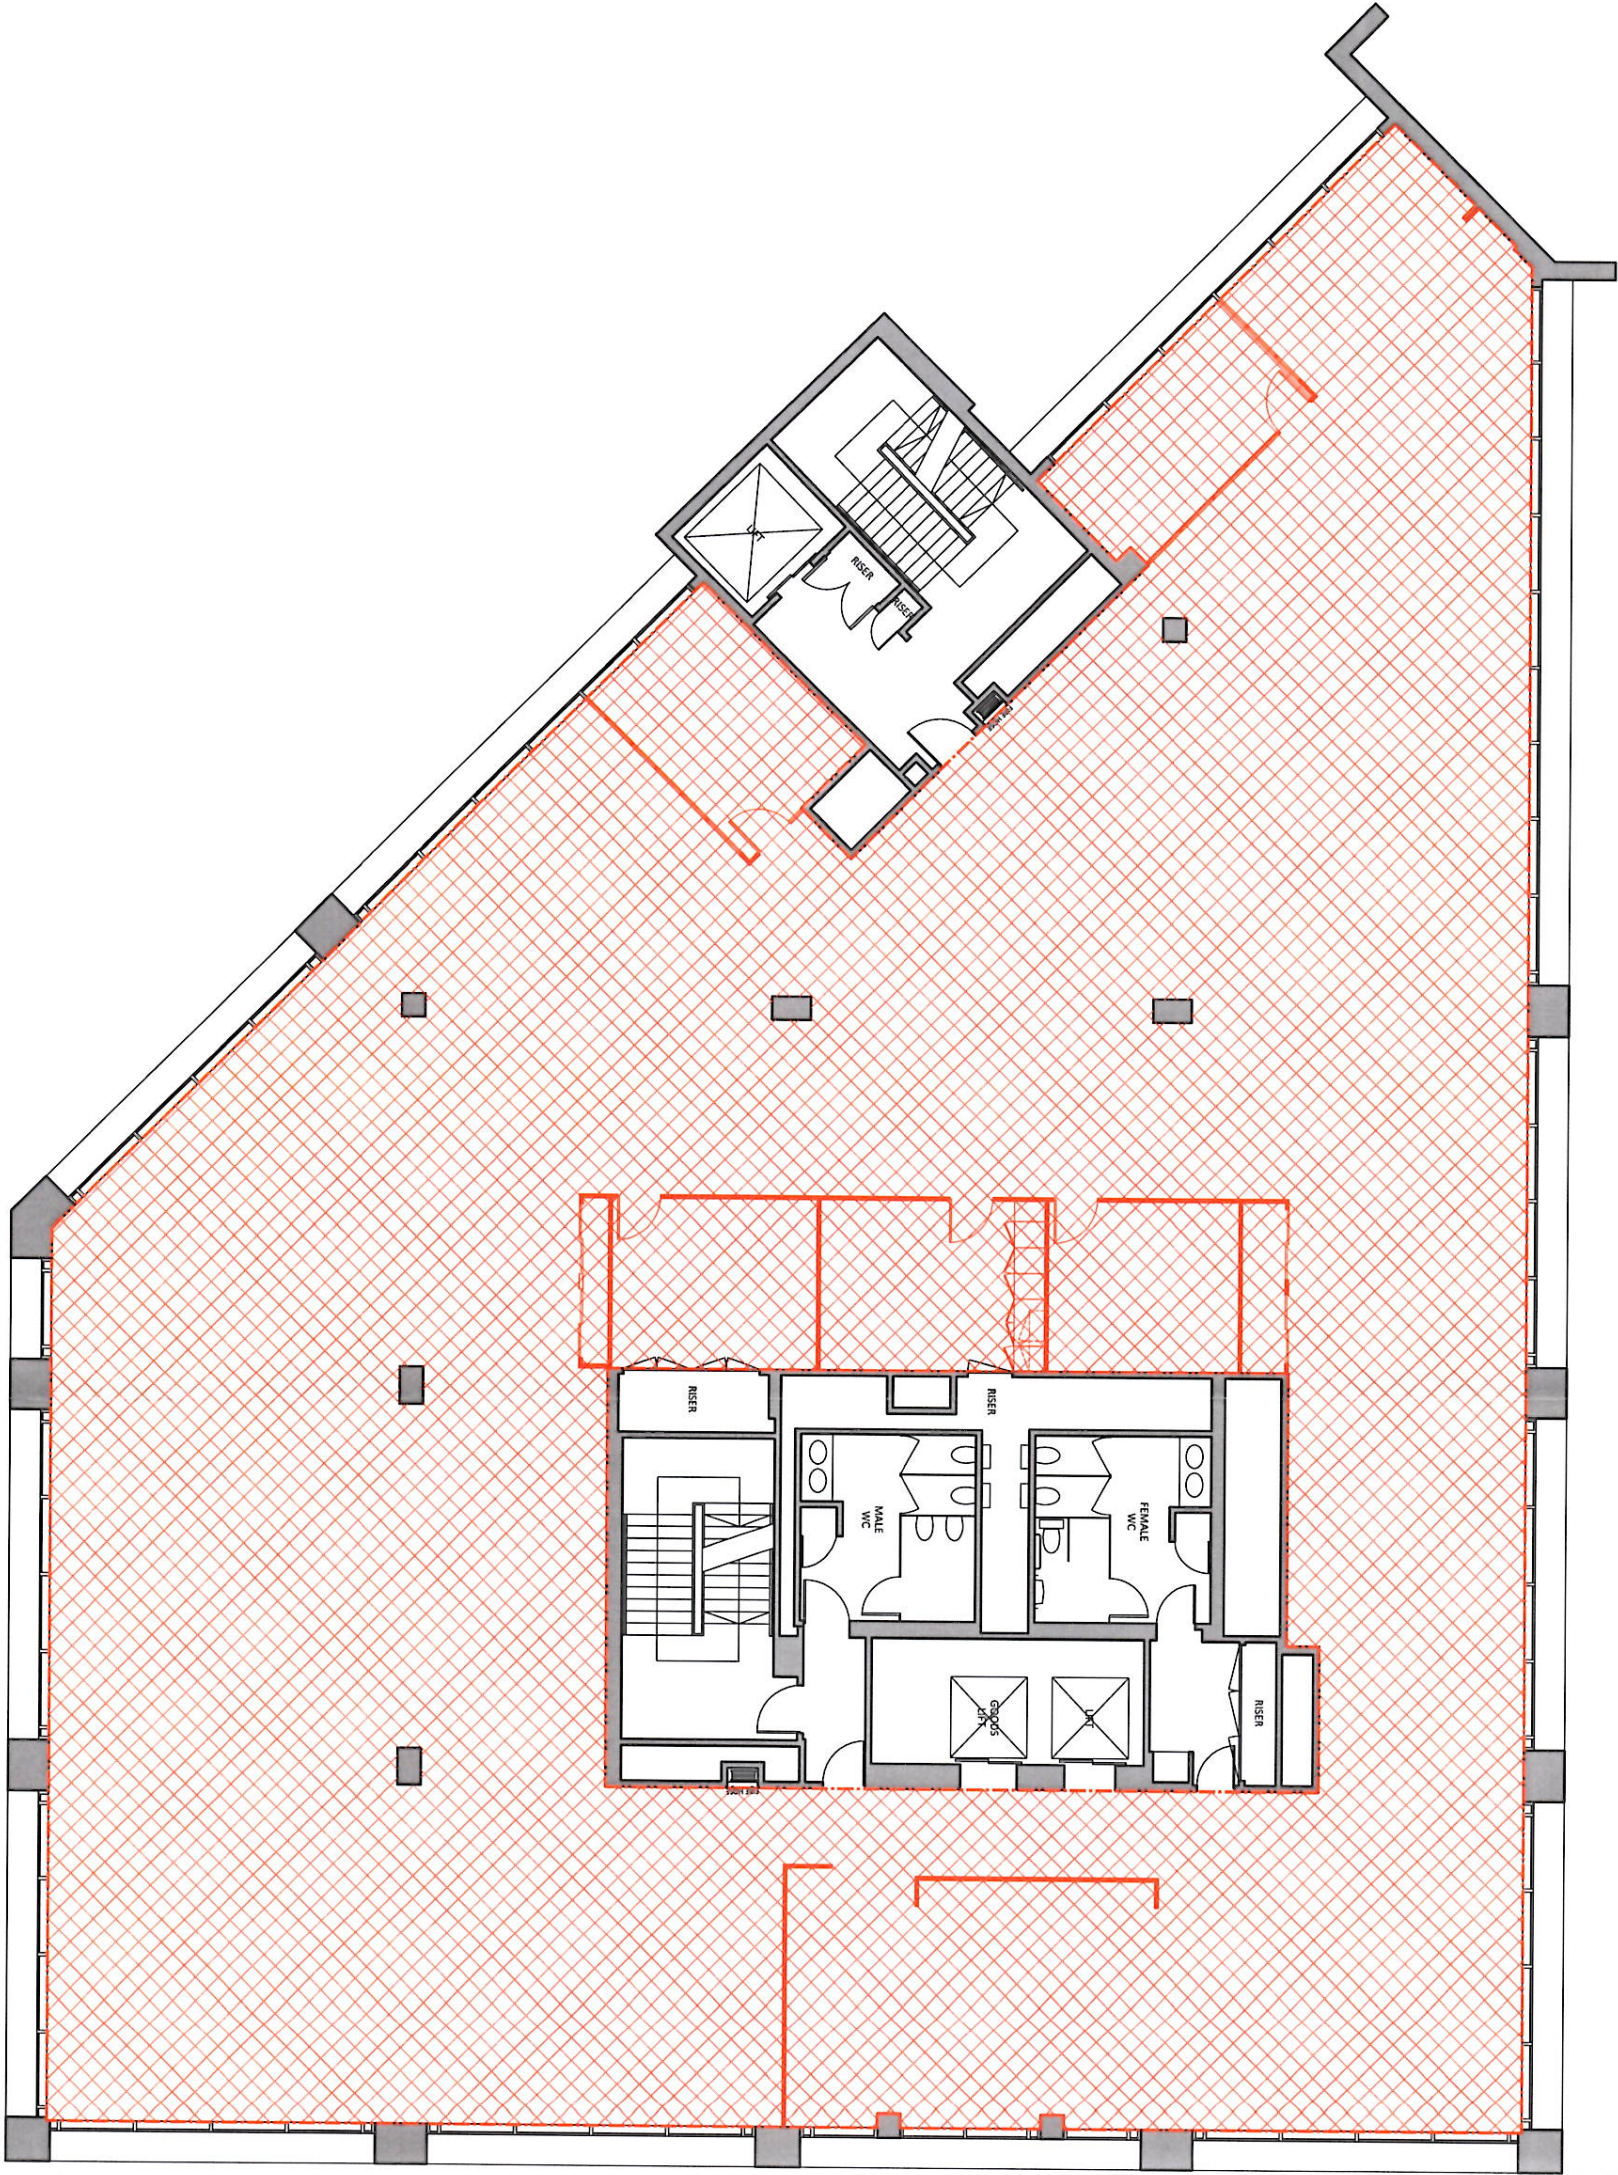

STRIP OUT



1. STRIP OUT EXISTING OFFICE CARPET TO INDICATED
2. STRIP OUT EXISTING PARTITIONS AND DOORS AS INDICATED.
3. STRIP OUT EXISTING WWT AND EXISTING TEA POINT SERVICES INCLUDING DISCONNECTION OF EXISTING SERVICES
4. MAKE SAFE UNWANTED ELECTRICAL INSTALLATIONS
5. PRIOR TO STRIP OUT FLOOR BOARDS TO BE REMOVED


NOTES:

1. No dimensions are to be scaled from this drawing. All dimensions are in millimetres.
2. This drawing is to be read in conjunction with all relevant other drawings, details and specifications.
3. All levels and setting are given in this drawing are to be confirmed as the responsibility of the contractor prior to commencement of the work and any discrepancies forwarded to the project director as a matter of urgency.

Client		Activi Trades	
Project		1 Thomas More Street 1st Floor, Apollo Court London, E1W 1YZ	
Designer		Nicola Plummer	
Project Director		Morne Smit	
Drawing		Strip out Layout	
Title		EC	
Date		28.09.2011	
Project		ACT-01 02 00 01 T	



Subsidiary of CCT Group of Companies
100, 101, 102, 999, 1000










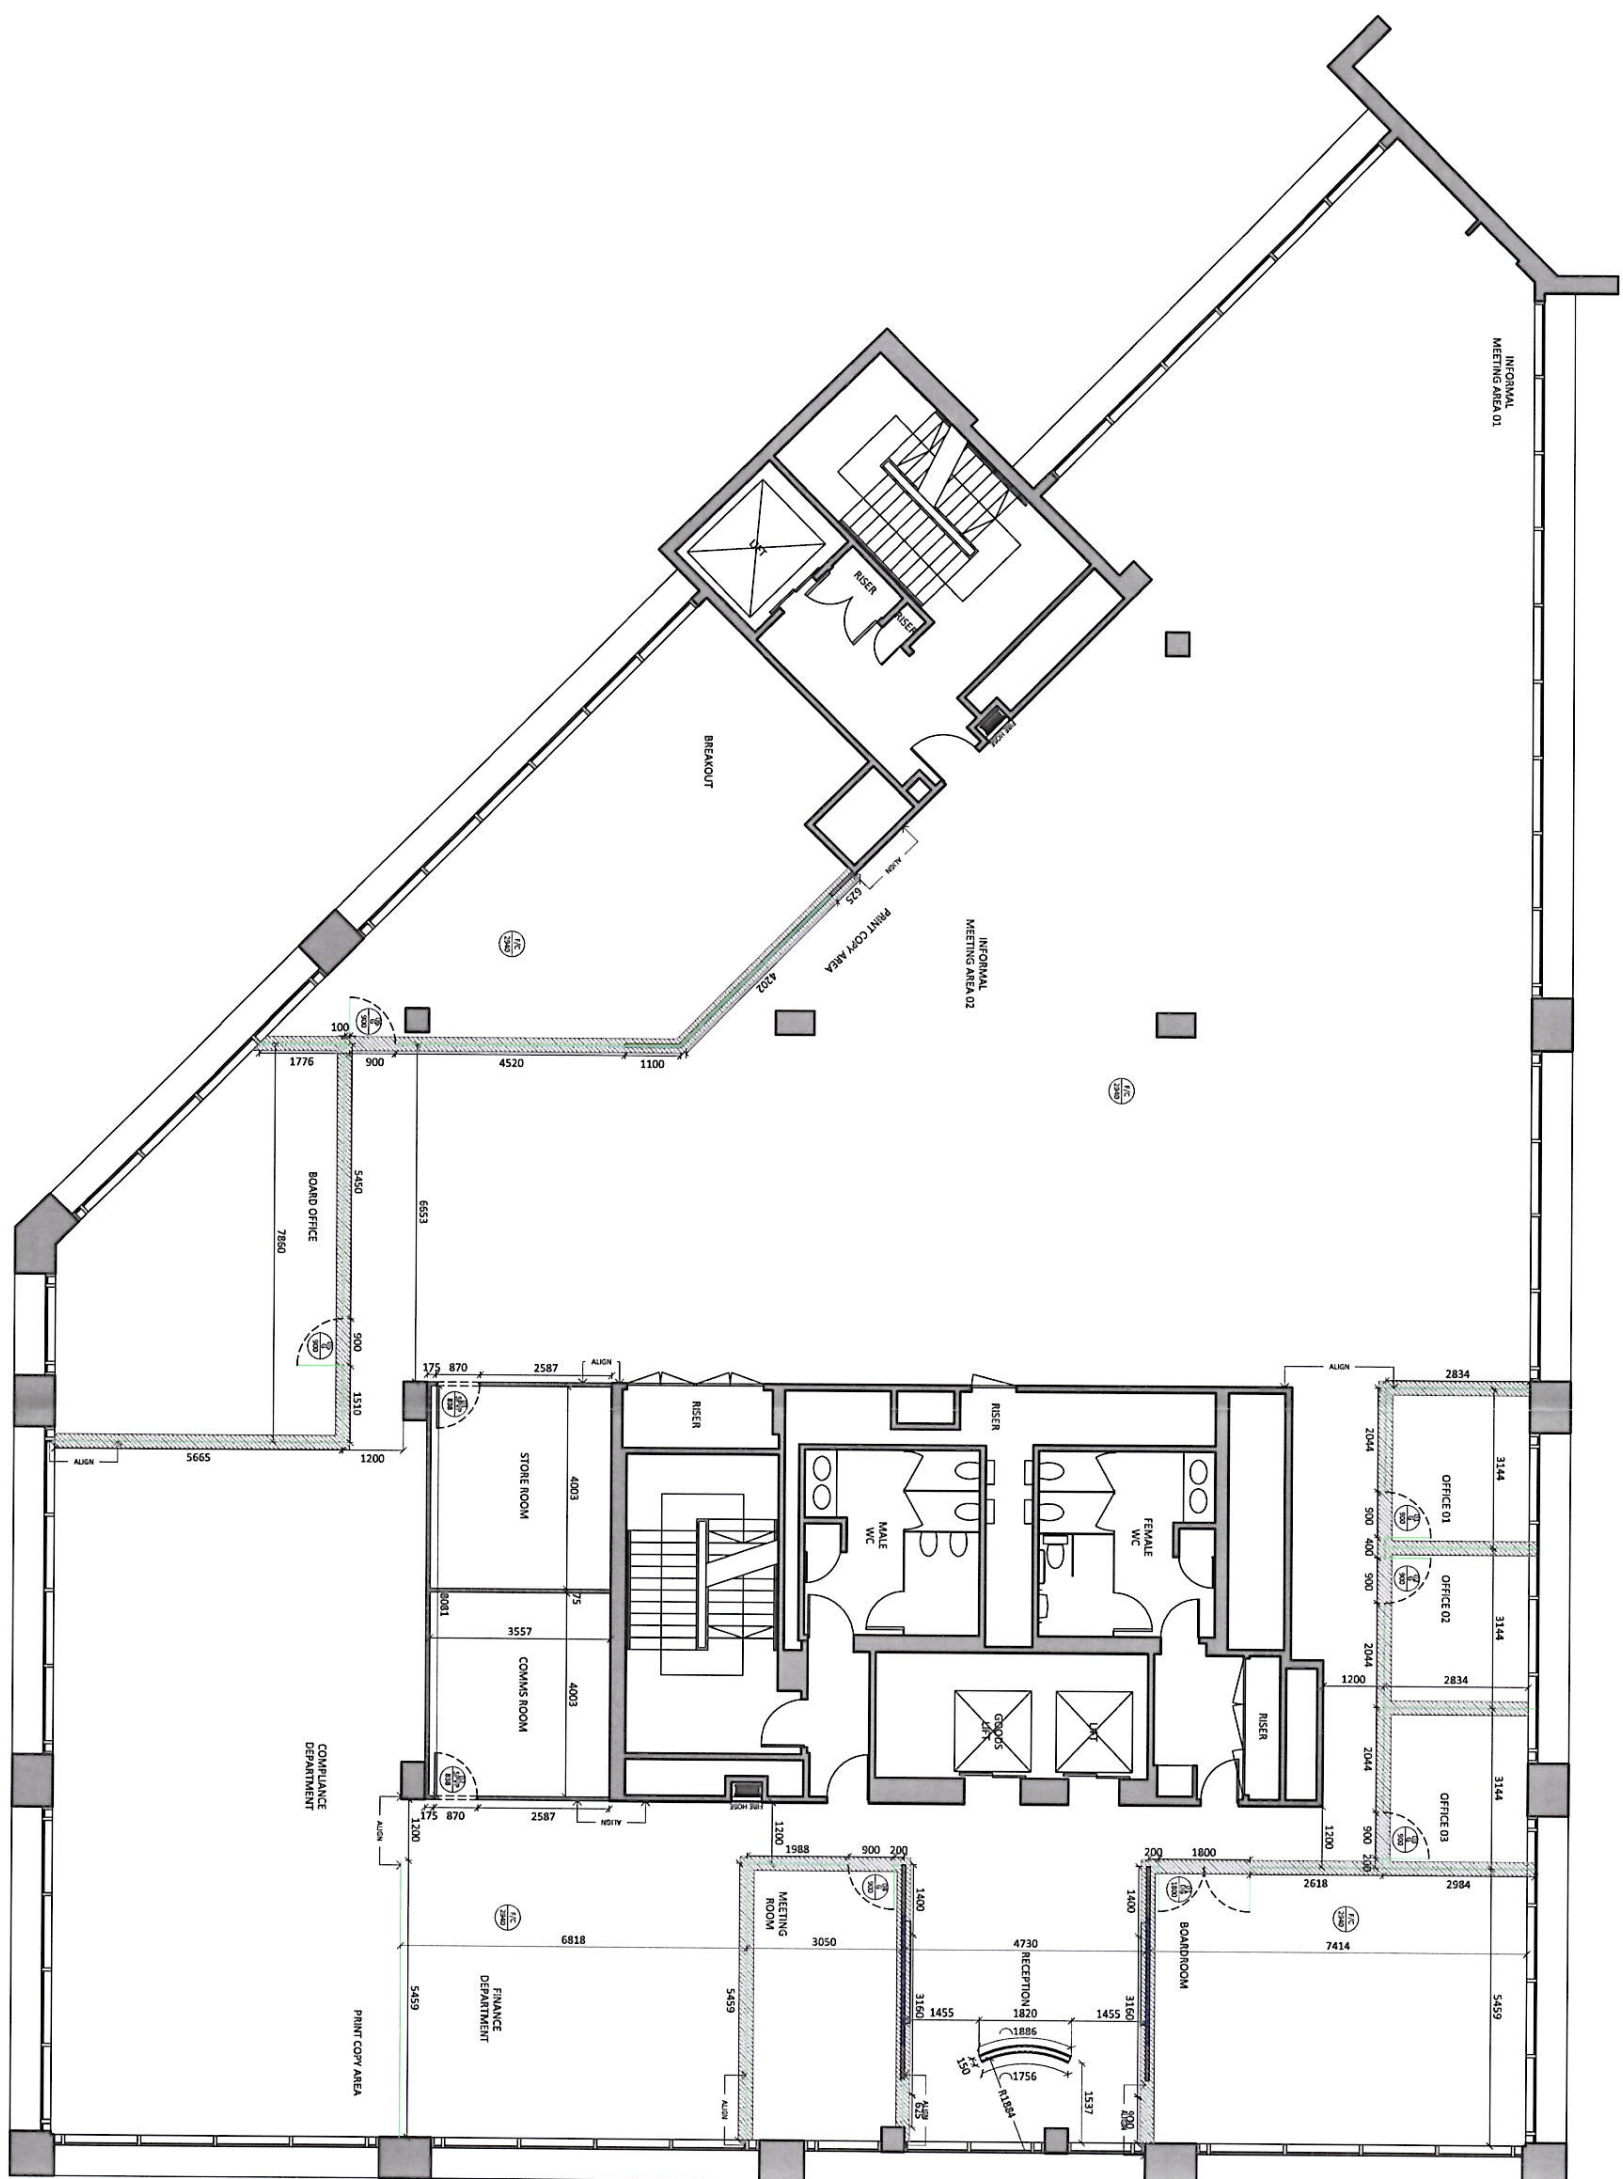


	Notes
ALL PARTITIONS IS ALUMINIUM STUD WITH 12.5mm PLASTERBOARD UNLESS OTHERWISE STATED	- No dimensions are to be scaled from this drawing. All dimensions are in millimetres. - This drawing is to be used in conjunction with all relevant other drawings, details and specifications. - All levels and setting out given on this drawing are to be confirmed on site by the contractor prior to commencement of the works and any discrepancies identified are to be reported immediately to the project director as a matter of urgency.




Client	Active Trades	Project	1 Thomas More Street 1st Floor, Apollo Court London, E1W 1YZ	Designer	Nicola Plummer	Project Director	Morne Smit	Drawings	Partition layout
ISO: DAD P: EN3 Architect: 11, THE OVAL, 42, MILLBURN, 55, GERRARD SQUARE, L20 7JH A2  53 15 15 15 00 00 1,000 02 1,100									
Date	28.09.2011	Drawn	EC						
Project	ACT-01	Status	03	Est	00	Level	01	Design	T

Notes

1. No dimensions are to be scaled from the drawing. All dimensions are in millimetres.
2. This drawing is to be read in conjunction with all relevant other drawings, details and specifications.
3. All levels and setting out given on this drawing are to be confirmed on site by the contractor prior to commencement of the works and any discrepancies forwarded to the project director as a matter of urgency.

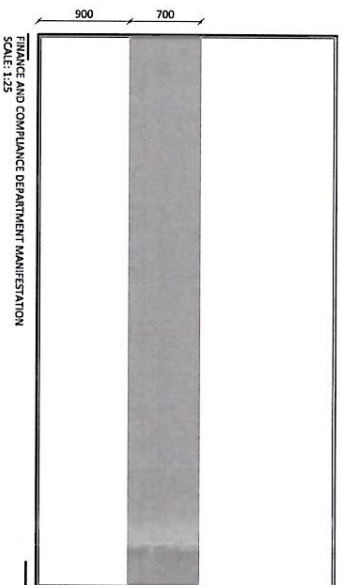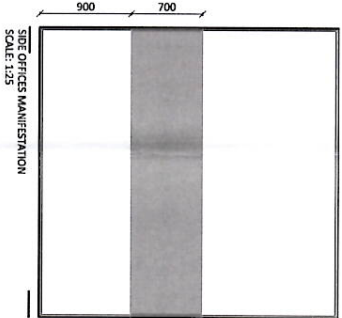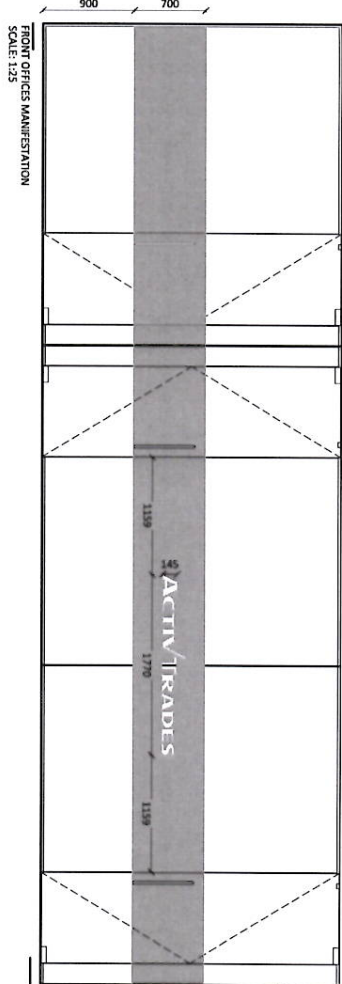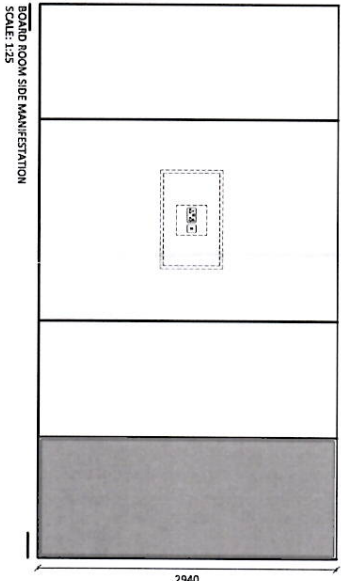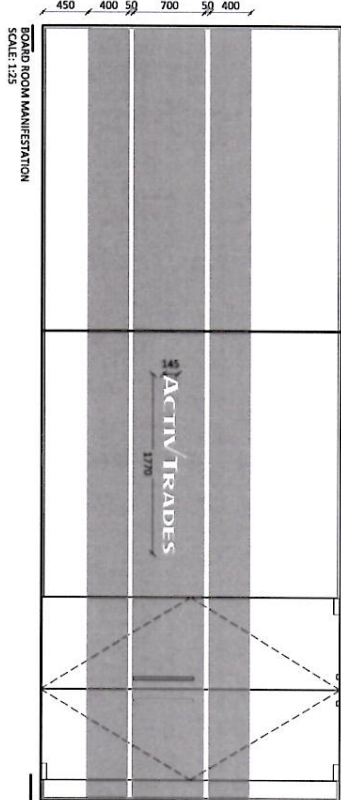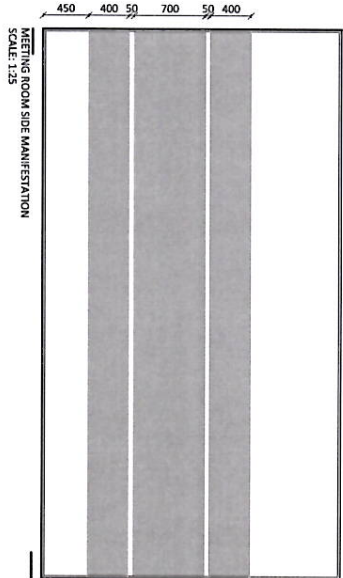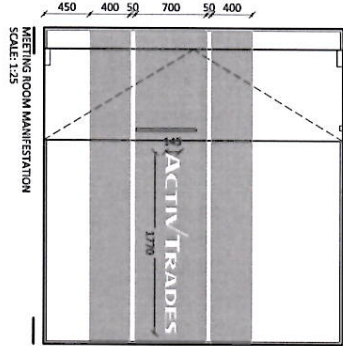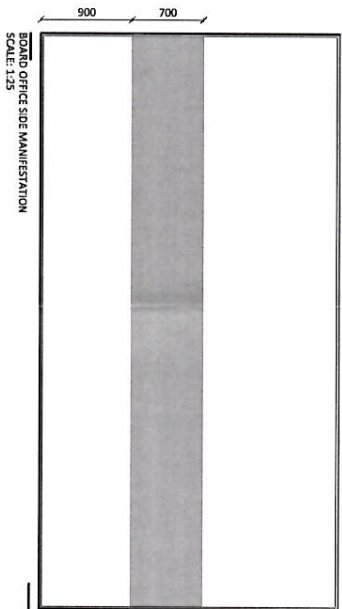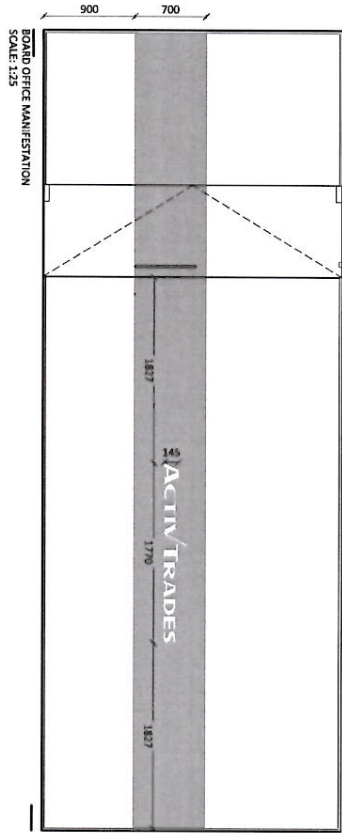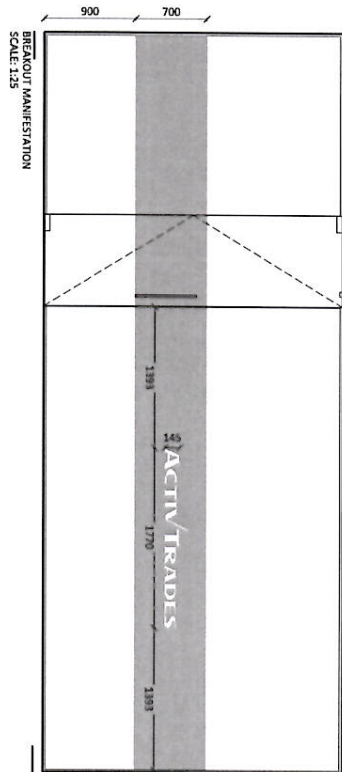

Client		Active Trades	
Project		1 Thomas More Street 1st Floor, Apollo Court London, E1W 1YZ	
Designer		Nicola Plummer	
Project Director		Morre Smit	
Drawings		Partition Details Manifestations	
Technical File No.		TMO-CAO-5-LEN0	
Active Trades - CA - TMO-CAO - A2 - 2011.09.16.dwg		11.02.2011	
Layer size		A2	
Scale		1:50	
Date		28.09.2011	
EC		EC	
Project		ACT-01	
Scale		03	
Rev		01	
Date		01	
T		1	

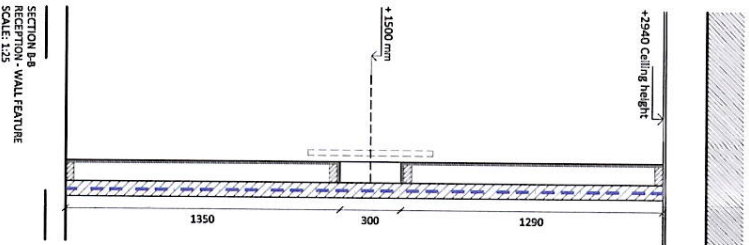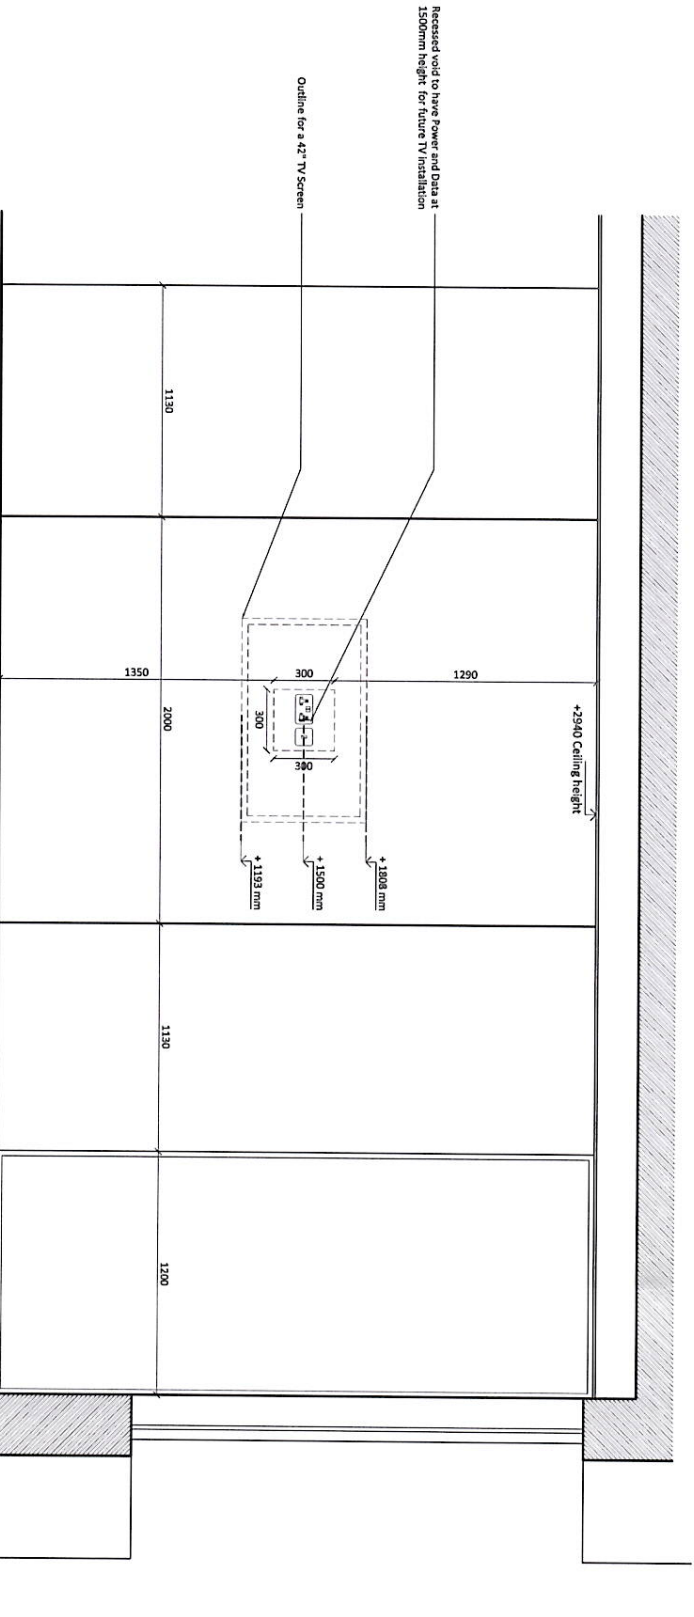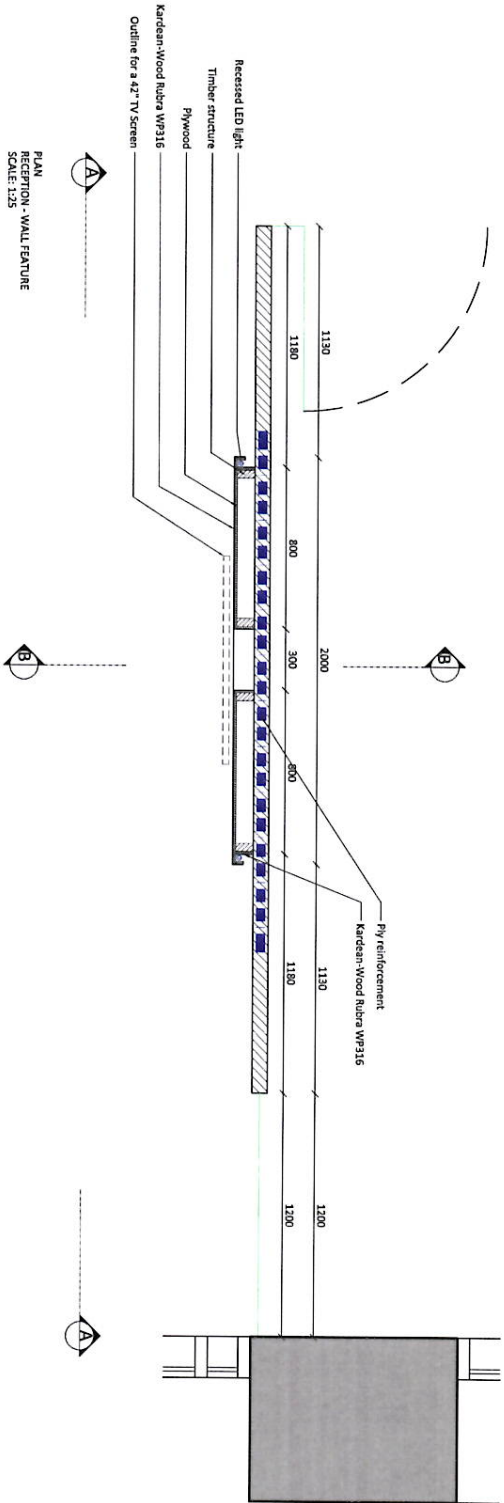


- Notes
1. All dimensions are to be read from the drawing. All dimensions are in millimetres.
 2. This drawing is to be read in conjunction with all relevant other drawings, details and specifications.
 3. All notes and setting out given on this drawing are to be confirmed on site by the contractor and approved in writing by the project director as a matter of urgency.

Rev	Description	Drawn	Date
-----	-------------	-------	------



WWW.CCTINTERIORS.COM
Schofield House, Unit 3, 54 Regent Street, London, W1F 7TE
Tel: 020 7460 9711 Fax: 020 7460 9712

Client	Activi Trades
Project	1 Thomas More Street 1st Floor, Apollo Court London, E1W 1YZ
Designer	Nicola Plummer
Project Director	Morne Smit
Drawing	Partition Details Wall Feature Details
TEC/DWG FILE NO	
ACTIV TRADES - 01 - TECH/DWG - 20110925.dwg - cctg.com-11.01.2011	
Layer size	0.5 1 1.5
Scale	1:50 0:0 1:50
ECN	28.09.2011
EC	EC
Project	ACT-01 03 02 01 T

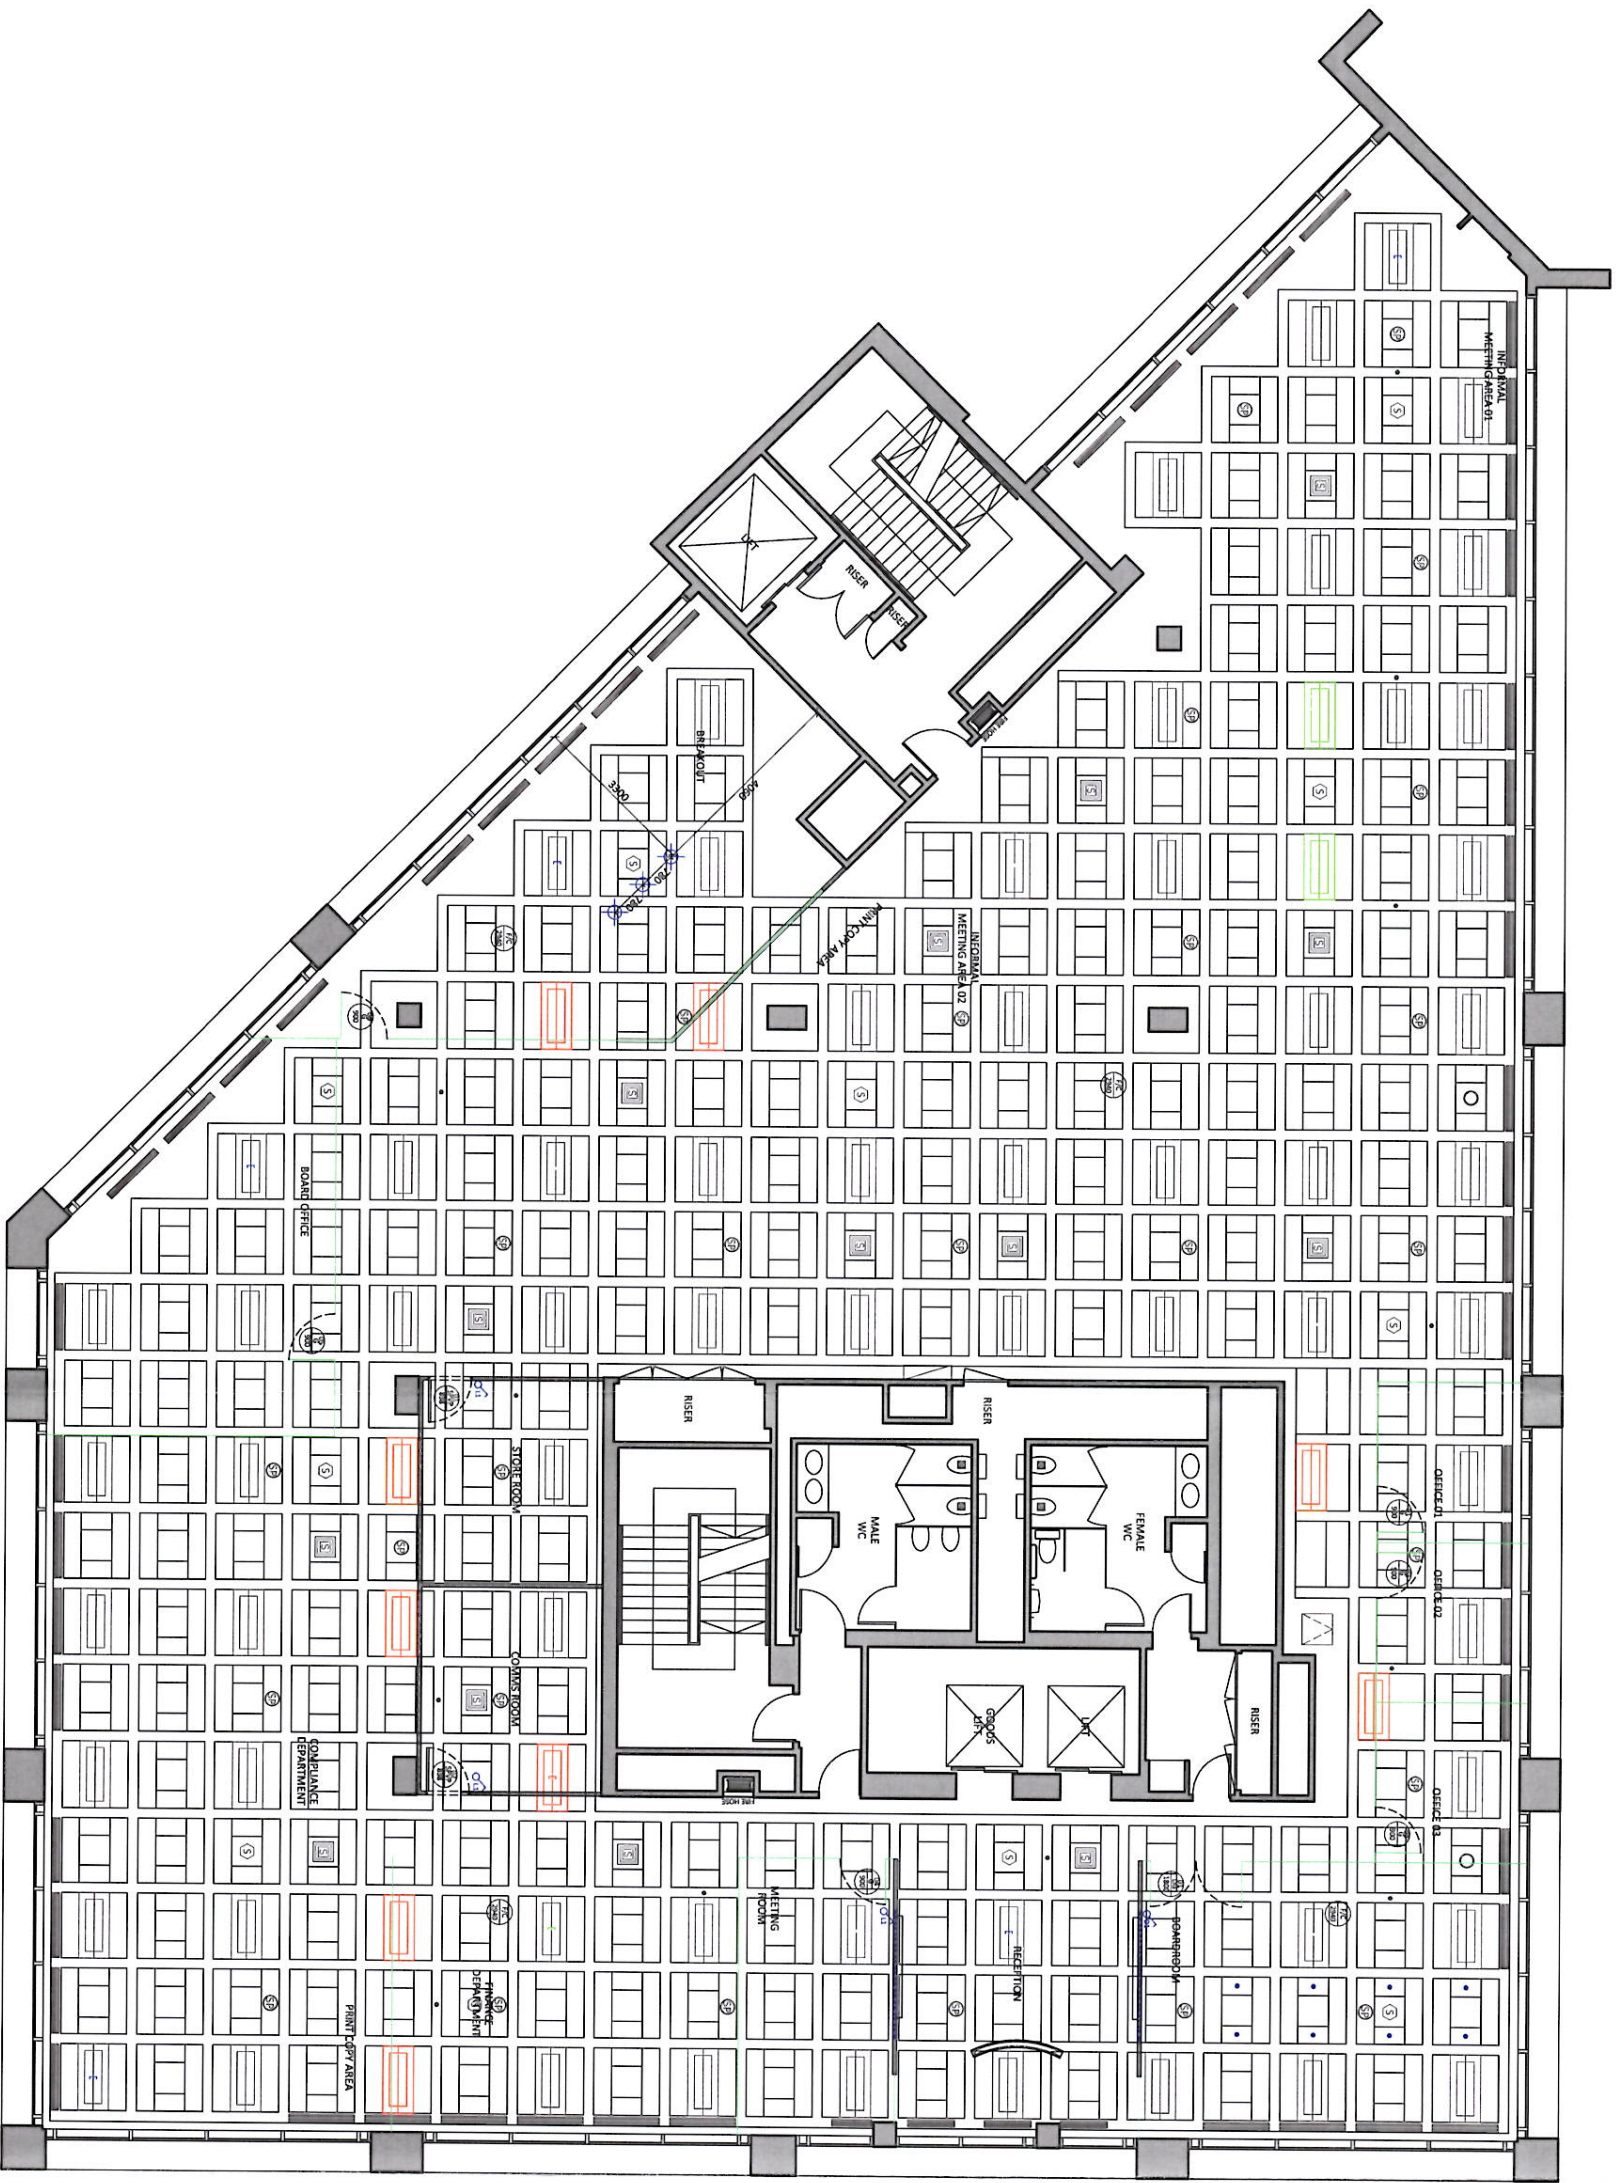

LIGHTING	
	CASSETTE LIGHT - CEILING MOUNTED
	PENDANT LIGHT
	HALOGEN LIGHT
	EMERGENCY LIGHT - REMOVABLE EMERGENCY LIGHT
	LIGHT SWITCH - HALLWAY MOUNTED
	DIMMER SWITCH - HALLWAY MOUNTED
AIR CONDITIONING	
	A/C SUPPLY AIR LOCATION
	A/C SPLIT LEVEL WALL MOUNTED UNIT
	ACCESS PANEL 600 x 600
FIRE DETECTION	
	SMOKE DETECTOR - CEILING MOUNTED
	PIR SENSOR - CEILING MOUNTED
	SPEAKER - CEILING MOUNTED
	CCTV - CEILING MOUNTED
COLOUR CODE	
	RELOCATE
	REMOVE
	NEW
	KEEP EXISTING

- Notes
- No dimensions are to be scaled from this drawing. All dimensions are in millimetres.
 - This drawing is to be read in conjunction with all relevant other drawings, details and specifications.
 - All levels and setting out given on this drawing are to be confirmed on site by the contractor prior to commencement of the works and any discrepancies forwarded to the project director as a matter of urgency.

Rev

Description

Drawn

Date

29.09.2011

EC

Project

Client

Design

Project Director

Drawn

ACT-01

Active Trades

Nicola Plummer

Morne Smit

Reflected Ceiling Plan

1 Thomas More Street
1st Floor, Apollo Court
London, E1W 1YZ

21.09.2011

1:100

29.09.2011

EC


www.cctinteriors.com

Tel: +44 (0) 20 731 2011 Fax: +44 (0) 20 731 2022

1 Thomas More Street
1st Floor, Apollo Court
London, E1W 1YZ

21.09.2011

1:100

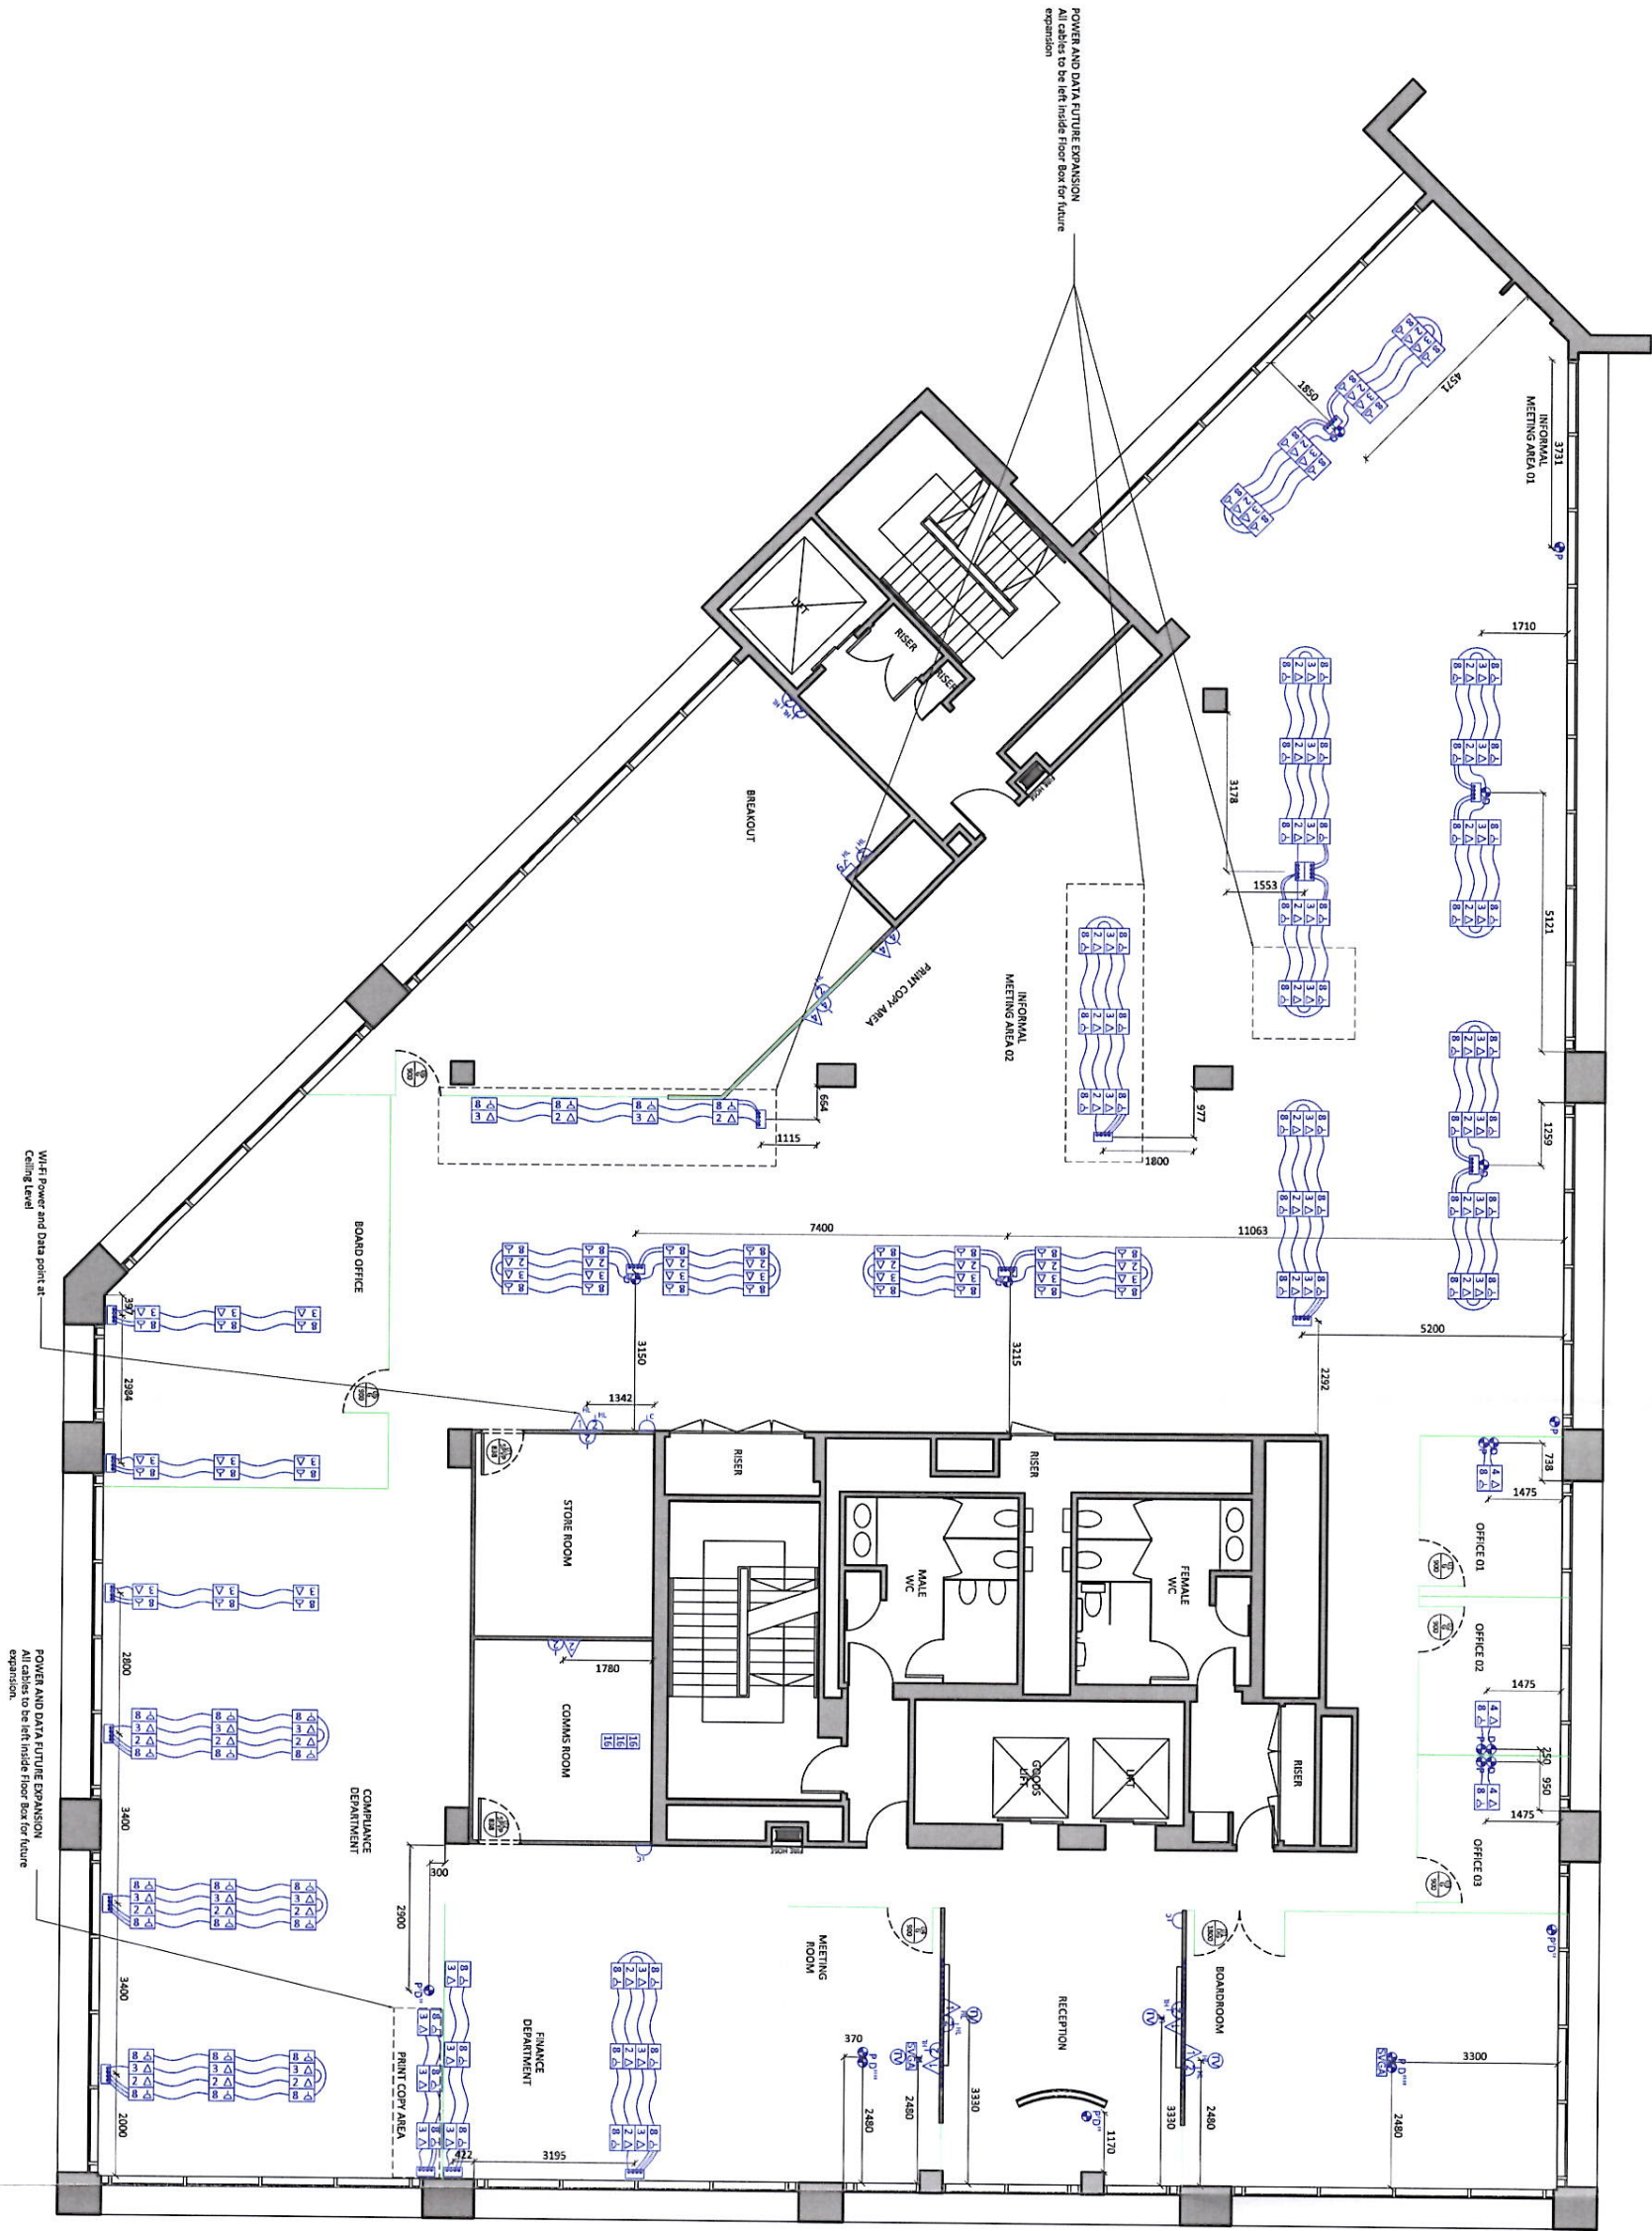

POWER - DATA - AV

	MULTIPLE SWITCHED SOCKET - NUMBER INDICATES AMOUNT
	MULTIPLE SWITCHED SOCKET HIGH LEVEL - NUMBER INDICATES AMOUNT
	SINGLE CLEANERS SOCKET
	MULTIPLE CLEANERS SOCKET
	MULTIPLE DATA POINT SOCKET HIGH LEVEL - NUMBER INDICATES AMOUNT
	UNDER DESK MODULE
	UNDER DESK MODULE
	UNDER DESK MODULE
	FLOOR BOX
	RECTANGULAR FLOOR GROMMET
	FLOOR GROMMET
	FLOOR GROMMET
	FLOOR LEVEL FUSE
	FUSE SPUR
	SIGA Connection
	AERIAL Connection
	16 AMP ELECTRICAL SUPPLY

- Notes
- No dimensions are to be scaled from this drawing. All dimensions are in millimetres.
 - This drawing is to be read in conjunction with all relevant other drawings, details and specifications.
 - All levels and heights are given on this drawing to be confirmed on site by the contractor prior to commencement of the works and any discrepancies forwarded to the project director as a matter of urgency.
 - In order to comply with BS 7671:2018:
 - 4.1 All low level sockets will be located 500mm high from finished floor level.
 - 4.2 All high level sockets will be located 1100mm high from finished floor level.
 - 4.3 All low level sockets will be located 150mm above wall top level (refer to wall drawing for accurate height).

WWW.CCTINTERIORS.COM

Scheduled Hours: Mon 9.30 - 5.45, Tues 9.30 - 5.45, Wed 9.30 - 5.45, Thurs 9.30 - 5.45, Fri 9.30 - 5.45, Sat 9.30 - 5.45, Sun 9.30 - 5.45

Rev Description Drawn Date

10	16 AMP ELECTRICAL SUPPLY		
09	AERIAL Connection		
08	SIGA Connection		
07	FUSE SPUR		
06	FLOOR LEVEL FUSE		
05	FLOOR GROMMET		
04	FLOOR GROMMET		
03	RECTANGULAR FLOOR GROMMET		
02	FLOOR BOX		
01	UNDER DESK MODULE		
00	UNDER DESK MODULE		
99	MULTIPLE CLEANERS SOCKET		
98	SINGLE CLEANERS SOCKET		
97	MULTIPLE SWITCHED SOCKET HIGH LEVEL		
96	MULTIPLE SWITCHED SOCKET		

Client: Activi Trades

Project: 1 Thomas More Street, 1st Floor, Apollo Court, London, E1W 1YZ

Designer: Nicola Plummer


Project Director: Morne Smit

Drawing: Power & Data Layout

Date: 28.09.2011

Scale: 1:100

EC

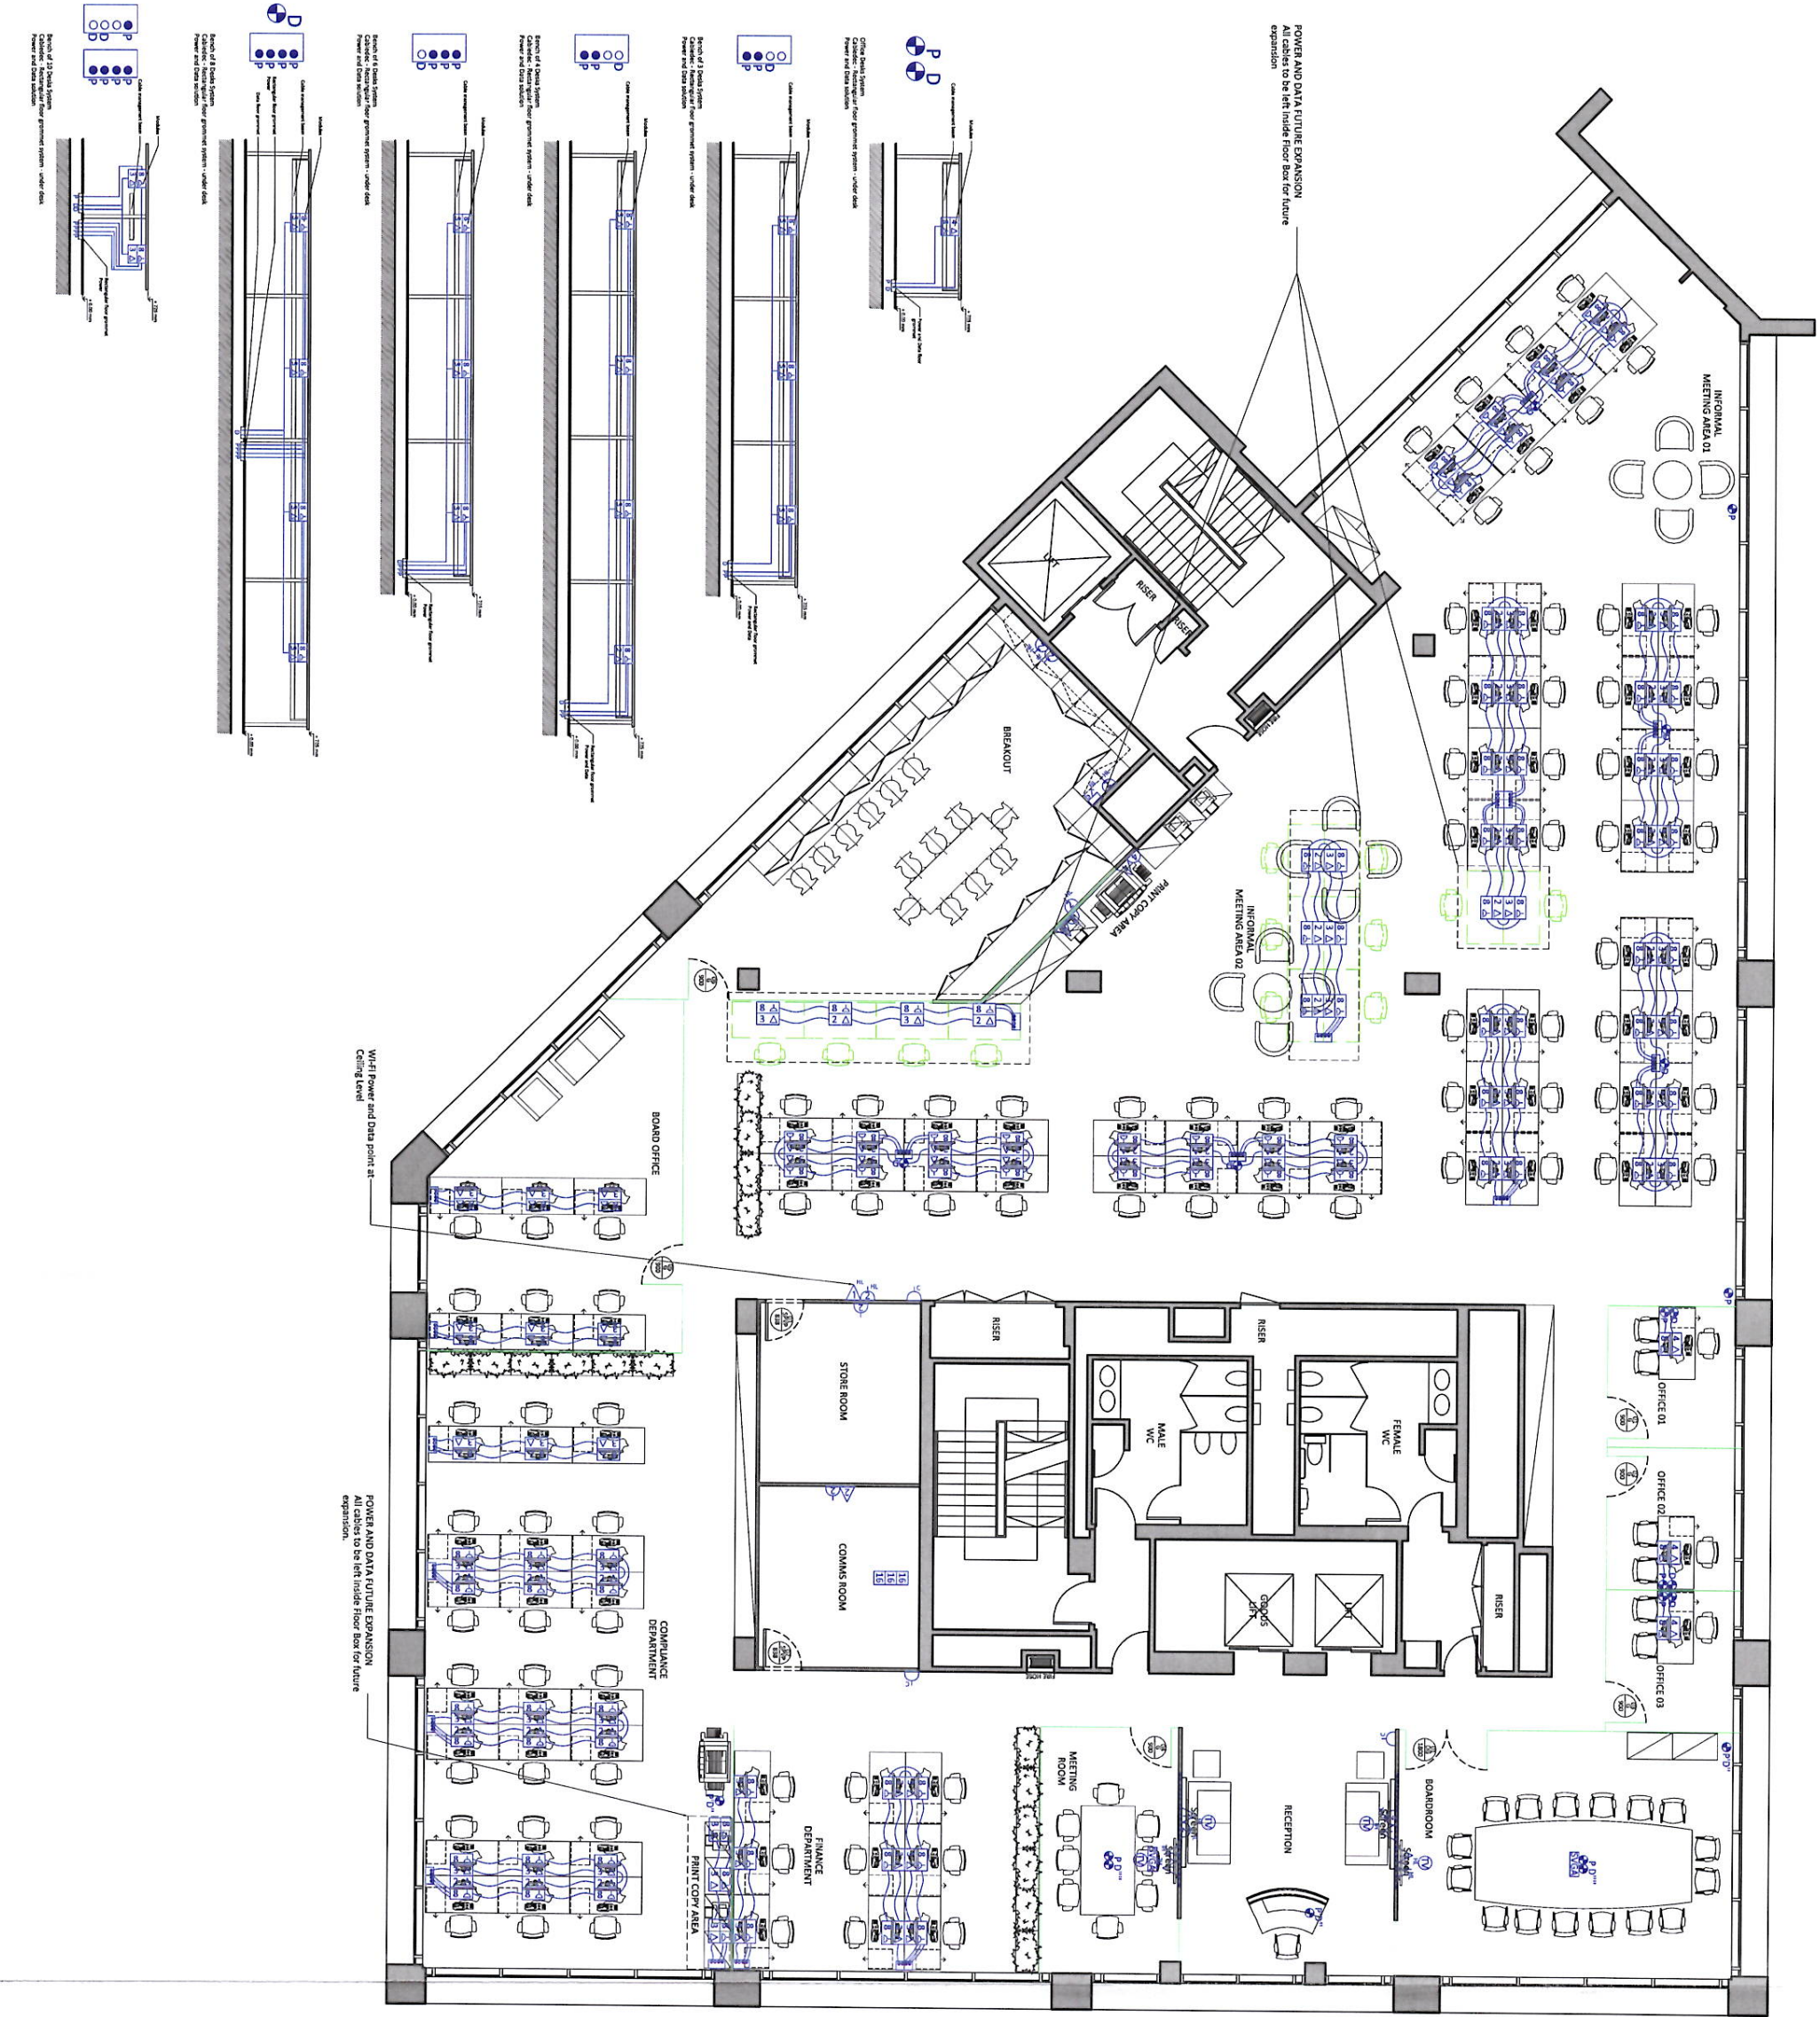

POWER - DATA - AV

	MULTIPLE SWITCHED SOCKET - NUMBER INDICATES AMOUNT
	MULTIPLE SWITCHED SOCKET HIGH LEVEL - NUMBER INDICATES AMOUNT
	SINGLE CLEANERS SOCKET
	MULTIPLE CLEANERS SOCKET
	MULTIPLE CAT5 POINT - NUMBER INDICATES AMOUNT
	UNDER DESK MODULE - 2-PORTER
	UNDER DESK MODULE - 12VKA
	FLOOR BOX - 2-PORTER - 12VKA
	RECTANGULAR FLOOR GROMMET - POWER - DATA
	FLOOR GROMMET - DATA
	FLOOR GROMMET - POWER
	HIGH LEVEL RISE SIGN - NUMBER INDICATES AMOUNT
	FUSE SPUR - NUMBER INDICATES AMOUNT
	SIGNAL CONNECTION
	AERIAL CONNECTION
	16 AMP ELECTRICAL SUPPLY

	COLOR CODE
	FUTURE FUTURE EXPANSION

- Notes
- No dimensions are to be scaled from this drawing. All dimensions are in millimeters.
 - This drawing is to be read in conjunction with all relevant other drawings, details and specifications.
 - All levels and setting out given on this drawing are to be confirmed on site by the contractor prior to commencement of the works and any discrepancies forwarded to the project director as a matter of urgency.
 - In order to comply with PART M document:
 - 4A Allow hand holds on stairs, will be located 500mm high from finished floor level.
 - 4B All hand holds will be located at 1100mm high from finished floor level.
 - 4C Hand holds on stairs will be located 100mm above work top level (refer to Detail Drawing for accurate height).

Client
Activi Trades

Project
1 Thomas More Street
1st Floor, Apollo Court
London, E1W 1YZ

Designer
Nicola Plummer

Project Director
Morne Smit

Drawings
Power & Data + Furniture Layout

28.09.2011

EC

Project: ACT-01

Sheet: 05

Rev: 01

Scale: 1:100


Date: 28.09.2011

Www.CCTINTERIORS.COM

Subsidiary of: CCT GROUP OF COMPANIES LTD

1st Floor, Apollo Court
1 Thomas More Street
London, E1W 1YZ

Tel: +44 (0) 20 3031 201 Fax: +44 (0) 20 3031 202

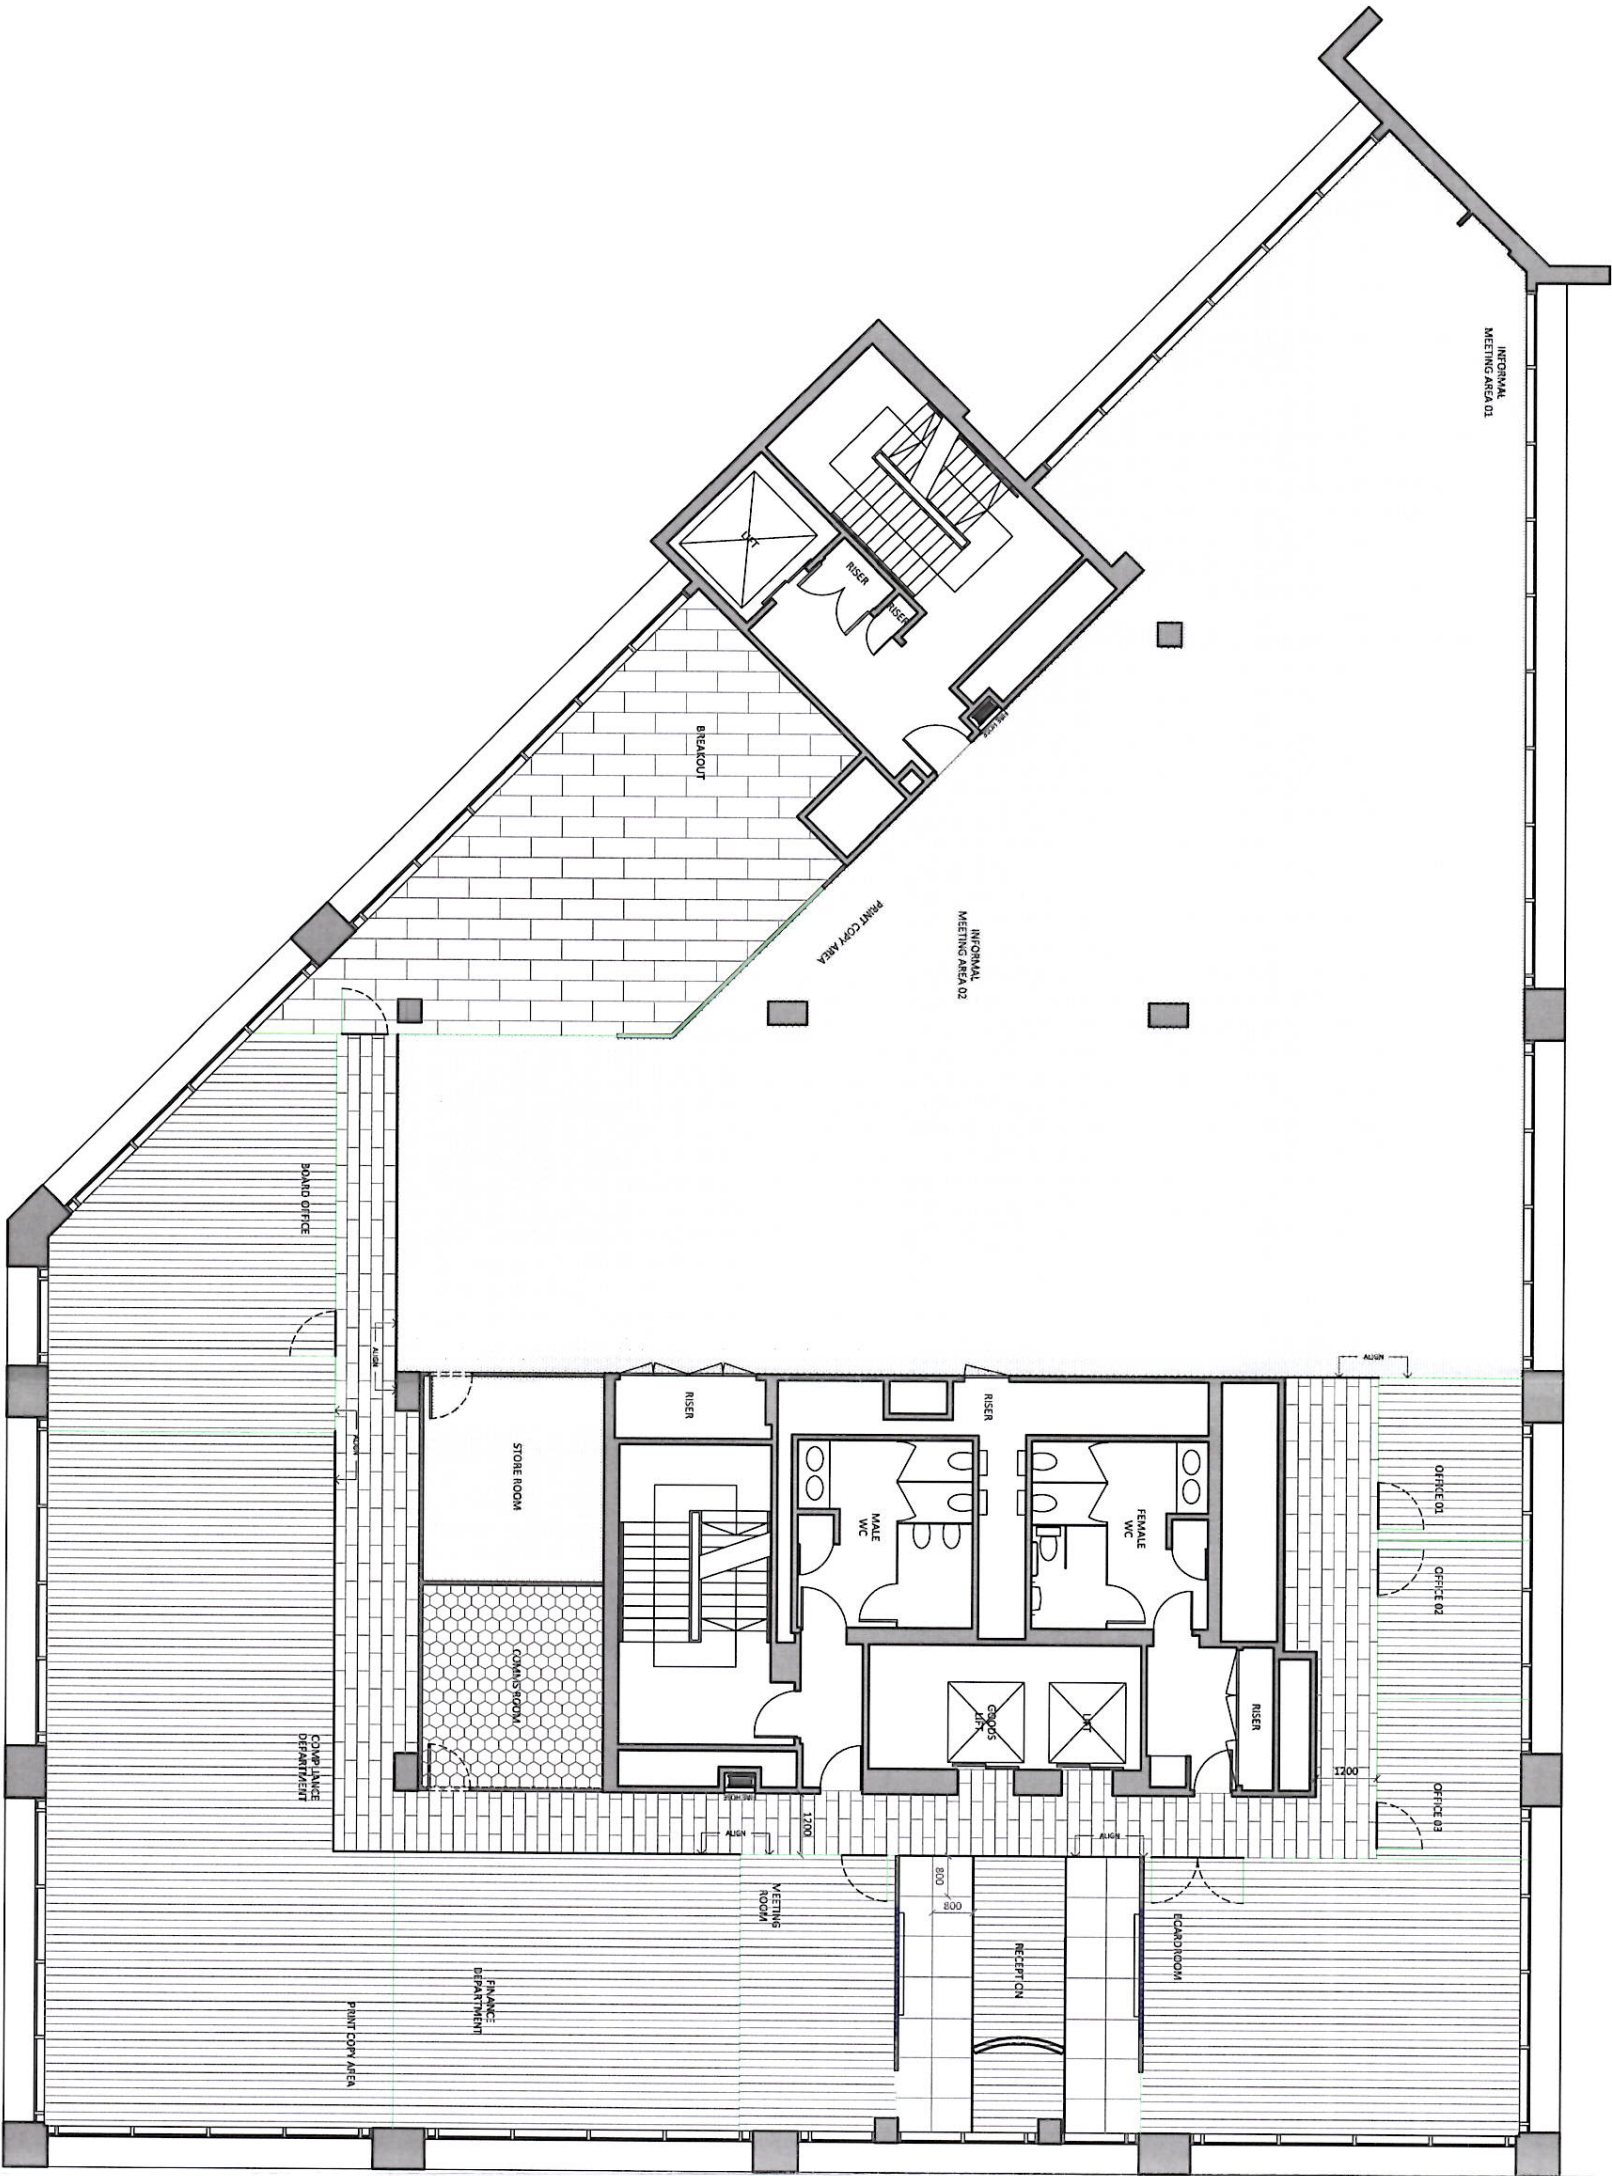

FLOORING	
F1	NEW CARPET MAIN CORRIDOR MODULUS MODULUS E22
F2	NEW CARPET MODULUS MODULUS E22 MODULUS MODULUS E22 MODULUS MODULUS E22
F3	NEW CARPET MODULUS MODULUS E22 MODULUS MODULUS E22
F4	NEW CARPET MODULUS MODULUS E22 MODULUS MODULUS E22
F5	NEW CARPET MODULUS MODULUS E22 MODULUS MODULUS E22
F6	NEW CARPET MODULUS MODULUS E22 MODULUS MODULUS E22

- Notes
- No dimensions are to be scaled from this drawing. All dimensions are in millimetres.
 - This drawing is to be read in conjunction with all relevant other drawings, details and specifications.
 - All levels and setting out given on this drawing are to be confirmed on site by the contractor prior to commencement of the works and any discrepancies forwarded to the project director as a matter of urgency.


Project	
1 Thomas More Street 1st Floor, Apollo Court London, E1W 1YZ	
Design	
Nicola Plummer	
Project Director	
Morne Smit	
Drawings	
Finishes Layout	
Technical Data	
TCO: CAD FILE NO.	
ACTIVITY: 01 - TCO: CAD FILE NO.	
ACTIVITY: 02 - TCO: CAD FILE NO.	
ACTIVITY: 03 - TCO: CAD FILE NO.	
ACTIVITY: 100 - TCO: CAD FILE NO.	



www.cctinteriors.com

Schedule of Works, Level 1, 5, 6, 7, 99, 100

Tel: +44 (0)20 3011 3011 Fax: +44 (0)20 3011 3012

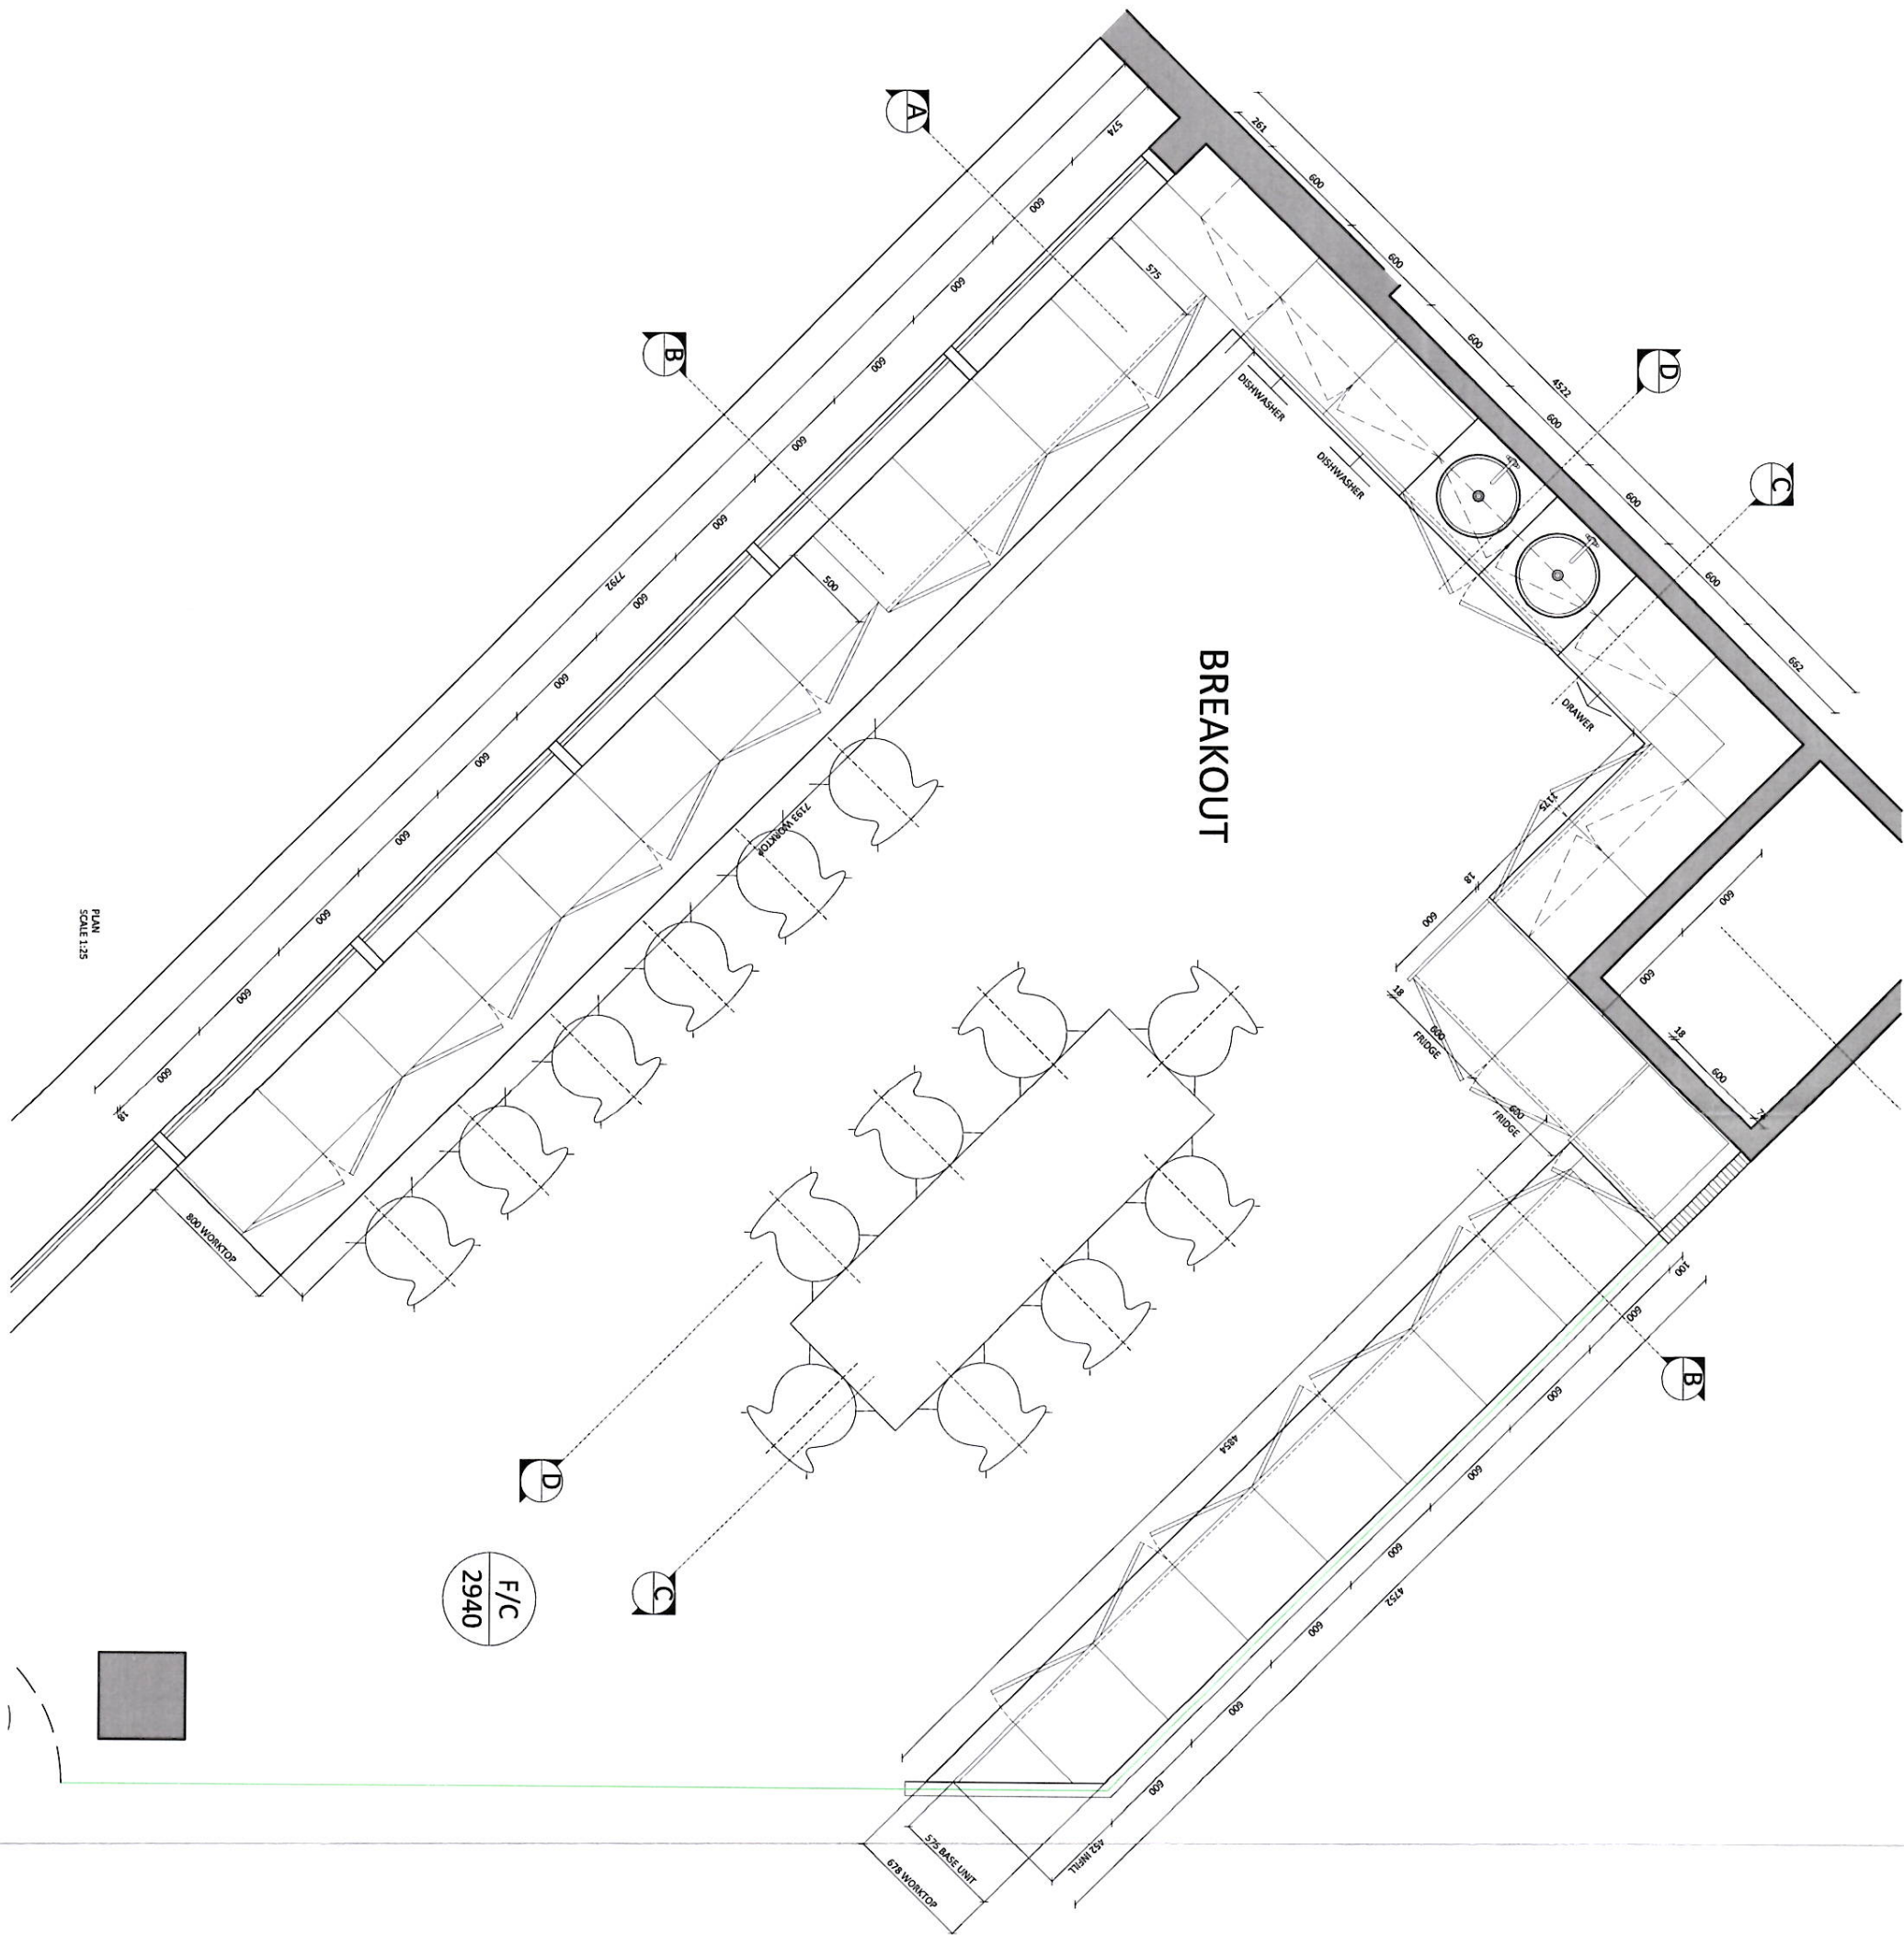


- Notes
1. No dimensions are to be scaled from this drawing. All dimensions are in millimeters.
 2. This drawing is to be read in conjunction with all relevant other drawings, details and specifications.
 3. All levels and setting out given on this drawing are to be confirmed on site by the contractor prior to commencement of the works and any discrepancies forwarded to the project director as a matter of urgency.



www.cctinteriors.com
Surrey House, Level 3, 25 Abchurch Lane, London, WC1N 3HT
Tel: +44 (0) 20 7331 3011 Fax: +44 (0) 20 7331 3022

Rev	Description	Drawn	Date
-----	-------------	-------	------

Client	Active Trades
Project	Site Address London W1
Designer	Nicola Plummer
Project Director	Morne Smit
Drawing	Tea Point Detail
Technical File No.	TECH-210 FILE NO.
Activity Dates	01 - 01 - 2011 to 31 - 03 - 2011
Version	A2
Scale	1:25
Date	28.09.2011
Drawn	EC
Checked	ACT-01
Drawn	07
Check	01
Issue	01
Rev	T


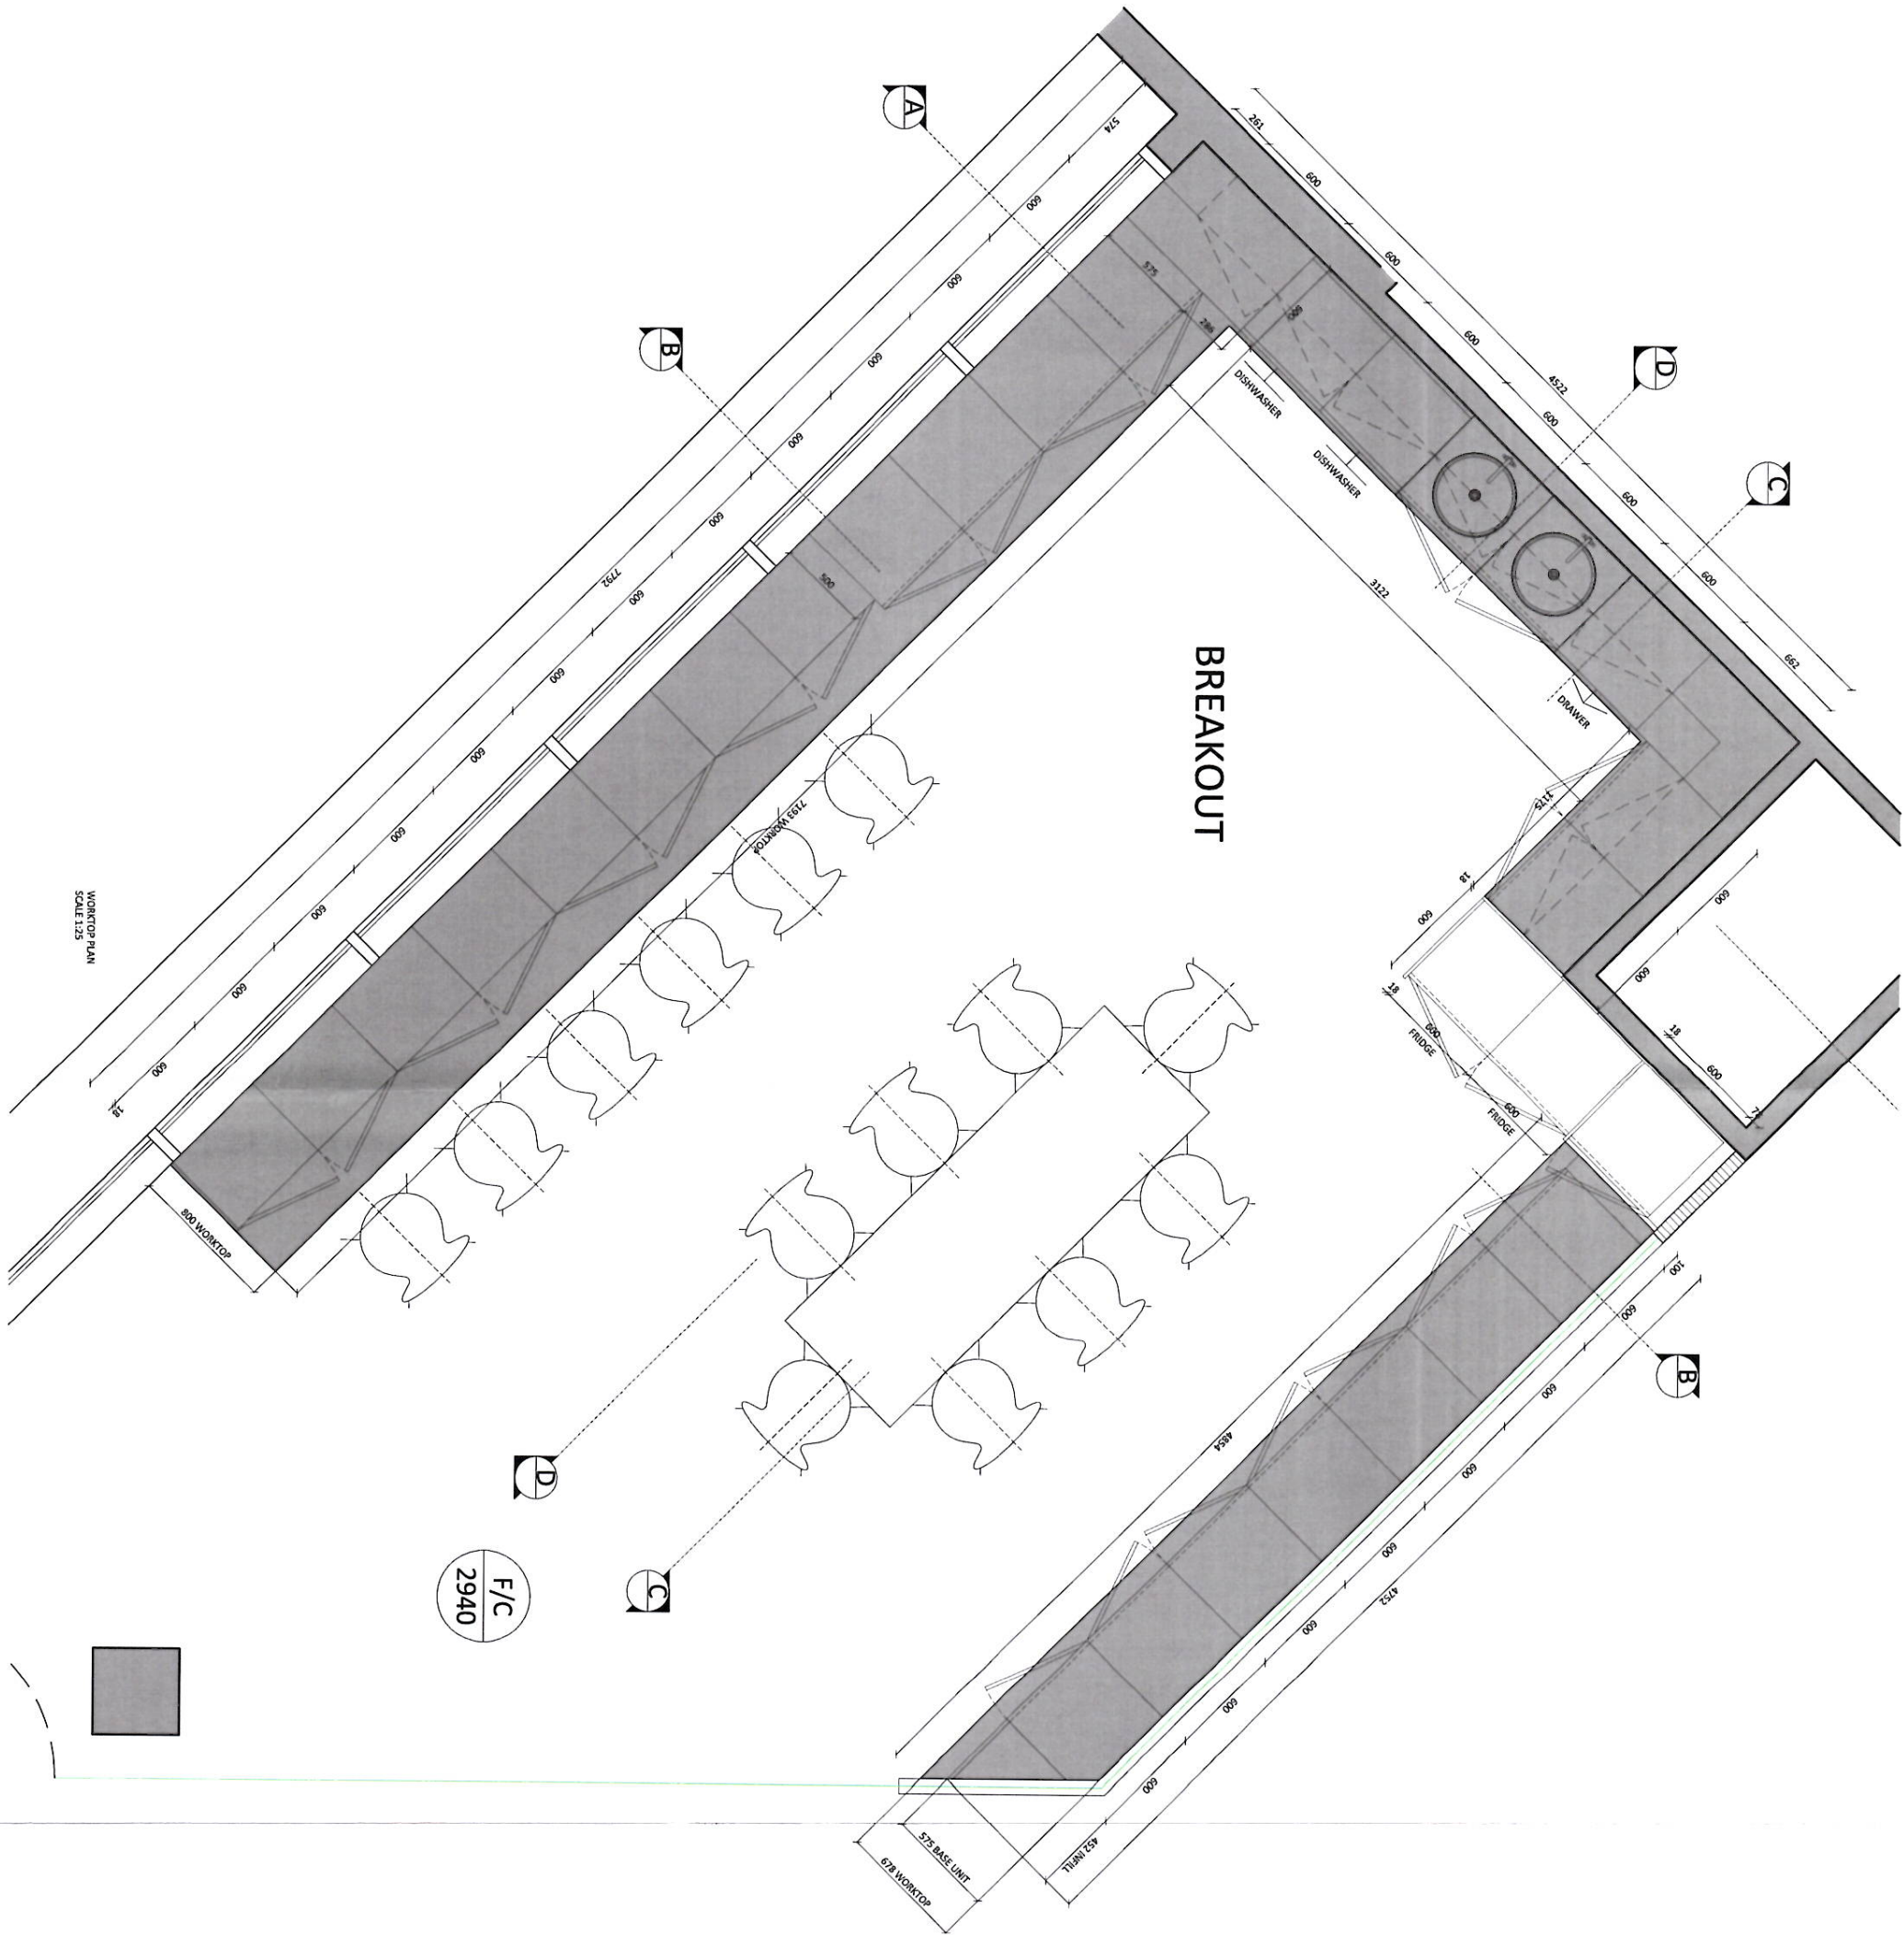


- Notes
1. No dimensions are to be scaled from the drawing. All dimensions are in millimetres.
 2. The drawing is to be used in conjunction with all relevant other drawings, details and specifications.
 3. All levels and heights are given on the drawing and are to be confirmed on site by the contractor prior to commencement of the work. Any discrepancies are to be reported to the project director as a matter of urgency.

Client	Activi Trades
Project	Site Address London W1
Designer	Nicola Plummer
Project Director	Morne Smit
Drawing	Tea Point Detail
Scale	1:25
Date	28.09.2011
Drawn	EC
Project	ACT-01
Rev	07
Ed	02
Level	01
Signature	T



WWW.CCTINTERIORS.COM
Sales: 020 8996 1111 | Fax: 020 8996 1112 | Email: info@cctinteriors.com

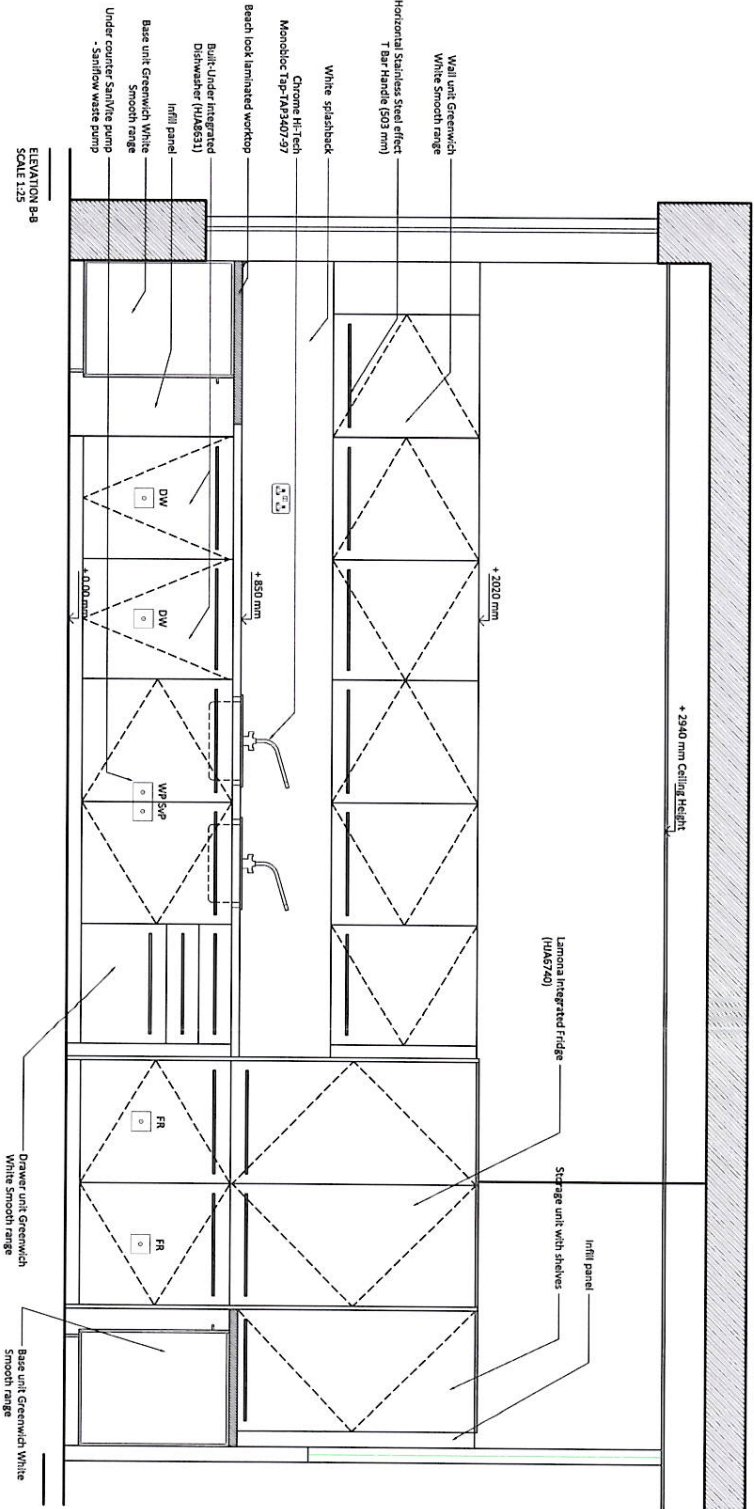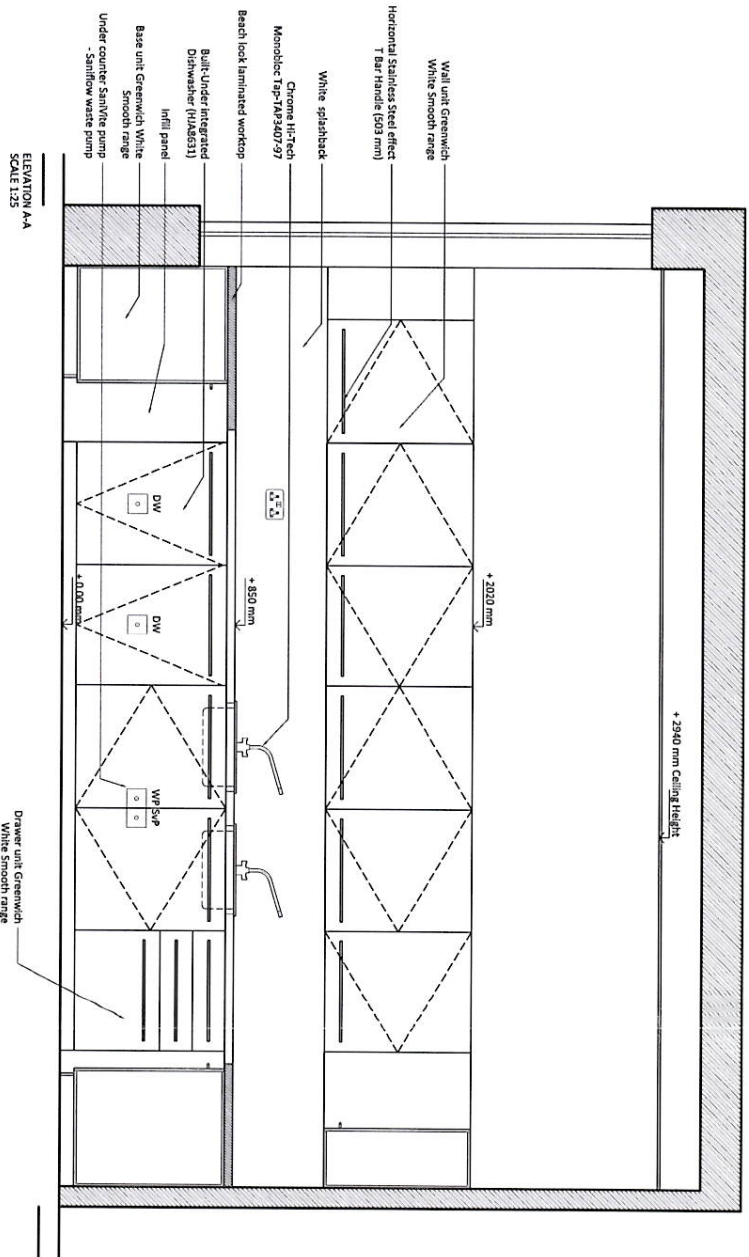

TEA POINT DETAILS	
UNITS	
• Full Height Wall Unit 600mm	15 u.
• Drawer 600mm	1 u.
• Dishwasher unit 600mm	2 u.
• Storage unit 600mm	1 u.
FINISHES	
• Worktop - Beach laminated	2400 mm
• Splashback - White smooth	2400 mm
• Square Corbin	1 u.
• Tiles splashback	sqm.
ACCESSORIES	
• Sink - SAN1420	2 u.
• Tap - TAP3407-97	1 u.
• Hot/Cold Water Hot & Cold Tap	1 u.
• Handled 503mm	41 u.
APPLIANCES	
• Built under Dishwasher - HUA631	2 u.
• Integrated fridge - HUA6740	2 u.
ELECTRICAL	
• Double socket	3 u.
• Fuse spur/utility plate	6 u.
SANITARY	
• Under-counter Saniflow waste pump	1 u.

- No dimensions are to be scaled from this drawing. All dimensions are in millimetres.
- This drawing is to be read in conjunction with all relevant other drawings, details and specifications.
- All levels and setting out given on this drawing are to be confirmed on site by the contractor prior to commencement of the work and any discrepancies forwarded to the project director as a matter of urgency.

Rev	Description	Drawn	Date
-----	-------------	-------	------




Standard House, Level 5, 5-6 Angel Street, London, W1F 7TE
Tel: +44 (0) 20 301 2011 Fax: +44 (0) 20 301 202

Client	Acty Trades
Project	Site Address London W1
Designer	Nicola Plummer
Project Director	Mome Smit


Tea Point Detail

TECHNICAL NO.	ACTY/TH005-01-TECH/02-A2-2011.09.26/rev 01/02/2011
Project	ACT-01
Drawn	EC
Date	28.09.2011

Project	ACT-01
Drawn	EC
Date	28.09.2011

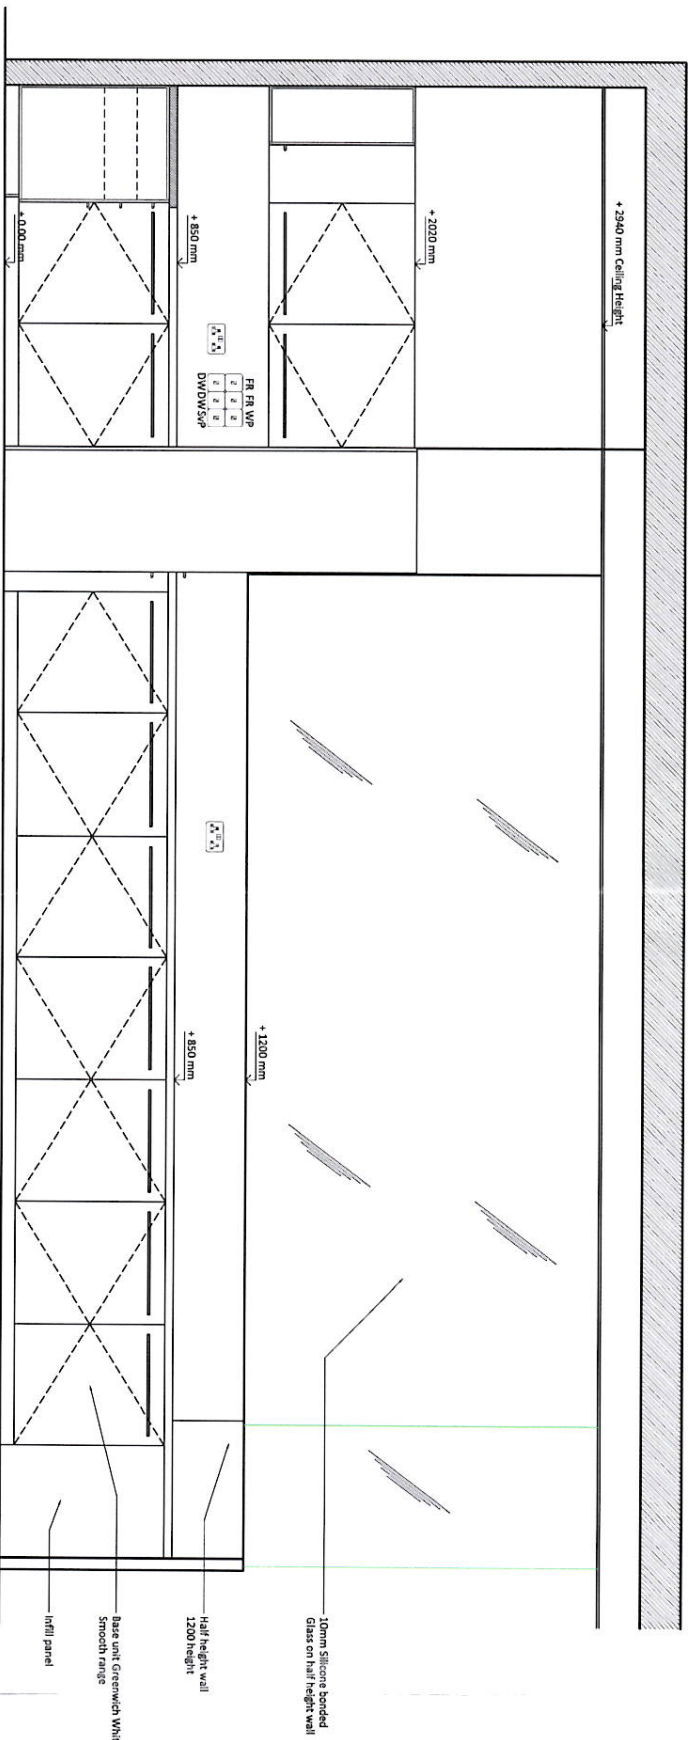

ELEVATION C-C
SCALE 1:25

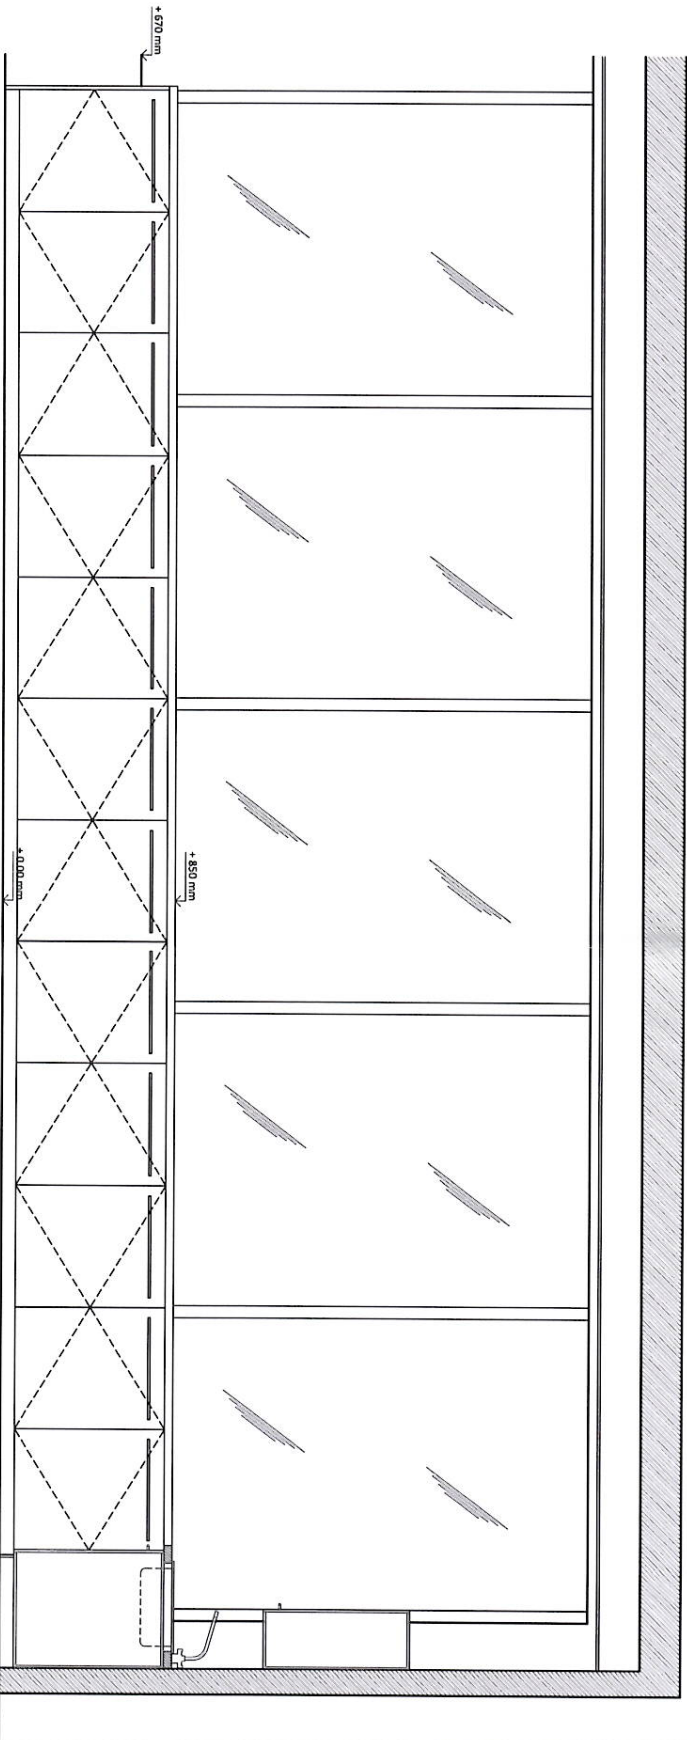

ELEVATION D-D
SCALE 1:25

- Notes
1. No dimensions are to be taken from this drawing. All dimensions are in millimetres.
 2. This drawing is to be read in conjunction with all relevant other drawings, details and specifications.
 3. All lines and markings on this drawing are to be confirmed on site by the contractor prior to commencement of the work and any discrepancies referred to the project director as a matter of urgency.

Rev	Description	Drawn	Date
-----	-------------	-------	------



www.cctinteriors.com

Subsidiary House, Level 3, 5-6 Knight Street, London, W1F 7TE

14-16 Old Bailey Street, 1st Floor, London, EC4A 3DF

Client	Activi Trades
Project	Site Address London W1
Designer	Nicola Plummer
Project Director	Morne Smit
Drawn	
Tea Point Detail	





TECHNICAL FILE NO.

ACTIV TRADES - 01 - TECH-01 - A2 - 2011.09.25 - long edge company 18.07.2011

Version	0.35	0.50	Scale
A2	1:25 B&W	1:25	

Date	28.09.2011	Drawn	EC
------	------------	-------	----

Project	ACT-01	Sheet	07	Est.	04	Level	01	Design	T
---------	--------	-------	----	------	----	-------	----	--------	---

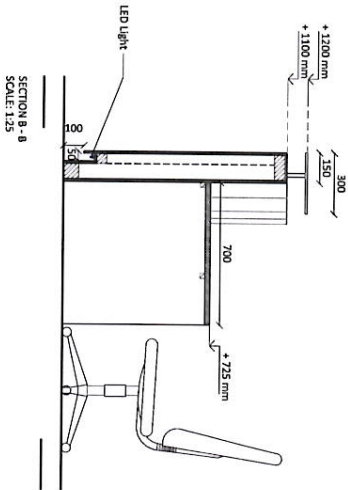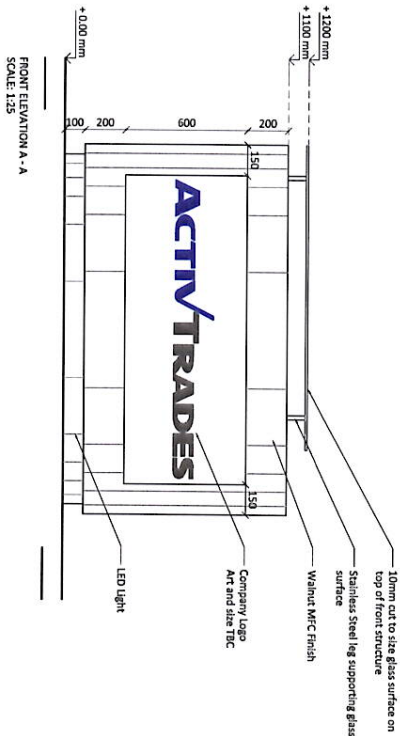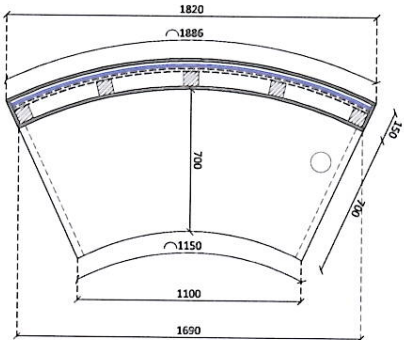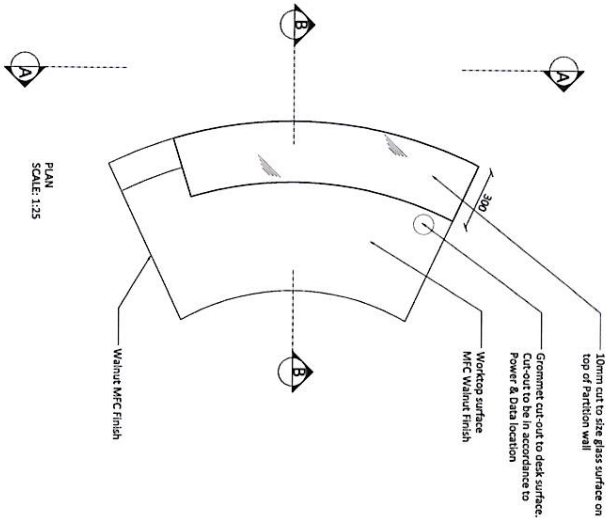

- Notes
1. No dimensions are to be scaled from this drawing. All dimensions are in millimetres.
 2. This drawing is to be read in conjunction with all relevant other drawings, details and specifications.
 3. All levels and setting out given on this drawing are to be confirmed on site by the contractor prior to commencement of the work and any discrepancies forwarded to the project director as a matter of urgency.

Rev	Description	Drawn	Date
-----	-------------	-------	------



www.cctinteriors.com
Sutherland House, Level 3, 248 Apsley Street, London, W1F 7TE
Tel: +44 (0) 20 303 3031 Fax: +44 (0) 20 303 3032

Client	Activ Trades
Project	Site Address London W1
Designer	Nicola Plummer
Project Director	Morne Smit
Drawings	Reception Desk Detail
Technical File No.	ACTVTRDES-01-TRSDesk-A2-2011.09.26-4mg-edgdy-zamparo.18.07.2011
Layout size	A2 1:25
Date	28.09.2011
Drawn	EC
Project	ACT-01
Scale	07
Rev	05
Load	01
Signify	T