
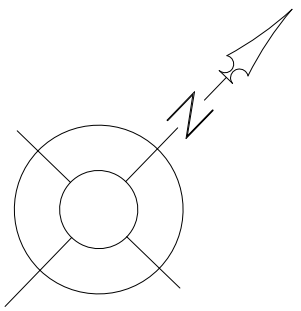


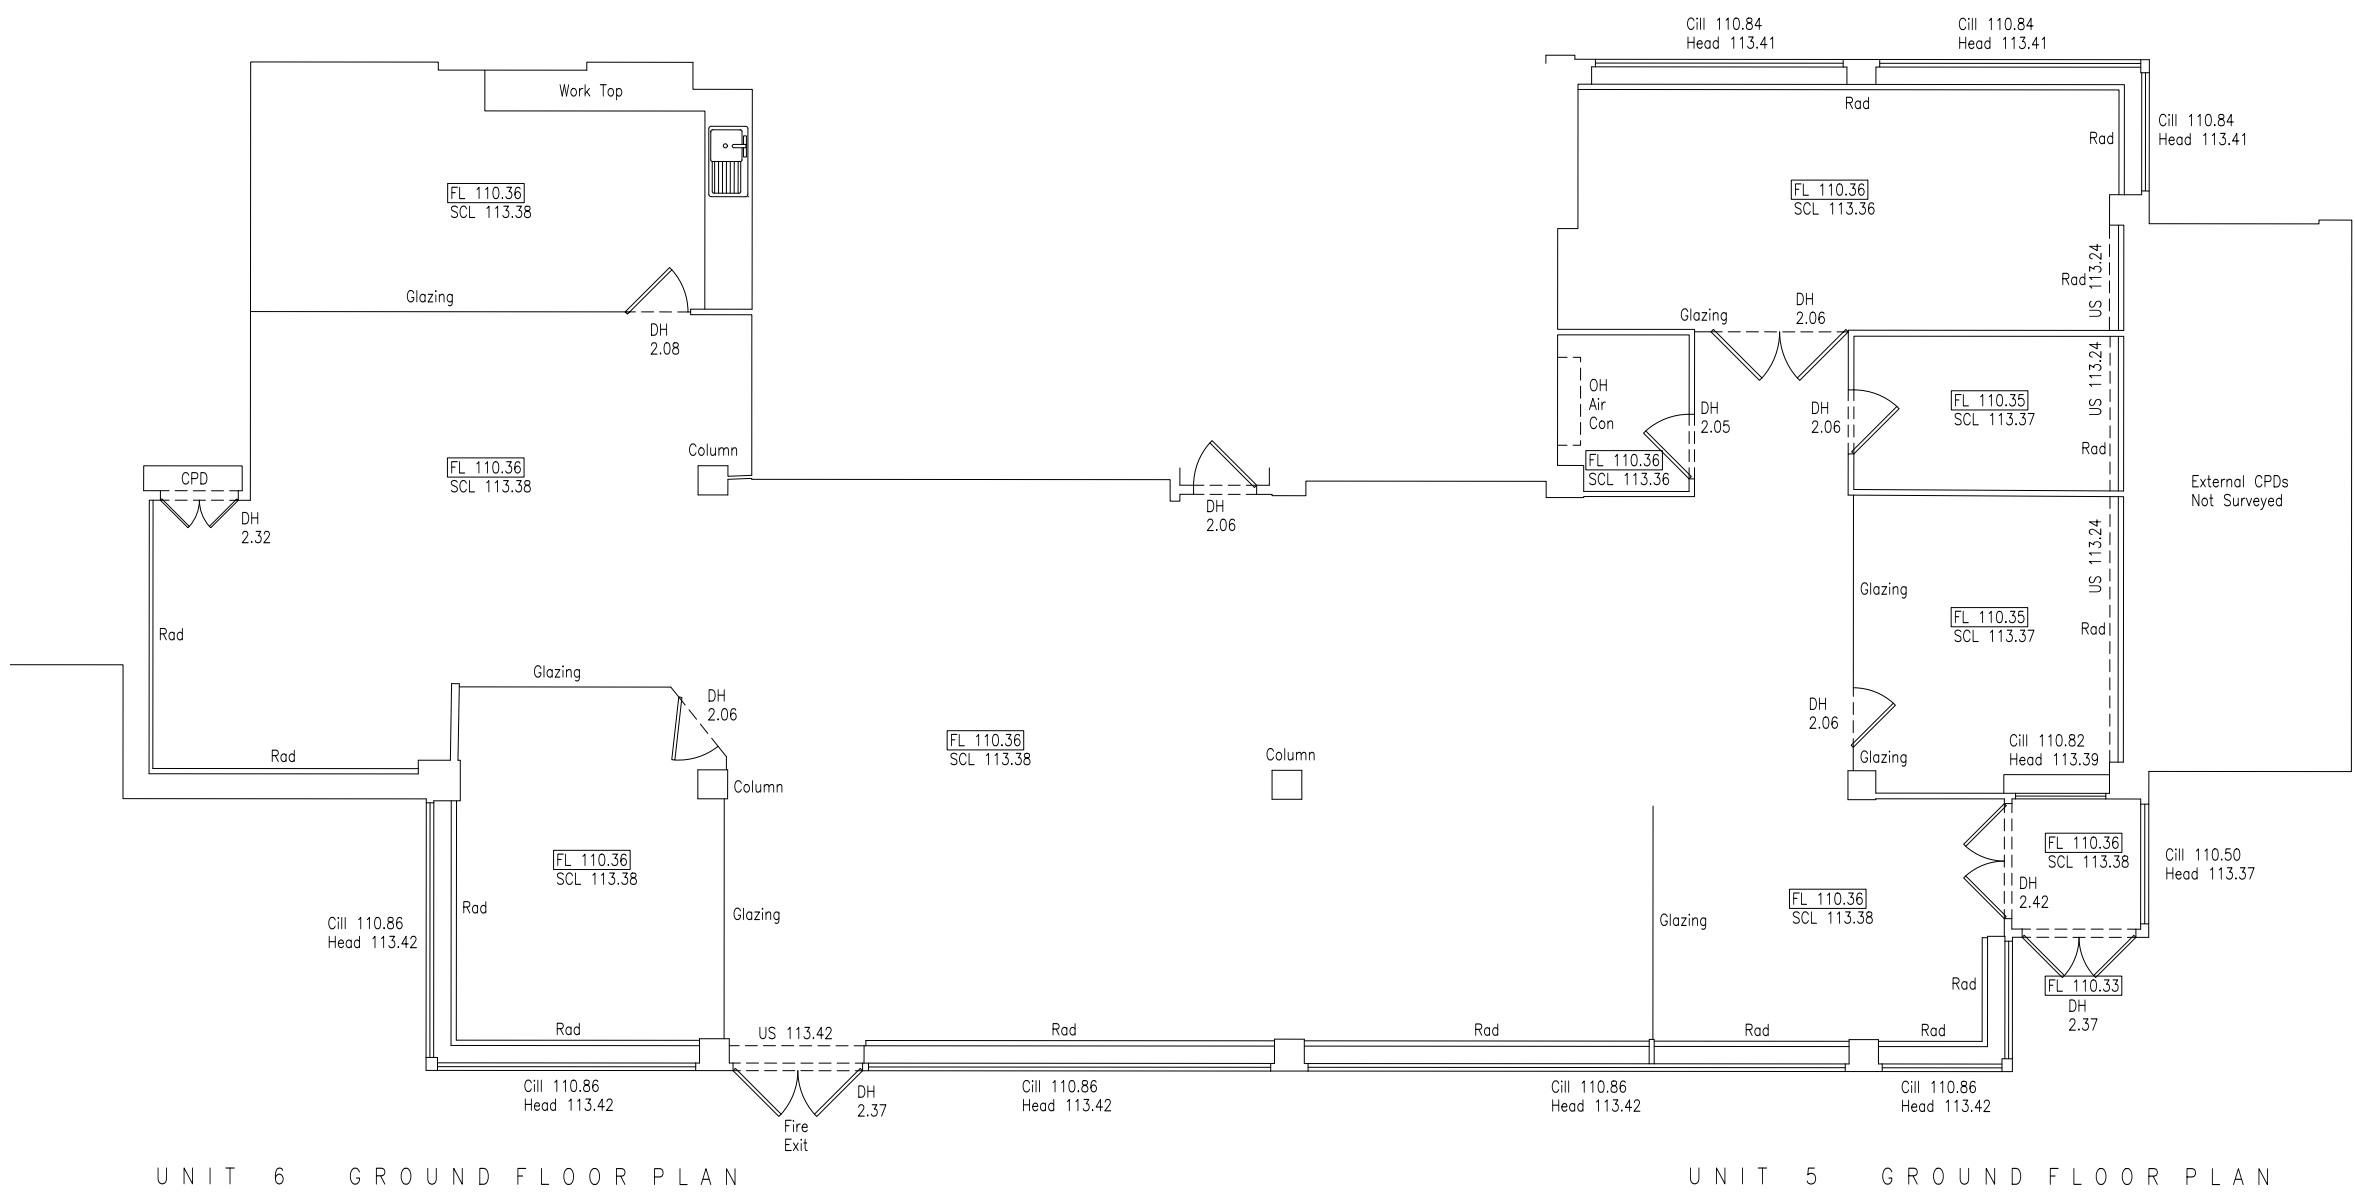

Legend:			
Abbreviated Features:	Symbols:		
AB Air Brick	LI Light	Radiator	AB
B Ballard	D/F Overflow Pipe	Light	⊗
C/B Clow Boarded	P Post	Emergency Light	⊗
C-H C/H to Head	P/C Pitched Ceiling	Strip Light	⊗
C/L Chain Link	PE Pipe	Wall Mounted Light	⊗
CL Ceiling Level	P/R Pitched Roof	Mains Point	⊗
CPD Cupboard	P/W Post & Wire	Blank Plate	⊗
CR Crown Point Level	RD Roller Door	Light Switch	⊗
DH Door Height	RNP Rainwater Pipe	Pendant Switch	⊗
Dr Drain	SD Sliding Doors	Isolator Switch	⊗
FE Fire Exit	SCL Suspended Ceiling Level	Alarm Bell	⊗
F-C Floor to C/H	SP Spring Point Level	Fire Alarm Push	⊗
FL Floor Level	SW Surface Water	Snow Detector	⊗
FW Four Water	US Underdrain	Alarm Panel	⊗
MH Manhole	US Underdrain	Thermotat	⊗
U Dully	US Underdrain	Modern	⊗
IC Inspection Chamber	U/L Unable To Lift	Fuse Box	⊗
LI Invert Level	VI Vent Pipe	Electric Box	⊗
I/R Iron Railings	VI Vent	Water Stop Tap	⊗
		Overhead Features	⊗

Plan Coordinate Control:-- N/A
Level Datum:-- All Levels relate to OSGB36 using GPS

Key:

Notes:

B	Communal areas removed	16/01/2026	SJH
A	Dimensions Added	14/01/2026	JR
REV	NOV NOTE	DATE	SIGNED

3 Brookfield, Duncan Close,
Moulton Park, Northampton, NN3 6WL
Tel: 01604 491543
Email: info@globalsurveys.co.uk

Site:	Units 5 & 6, Shenley Pavilions Chalkdell Drive Shenley Wood, MK5 6LB
Client:	The Parks Trust
Survey Title:	Measured Building Survey Floor Plans

Date	January 2026	Scale	1/100 @ A1
Dwg No.	25525-MBS-Unit 5	Surveyor	JR
Sheet	1 of 1	Checked	SJH