
 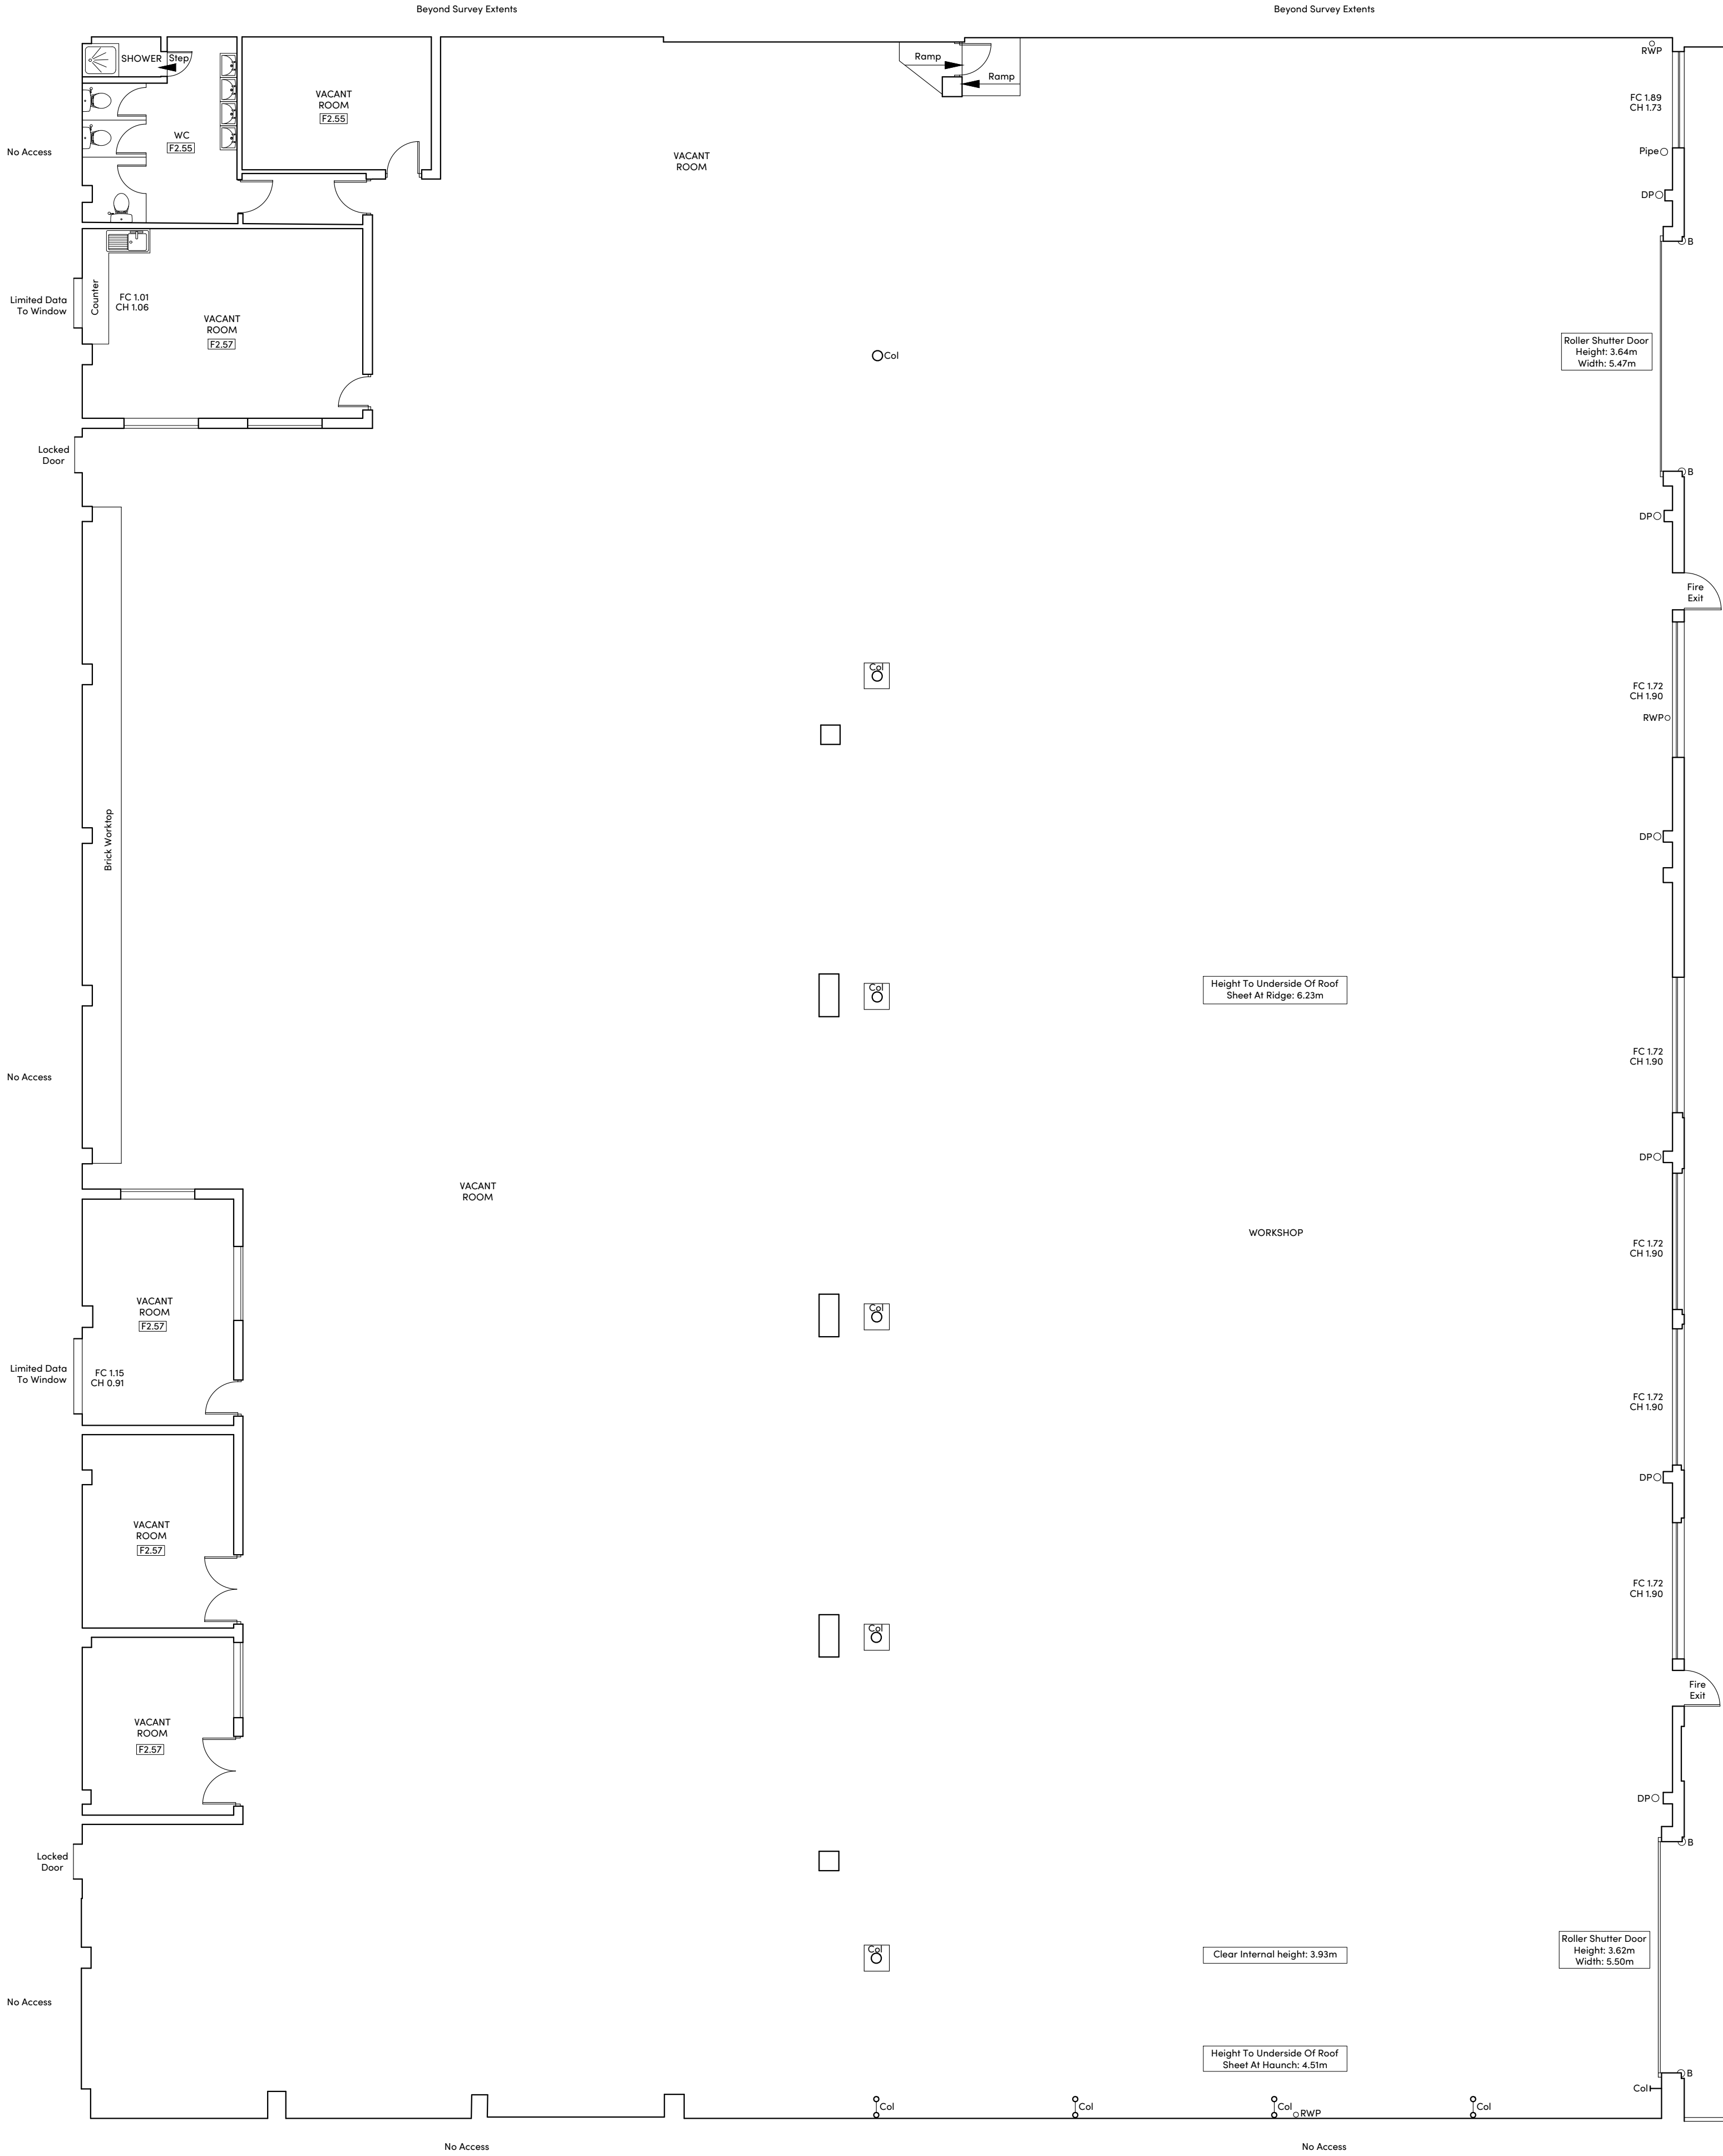


GROUND FLOOR



NOTES


- 1) ALL DIMENSIONS TO BE CHECKED ON SITE AND NOT SCALED FROM THIS DRAWING.
- 2) HOLLIS SHALL BE INFORMED IN WRITING OF ANY DISCREPANCIES.
- 3) ALL DIMENSIONS ARE IN METRES ONLY.
- 4) THE ORIGIN AND ORIENTATION OF THE SURVEY GRID RELATE TO AN ARBITRARY GRID.
- 5) ALL LEVELS ARE BASED ON AN ARBITRARY DATUM.

KEY

A	Alarm	NR	Handrail
A/C	Air Conditioner	IC	Inspection Cover
AA	Arch Height	ICM	Intercom
AL	Arch Level	IBF	Iron Rolling Fence
ASH	Arch Spring Height	JB	Junction Box
ASL	Arch Spring Level	L	Light
ATM	Automated Teller Machine	LB	Liter Bin
B	Balloon	MA	Maximum
BGP	Break Glass Point	MMH	Maximum Mounting Height
BH	Floor To Beam Height	Min	Minimum
B	Brick	OH	Overhead
BNW	Brick Reinforcing Wall	OSB	Open Boarded Fence
BSL	Beam Soffit Level	OSBM	Ordinance Survey Bench Mark
BW	Brick Wall	P	Post
BWF	Barbed Wire Fence	PL	Pavement Light
CB	Cigarette Bin	P&B	Post and Rail Fence
CBF	Close Boarded Fence	PS	Painting Stone
CCTV	Closed Circuit Television	PWF	Post and Wire Fence
CH	Chit To Head Height	R	Rail
Chy	Chimney	RDH	Recessed Door Head
CHF	Corrugated Iron Fence	RH	Ridge Haunch Height
CH	Clear Internal Height	B	Riser
CL	Cover Level	ESD	Roller Shutter Door
CLF	Chain Link Fence	RSJ	Reinforced Steel Joist
Col	Column	RW	Rolling Wall
Conc	Concrete	RWG	Rain Water Pipe With Gully
COW	Cable on Wall	RWP	Rain Water Pipe
CPS	Concrete Paving Slabs	SB	Sign Board
Cup	Cupboard	SBM	Site Bench Mark
DH	Door Height	SE	Security Fence
DP	Down Pipe	SH	Spring Height
D/C	Downspout Channel	SL	Staircase
DH	Duct Height	SO	Smoke Outlet
EB	Electrical Junction Box	SP	Sign Post
EM	Electricity Meter	SS	Security Sensor
ESG	Electrical Switchgear	T	Telephone
FA	Fire Alarm	TBM	Temporary Bench Mark
FB	Flower Bed	TLS	Threshold Level
FC	Floor To Cill Height	Tow	Top Of Wall
FL	Fire Escape	Typ	Typical
FLL	Finished Floor Level	U/L	Unable To Lift
FL	Floor Level	V	Vault
FHR	Fire Hose Reel	VCP	Vehicle Charging Point
G	Gully	VP	Vent Pipe
GM	Gas Meter	W	Window
GV	Gas Valve	WCL	Window Cill Level
h	Height	WH	Water Heater
HB	Hand Basin	WHL	Window Head Level
		WM	Water Meter

Proposed

FLOOR PLAN SYMBOLS

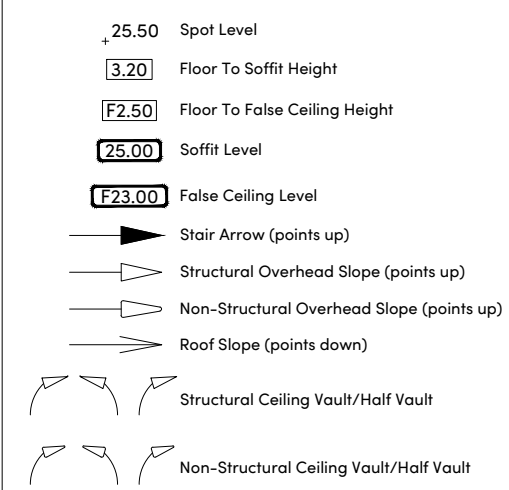

REVISIONS

REV.	DATE	AMENDMENTS	INITIAL

THIS DRAWING IS FOR THE FOLLOWING PURPOSE ONLY:
PRELIMINARY ☐ TENDER ☐ CONSTRUCTION ☐
SKETCH ☐ MEASURED SURVEY ☒ CONTRACT ☐

TITLE

PROPOSED FLOOR PLAN

CLIENT

TT Group
5 Aldermanbury Square
London
EC2V 7HR

PROJECT NAME

Northampton WTW & TEC
Gladstone Road
NN5 7QF

HOLLIS

Cubo
2 Chamberlain Square
Birmingham
B3 3AX

T +44 121 234 7860
W hollisglobal.com



DATE 09.01.2026		DRAWN BY CQ		
SCALE 1:100 @A1		CHECKED LM		
PROJECT	LINE	ORIGINATOR	VOLUME/ ZONE/BLDG	LEVEL
130744	104	HLS	00	00
FILE TYPE	DISCIPLINE/ ROLE	NUMBER	STATUS	REVISION
M2	B	10290	A1	C00