


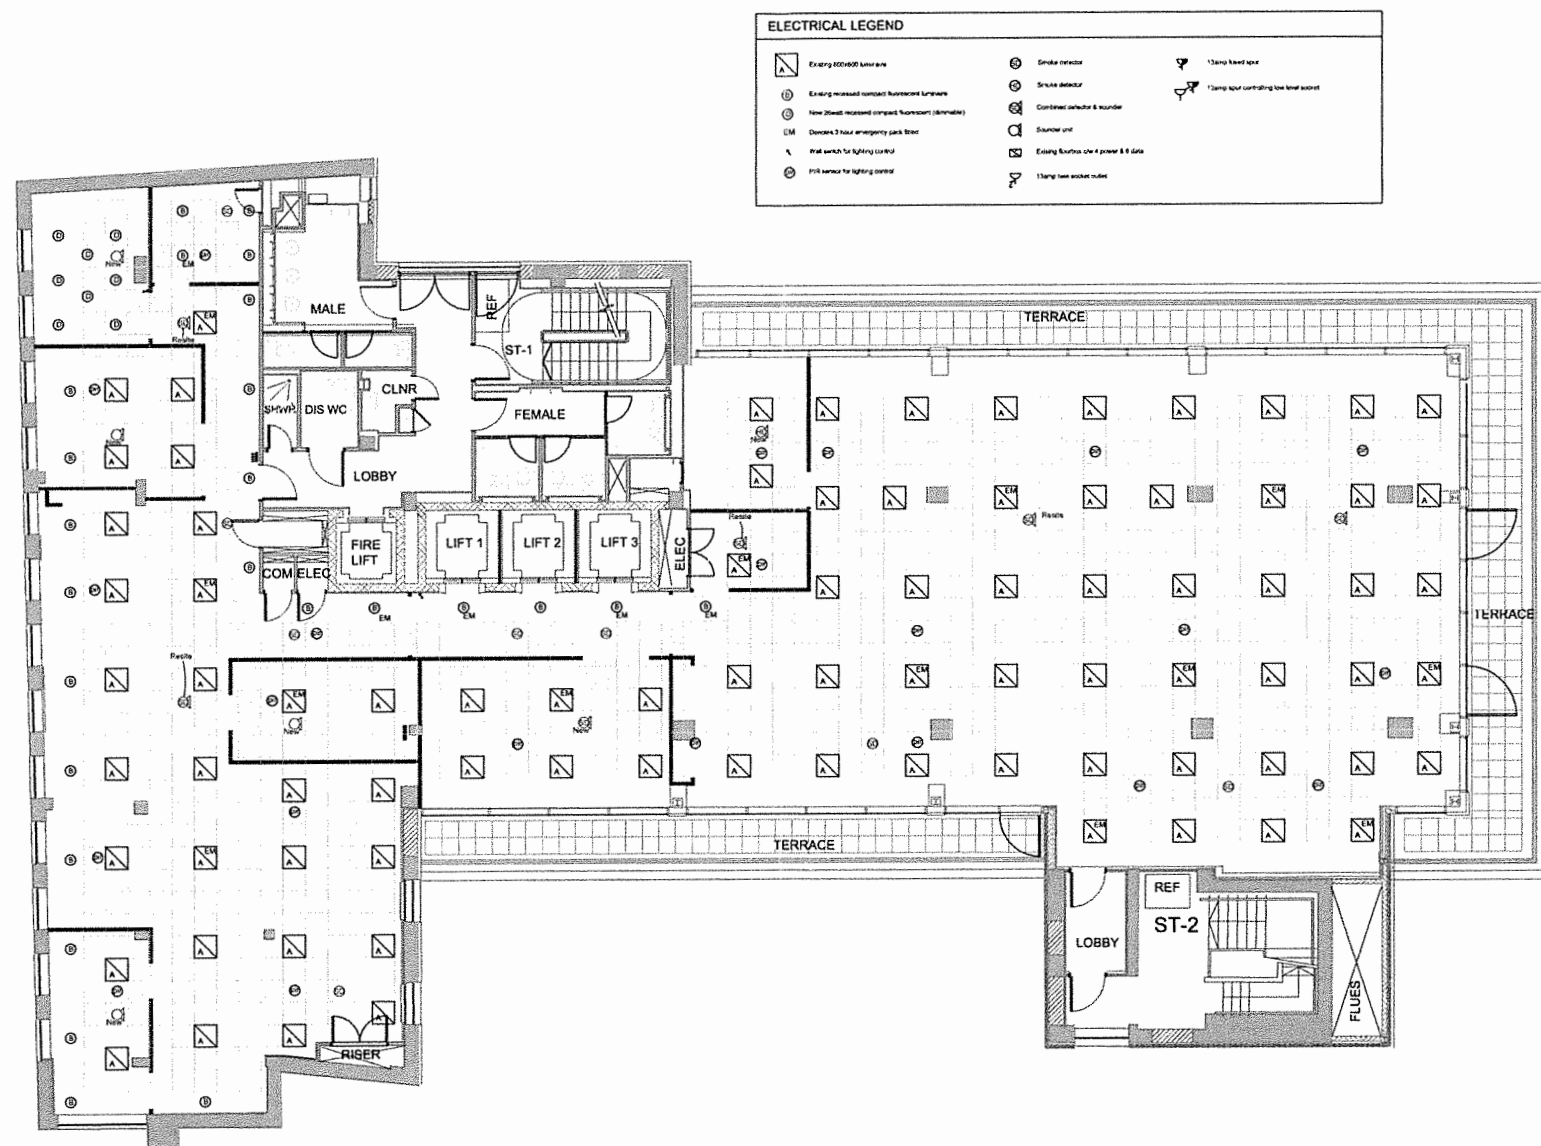

A	06/01	PROPOSED	DOC
REV	DATE	REVISION	BY

Unit 8 Devonshire Business Center
Cranborne Road
Petersham
Hants GU36 3JH
E-Mail: info@electricaltechnology.co.uk
Tel: 01707 644 828
Fax: 01707 644 838




Electrical Technology Ltd

PROJECT
MERRILL CORPORATION
EIGHT FLOOR
LIGHTING & FA LAYOUT

TITLE
165 FLEET STREET
LONDON EC4

JOB No	DATE	SCALE	DWG No	REV	BY
TBA	08/01/09	1/100	ET/LFA/PROP	A	DOC

BASE DRAWING INFORMATION					
CONTRACTOR	DATE	DWG No	REV		
AREA SQ LTD	NOV 08	2552L118/GA	F		

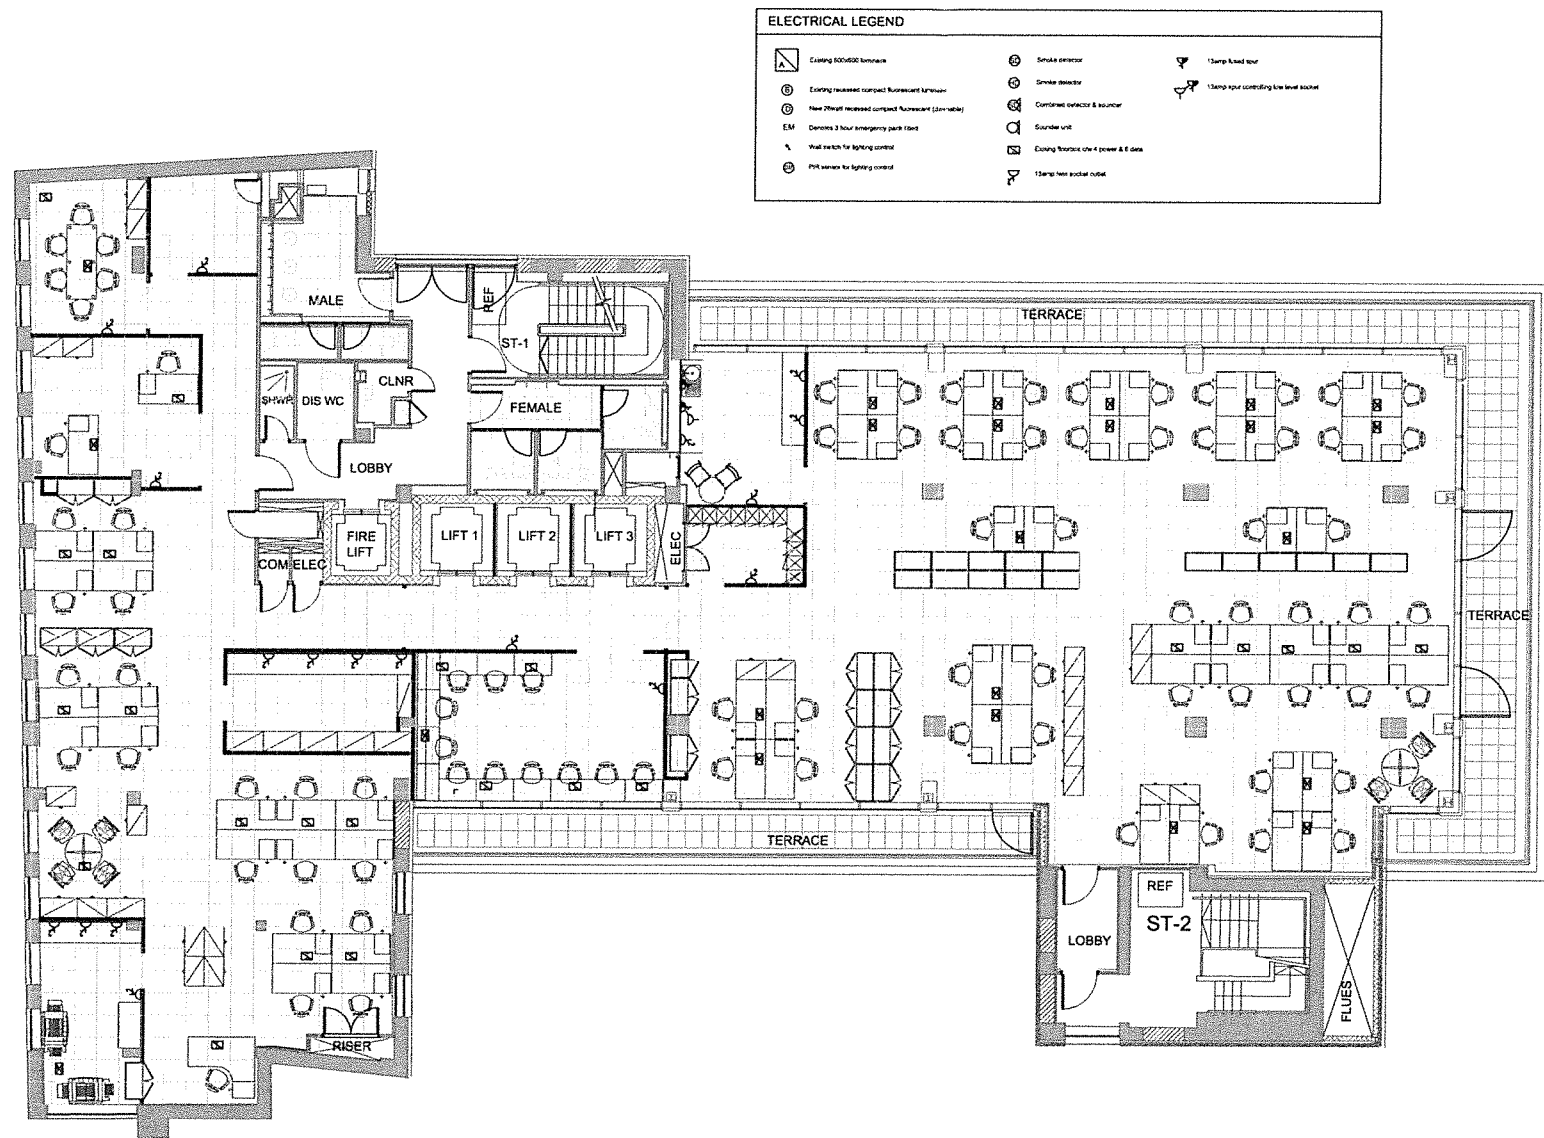

A	DAC1	PROPOSED		DOC
REV	DATE	REVISION		BY

Unit 9 Devonshire Business Center
Cranborne Road
Potters Bar
Herts EN6 3JR
E-Mail: info@electricaltechnology.co.uk
Tel: 01707 644 828
Fax: 01707 644 838



Electrical Technology Ltd

PROJECT
MERRILL CORPORATION
EIGHTH FLOOR
POWER LAYOUT

TITLE
165 FLEET STREET
LONDON EC4

JOB No	DATE	SCALE	DWG No	REV	BY
TBA	08/01/09	1/100	ETUP/PROP	A	DOC

BASE DRAWING INFORMATION					
CONTRACTOR	DATE	DWG No		REV	
AREA SQ LTD	NOV 08	2552L/1/8/GA		F	

