

DO NOT SCALE FROM THIS DRAWING. ALL DIMENSIONS TO BE CHECKED ON SITE. COPYRIGHT PROTECTED.

LIGHTING GENERAL NOTES:


- THIS DRAWING TO BE READ IN CONJUNCTION WITH THE ELECTRICAL SERVICES SCOPE OF WORKS, ASSOCIATED DESIGN DRAWINGS.
- LUMINAIRE SPECIFICATION INFORMATION IS DETAILED ON DRAWING SPECIFIC SCHEDULE AND PDF PRODUCT SHEETS
- ELECTRICAL CONTRACTOR ALLOWED FOR ATTENDANCE AND FINAL CONNECTIONS ILLUMINATED SIGNAGE, SIGNAGE CONTRACTOR
- ALL EMERGENCY LUMINAIRES IDENTIFIED USING ACCEPTABLE MANNER TO COMPLY WITH BS5266.
- SALES FLOOR STOCKING L1 (ST) & TRADING L2 (TR) CIRCUITS CONTACTOR CONTROLLED VIA 'LAST MAN OUT SWITCH'

FIXTURES MARKED WITH EITHER A CIRCULAR OR RECTANGULAR CALLIGRAPHY BUBBLE ARE NOTED TO BE EMERGENCY LUMINAIRES OR FIXTURES EITHER EMERGENCY BATTERY PACKS. SEE LIGHTING LEGEND FOR SPECIFICATION OF LUMINAIRE.


LIGHTING SPECIFICATIONS:
EMERGENCY LIGHTING DESIGN IN ACCORDANCE WITH BS5266-1 AND IEE BS7671 17TH EDITION REGULATIONS.
ALL EMERGENCY LIGHTING PROVIDED WITH INTEGRAL BATTERY PACK TO PROVIDE ILLUMINATION FOR 3 HOURS.
SUITABLE ENGRAVED TEST KEY PROVIDED TO TEST EMERGENCY LIGHTING.

LIGHTING SCHEDULE


- A** Fana Recessed
LED Modular Recessed Ceiling
Opal Diffuser - 3750lm - 35W - 830
Colour: White (RAL 9003) - Integral LED Driver
Order No.
- B** LED Surface Mounted Flat Disc Luminaire
Opal Diffuser - 1226lm - 18W
Colour: White (RAL 9003) - Integral LED Driver
Order No.
- C** LED Batten (pendant mounted)
- E1** Ansell AG LED/3M
3W Bulkhead
- E2** Ansell AG8/3M/W
Exit Sign
- E3** Ansell ASLED/3NM
1.5W Non Maintained Signal LED
Emergency Downlight
- EM** FIXTURES MARKED WITH "EM" TO HAVE EMERGENCY BATTERY PACK AND PROVIDE ILLUMINATION FOR 3 HOURS.
- PIR** PIR LIGHTING CONTROL ON CEILING

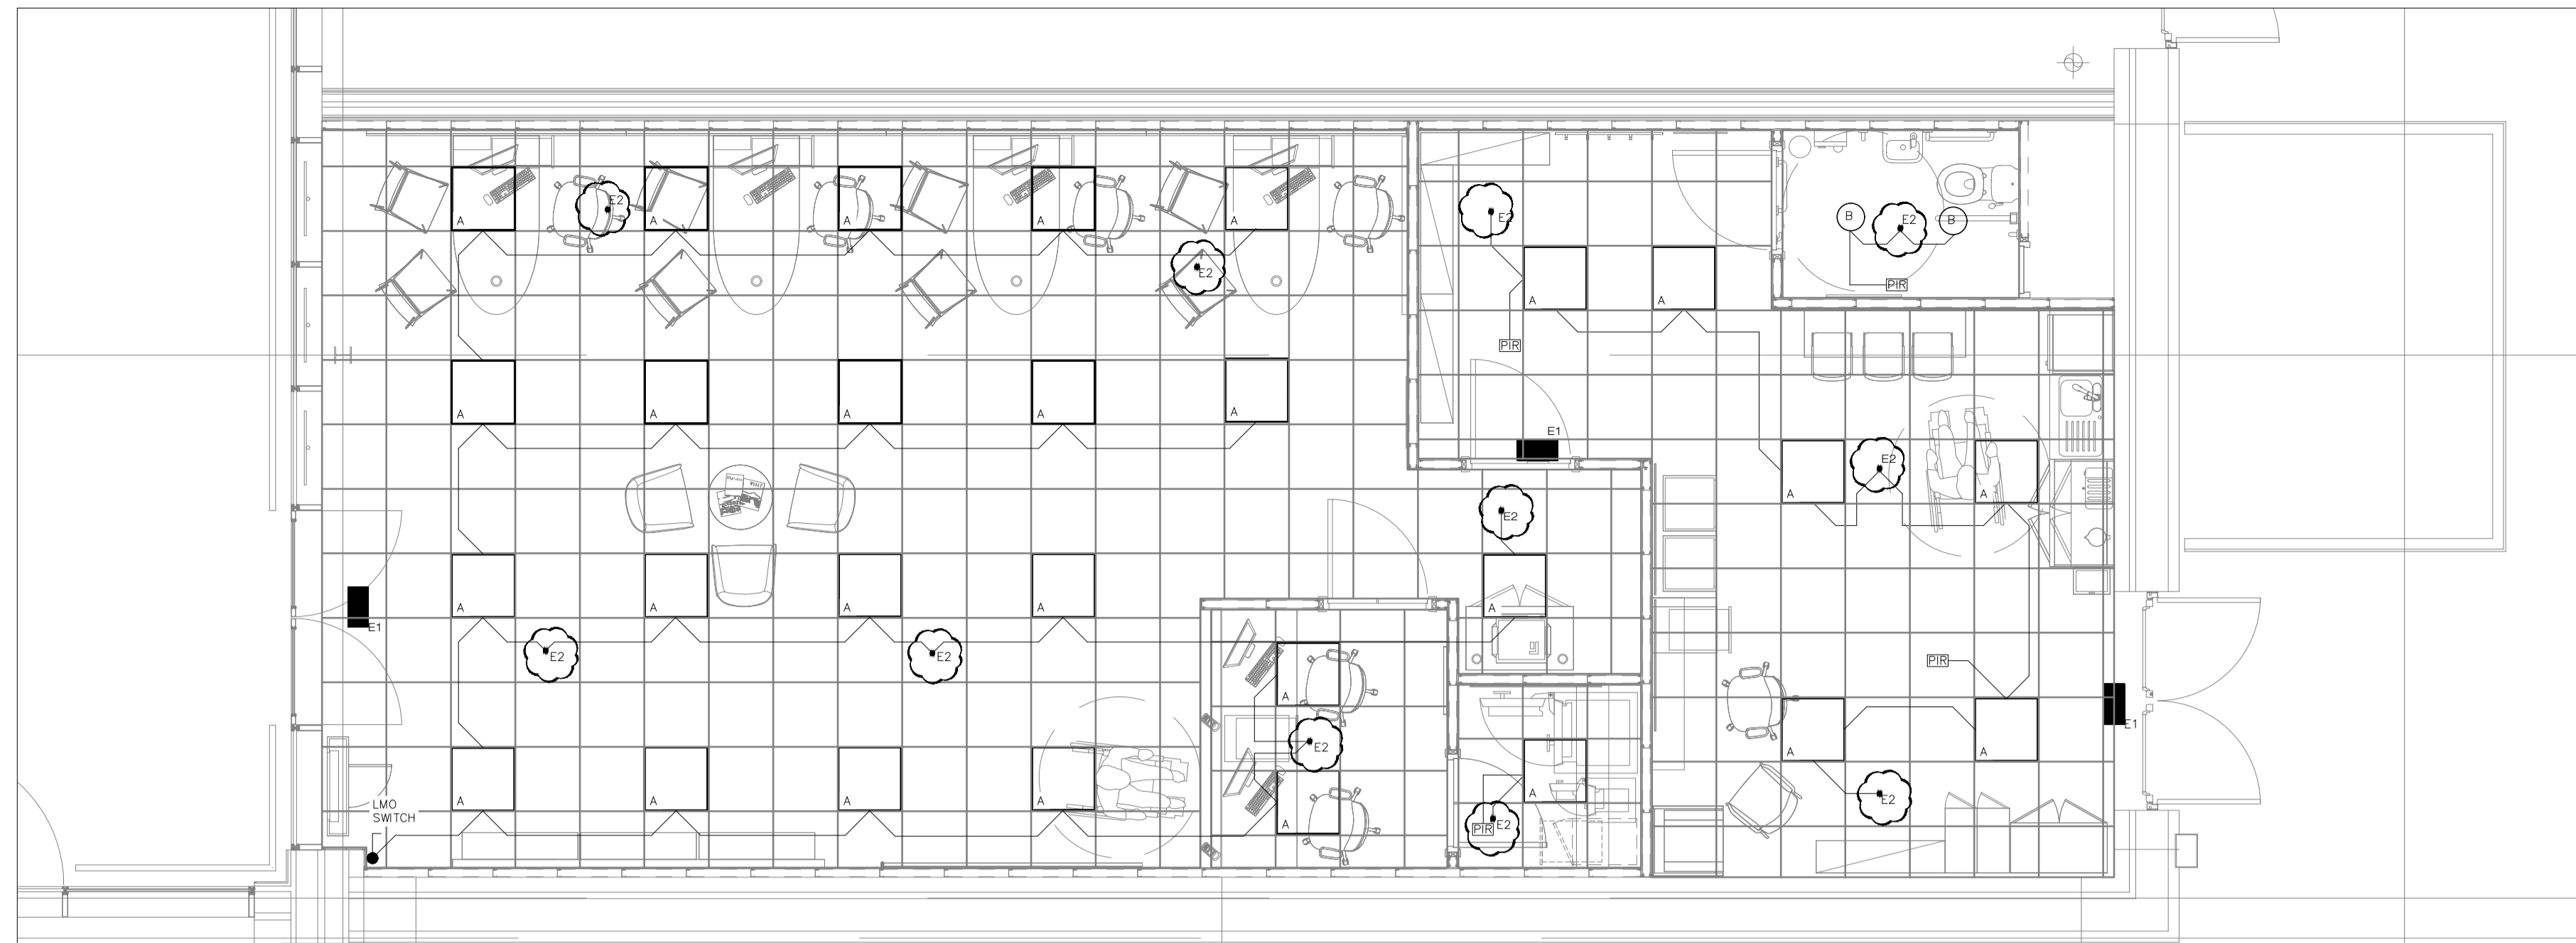


A GROUND FLOOR - LIGHTING PLAN
E-101 SCALE - 1:50

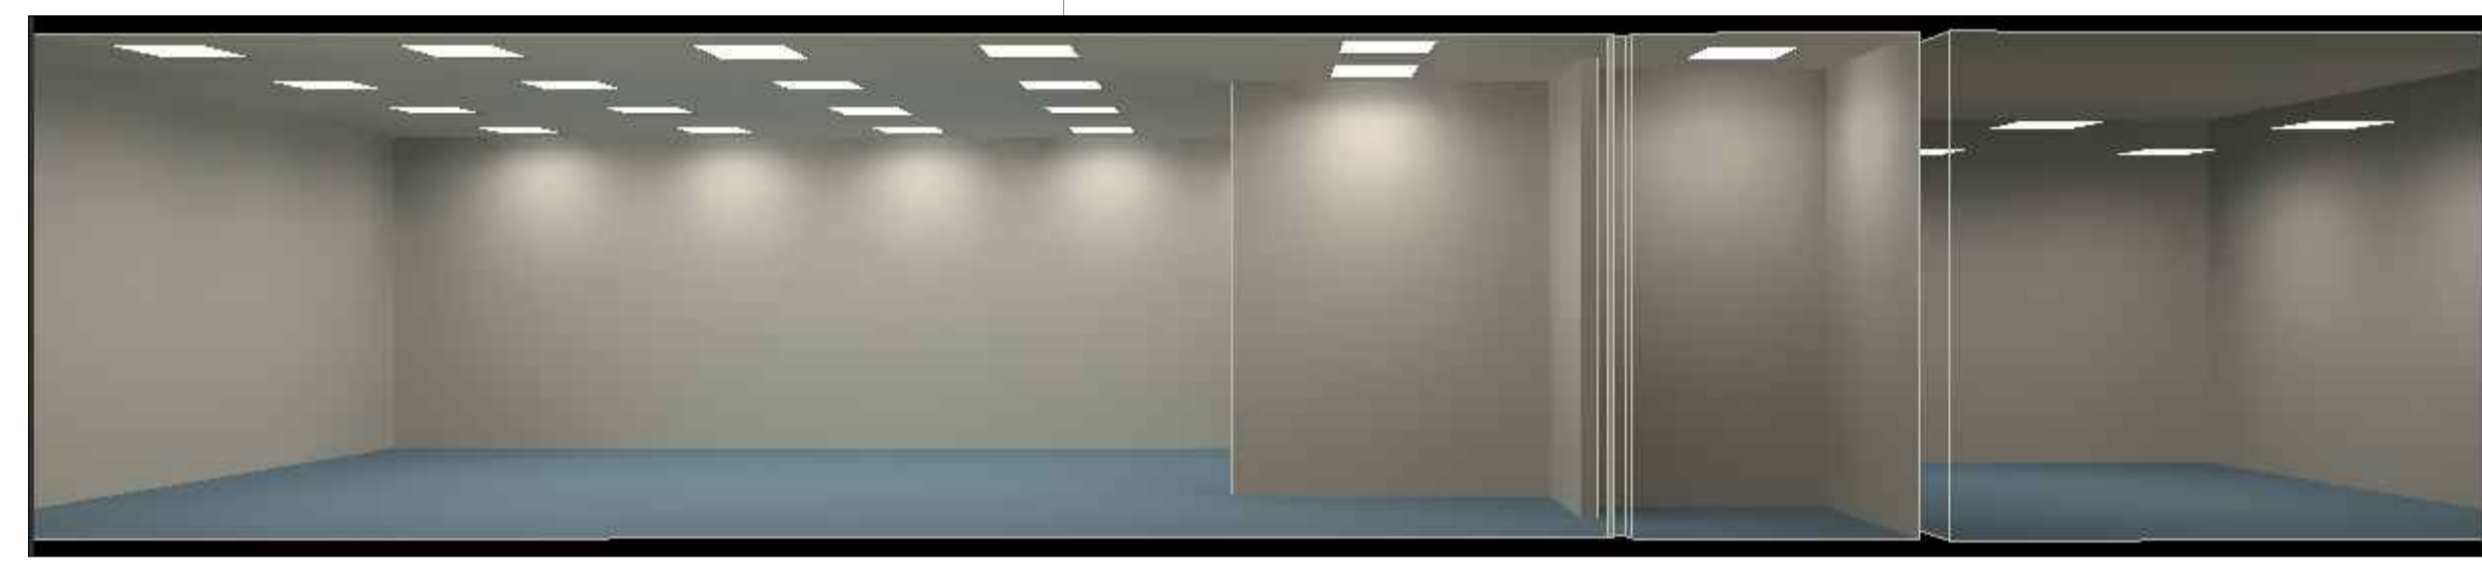


C LIGHTING LUX LEVELS - SECTION A-A
E-101 SCALE - NTS

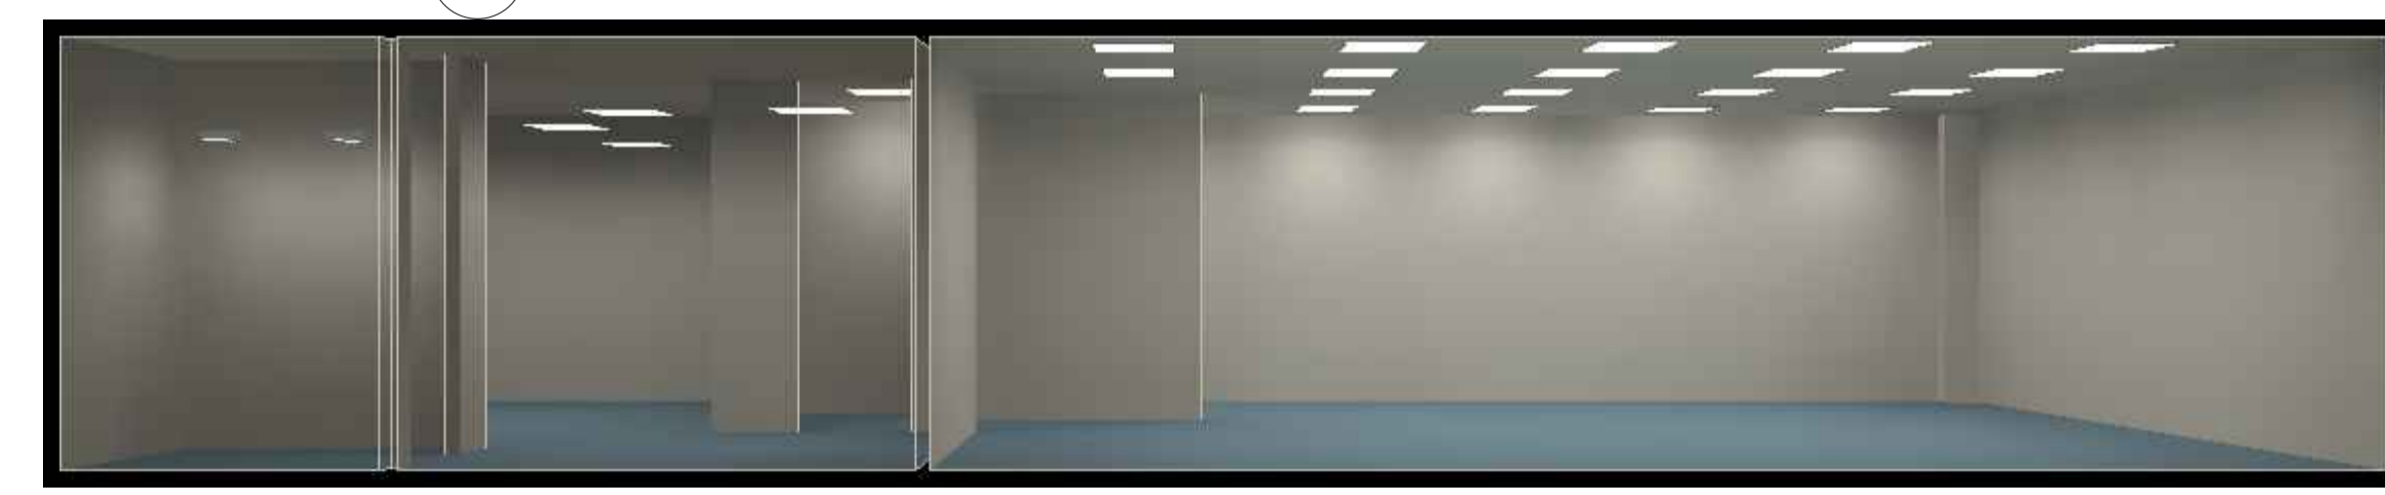


D LIGHTING LUX LEVELS - SECTION B-B
E-101 SCALE - NTS

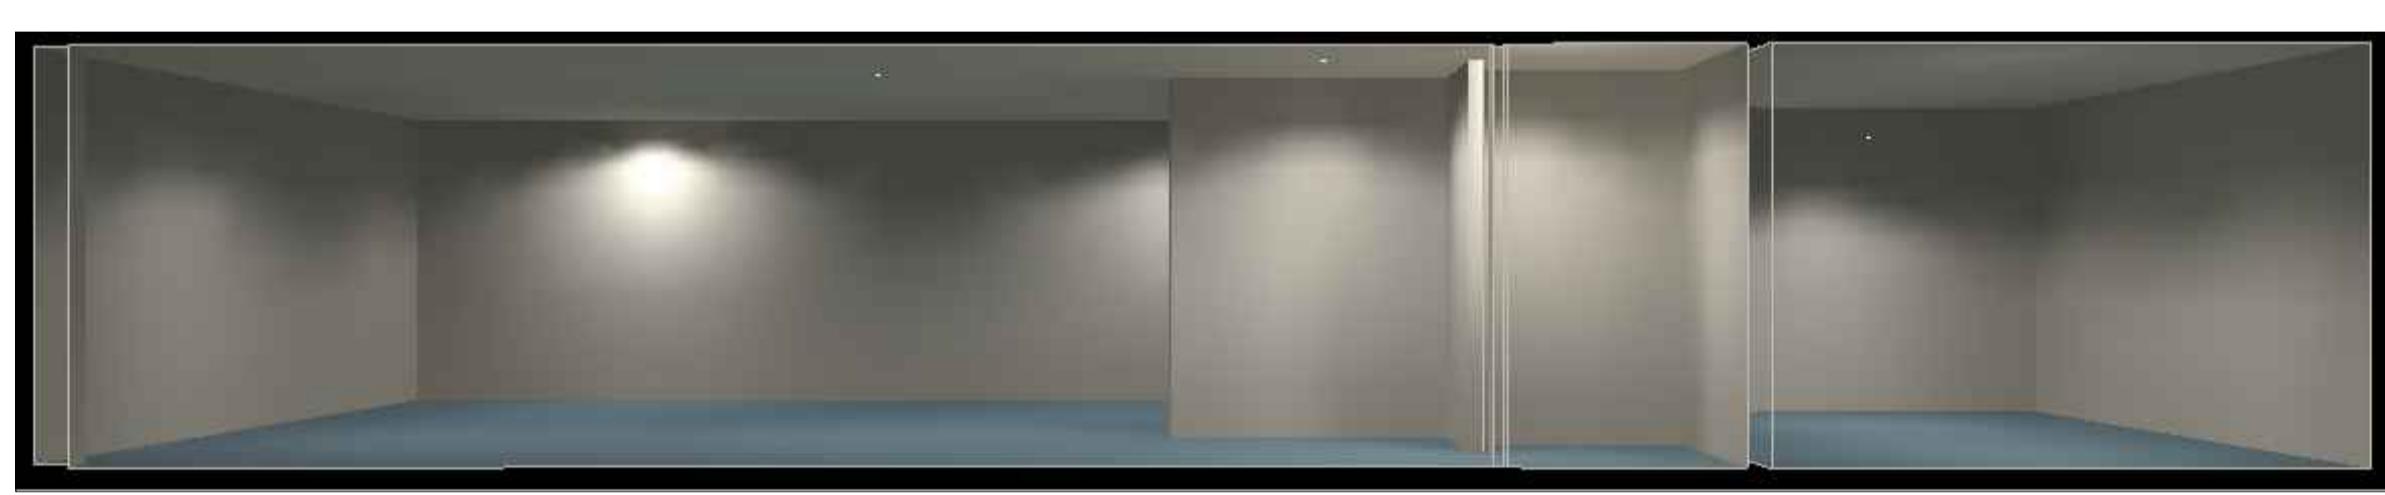


E EMERGENCY LIGHTING LUX LEVELS - SECTION A-A
E-101 SCALE - NTS

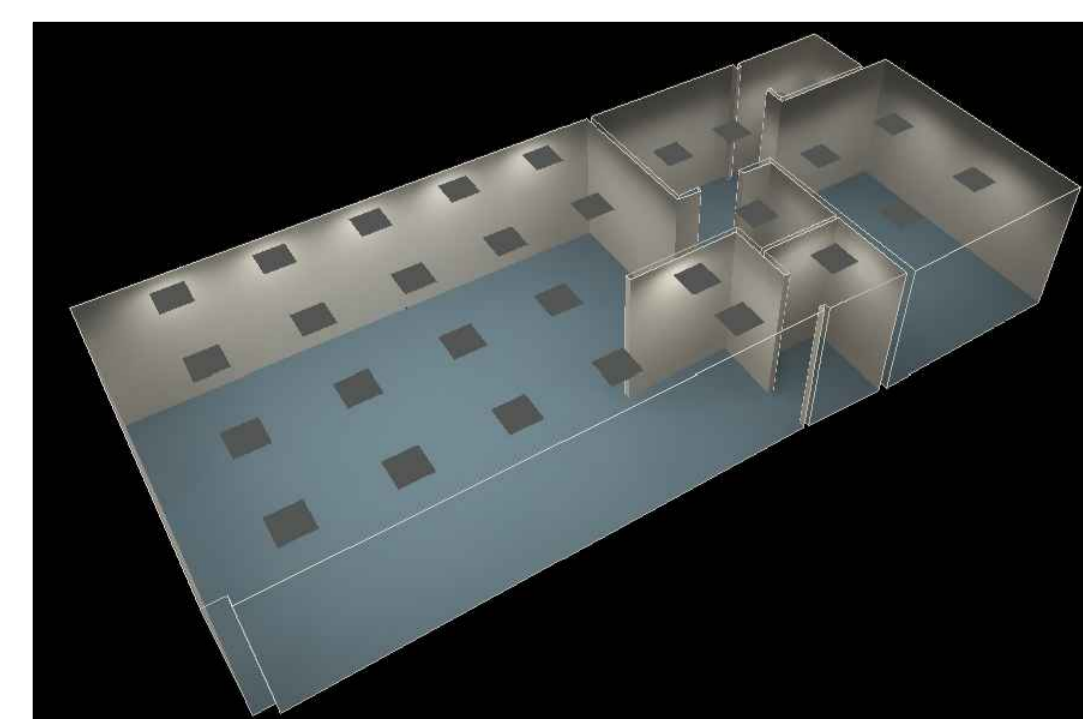


F LIGHTING LUX LEVELS - AXONOMETRIC VIEW
E-101 SCALE - NTS

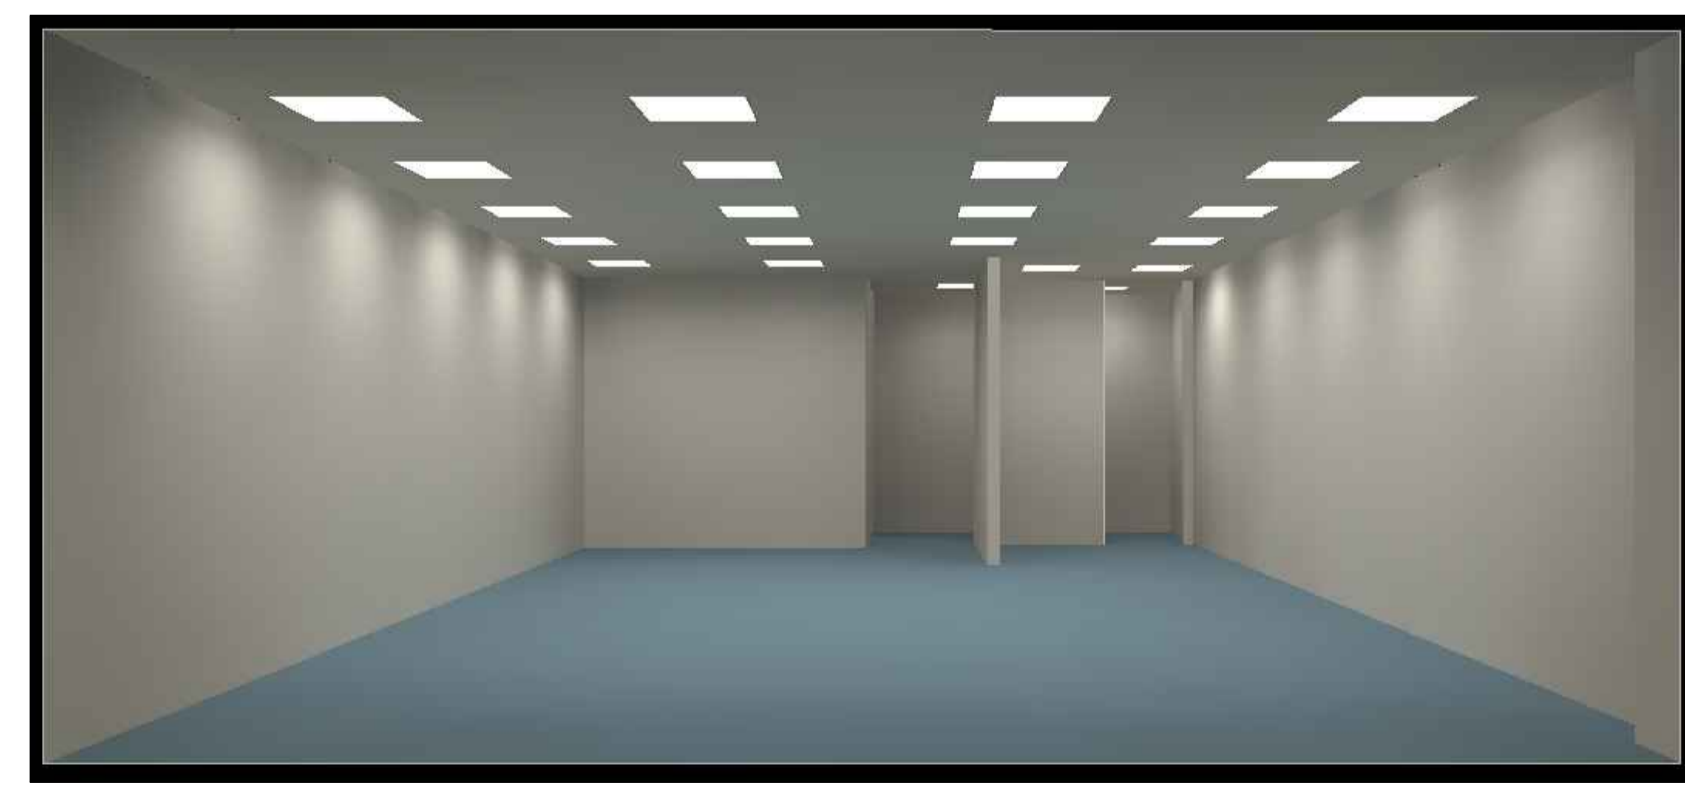

G LIGHTING LUX LEVELS - FRONT ENTRANCE
E-101 SCALE - NTS

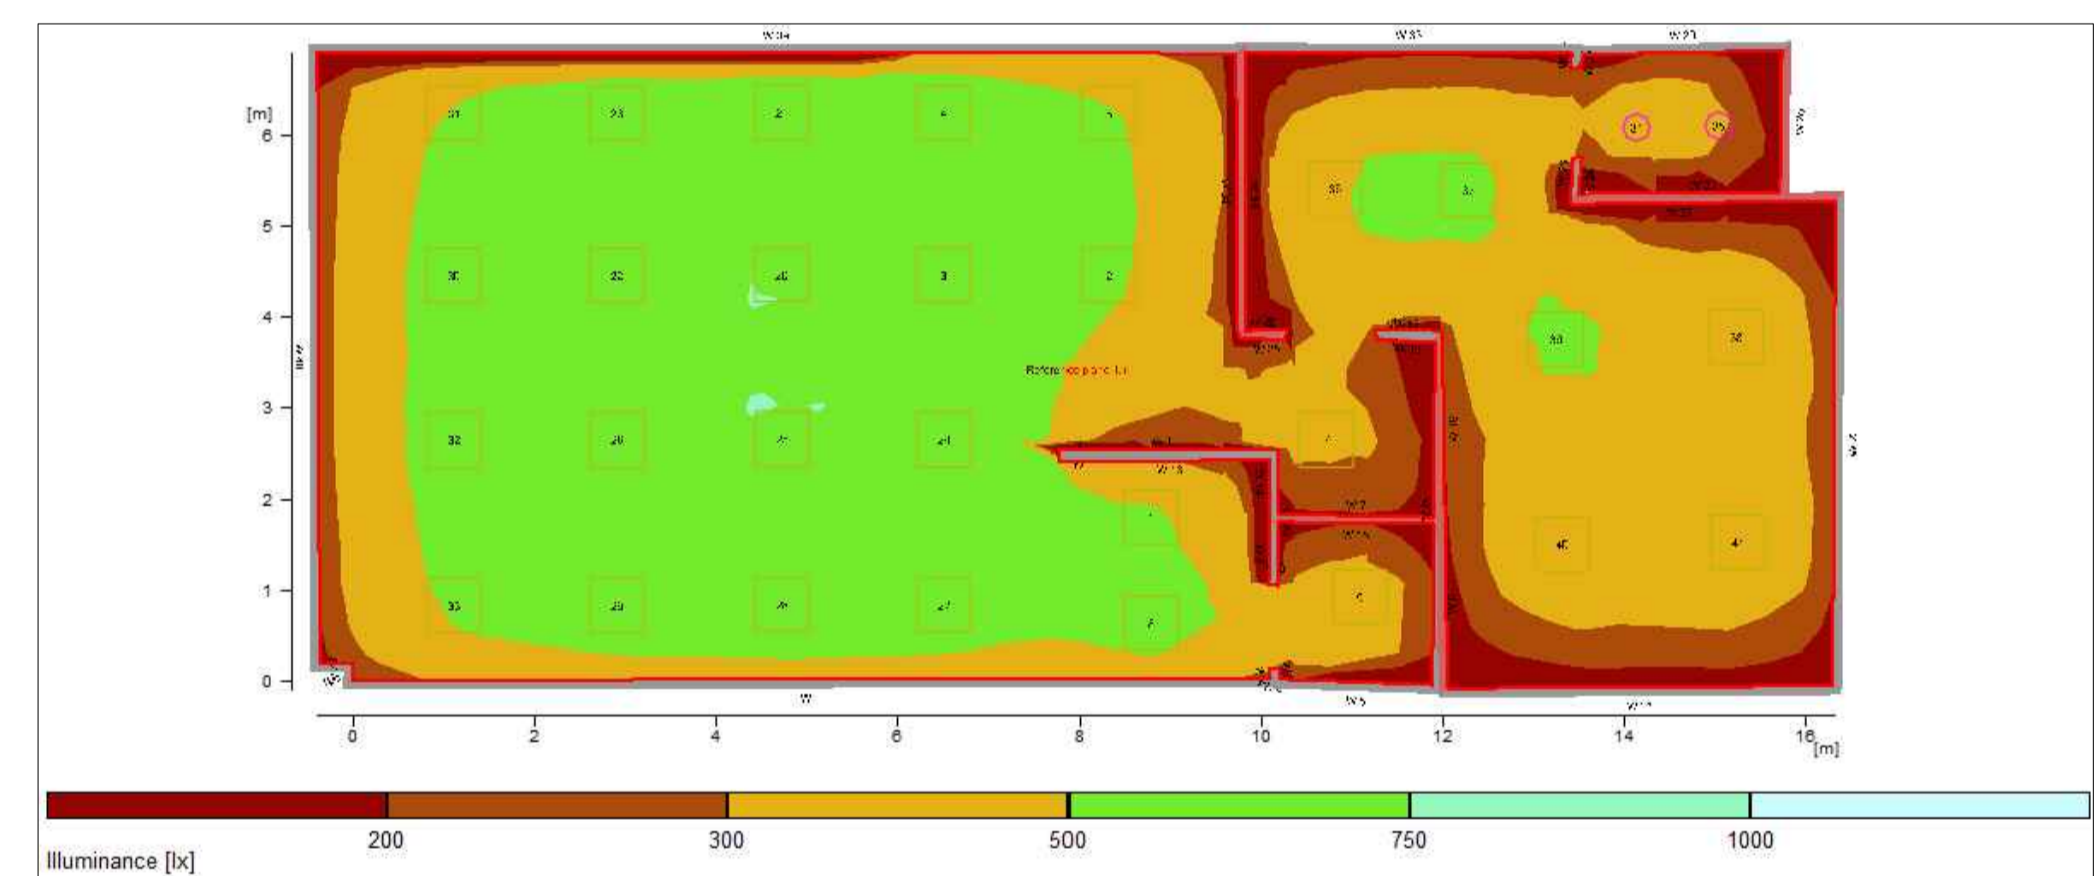

B LIGHTING LUX LEVELS
E-101 SCALE - NTS

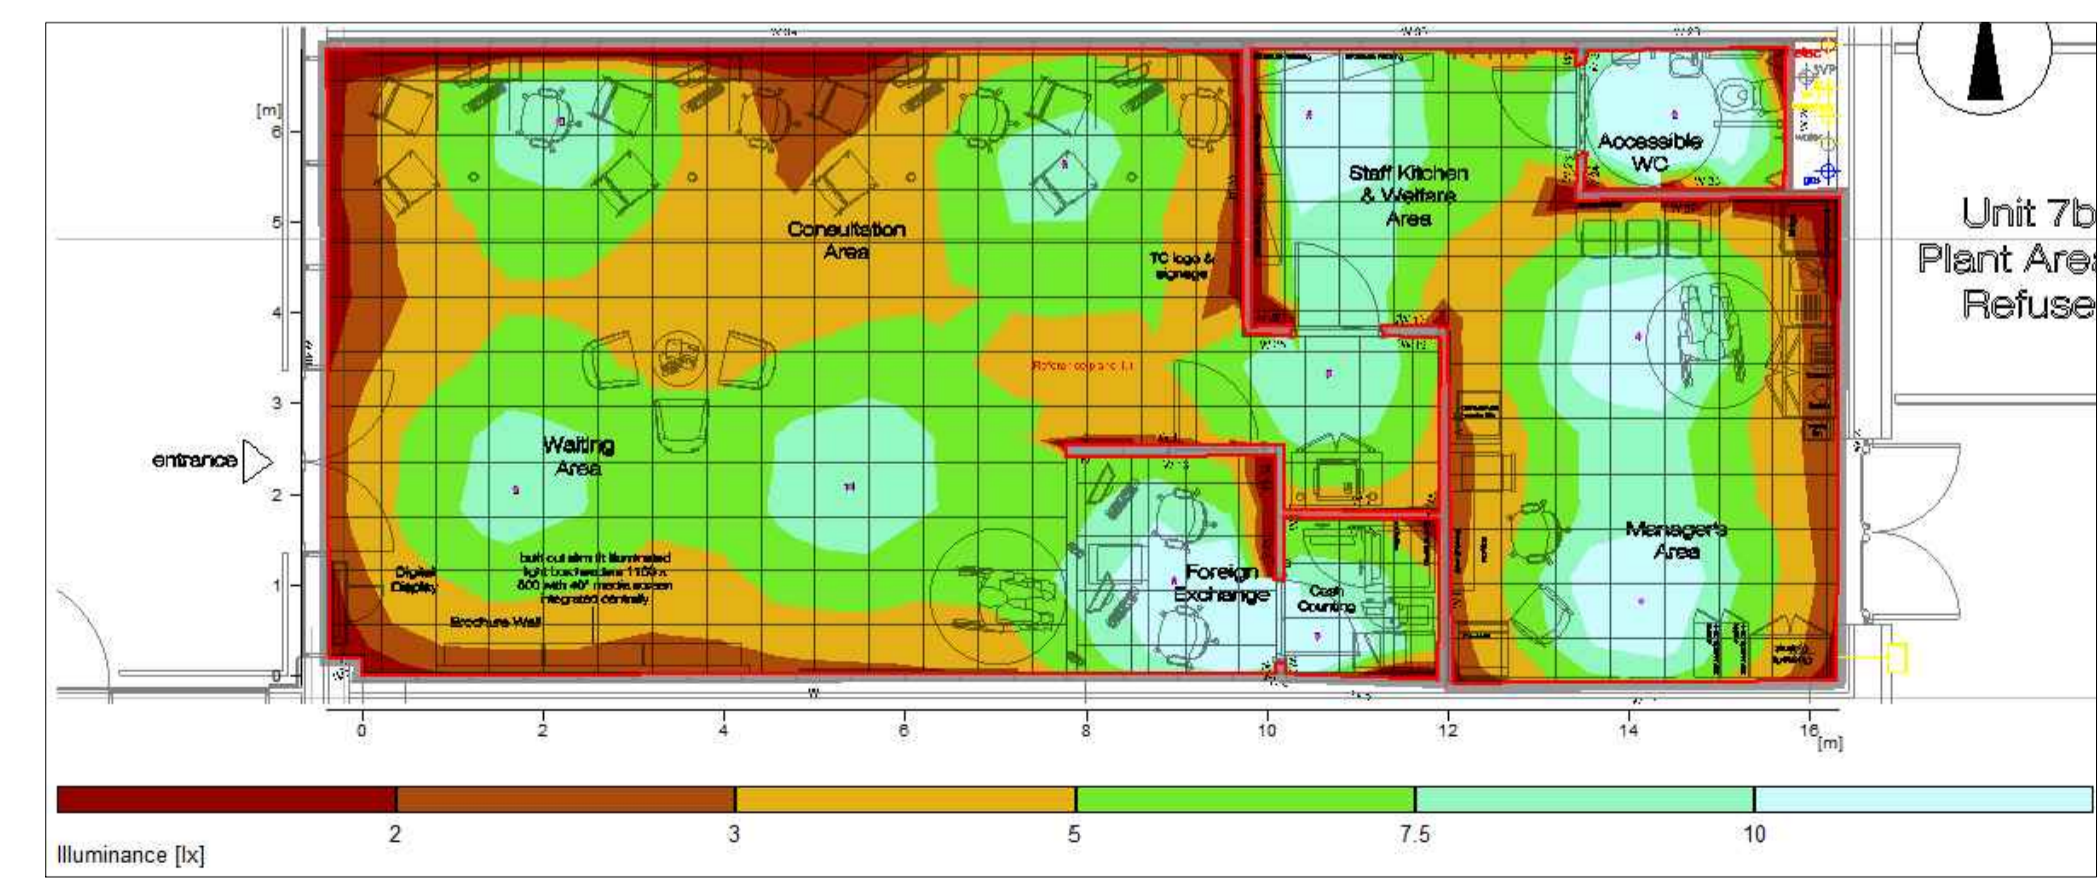

B EMERGENCY LIGHTING LUX LEVELS
E-101 SCALE - NTS

REV	DESCRIPTION	DRAWN	CHECKED	DATE
CONSTRUCTION				
Client Name				
Project				
Drawing Title LIGHTING PLAN				
Drawing No.		Rev.		
Job No.	Scale			